

NOTES

1. ALL DIMENSIONS IN MILLIMETERS UNLESS OTHERWISE SPECIFIED.
2. ALL EXTERIOR AREAS SHALL BE MECHANICALLY LIT AND VENTILATED WITH 100% POWER BACKUP.
3. GATE AND BOUNDARY WALL SHALL BE AS PER STANDARD DESIGN.
4. SOLAR WATER HEATING SYSTEM TO BE PROVIDED FOR ALL APARTMENTS AND OPERATIONAL BEFORE APPLYING FOR OCCUPANCY CERTIFICATE.
5. RAIN WATER HARVESTING SYSTEM SHALL BE AS PER STANDARD DESIGN.
6. FIRE FIGHTING PROVISIONS INCLUDING FIRE SPRINKLERS SHALL BE AS PER NBC GUIDELINES.


REV	DESCRIPTION	DATE	REMARK
1	GENERAL REVISIONS	22.12.2015	

PROPOSED BUILT UP-
FOR DETAILED PLAN,
REFER DWG NO.
MP-PH2-001 & MP-PH2-002

REVISED BLOCK

SECTOR 112

KEY PLAN

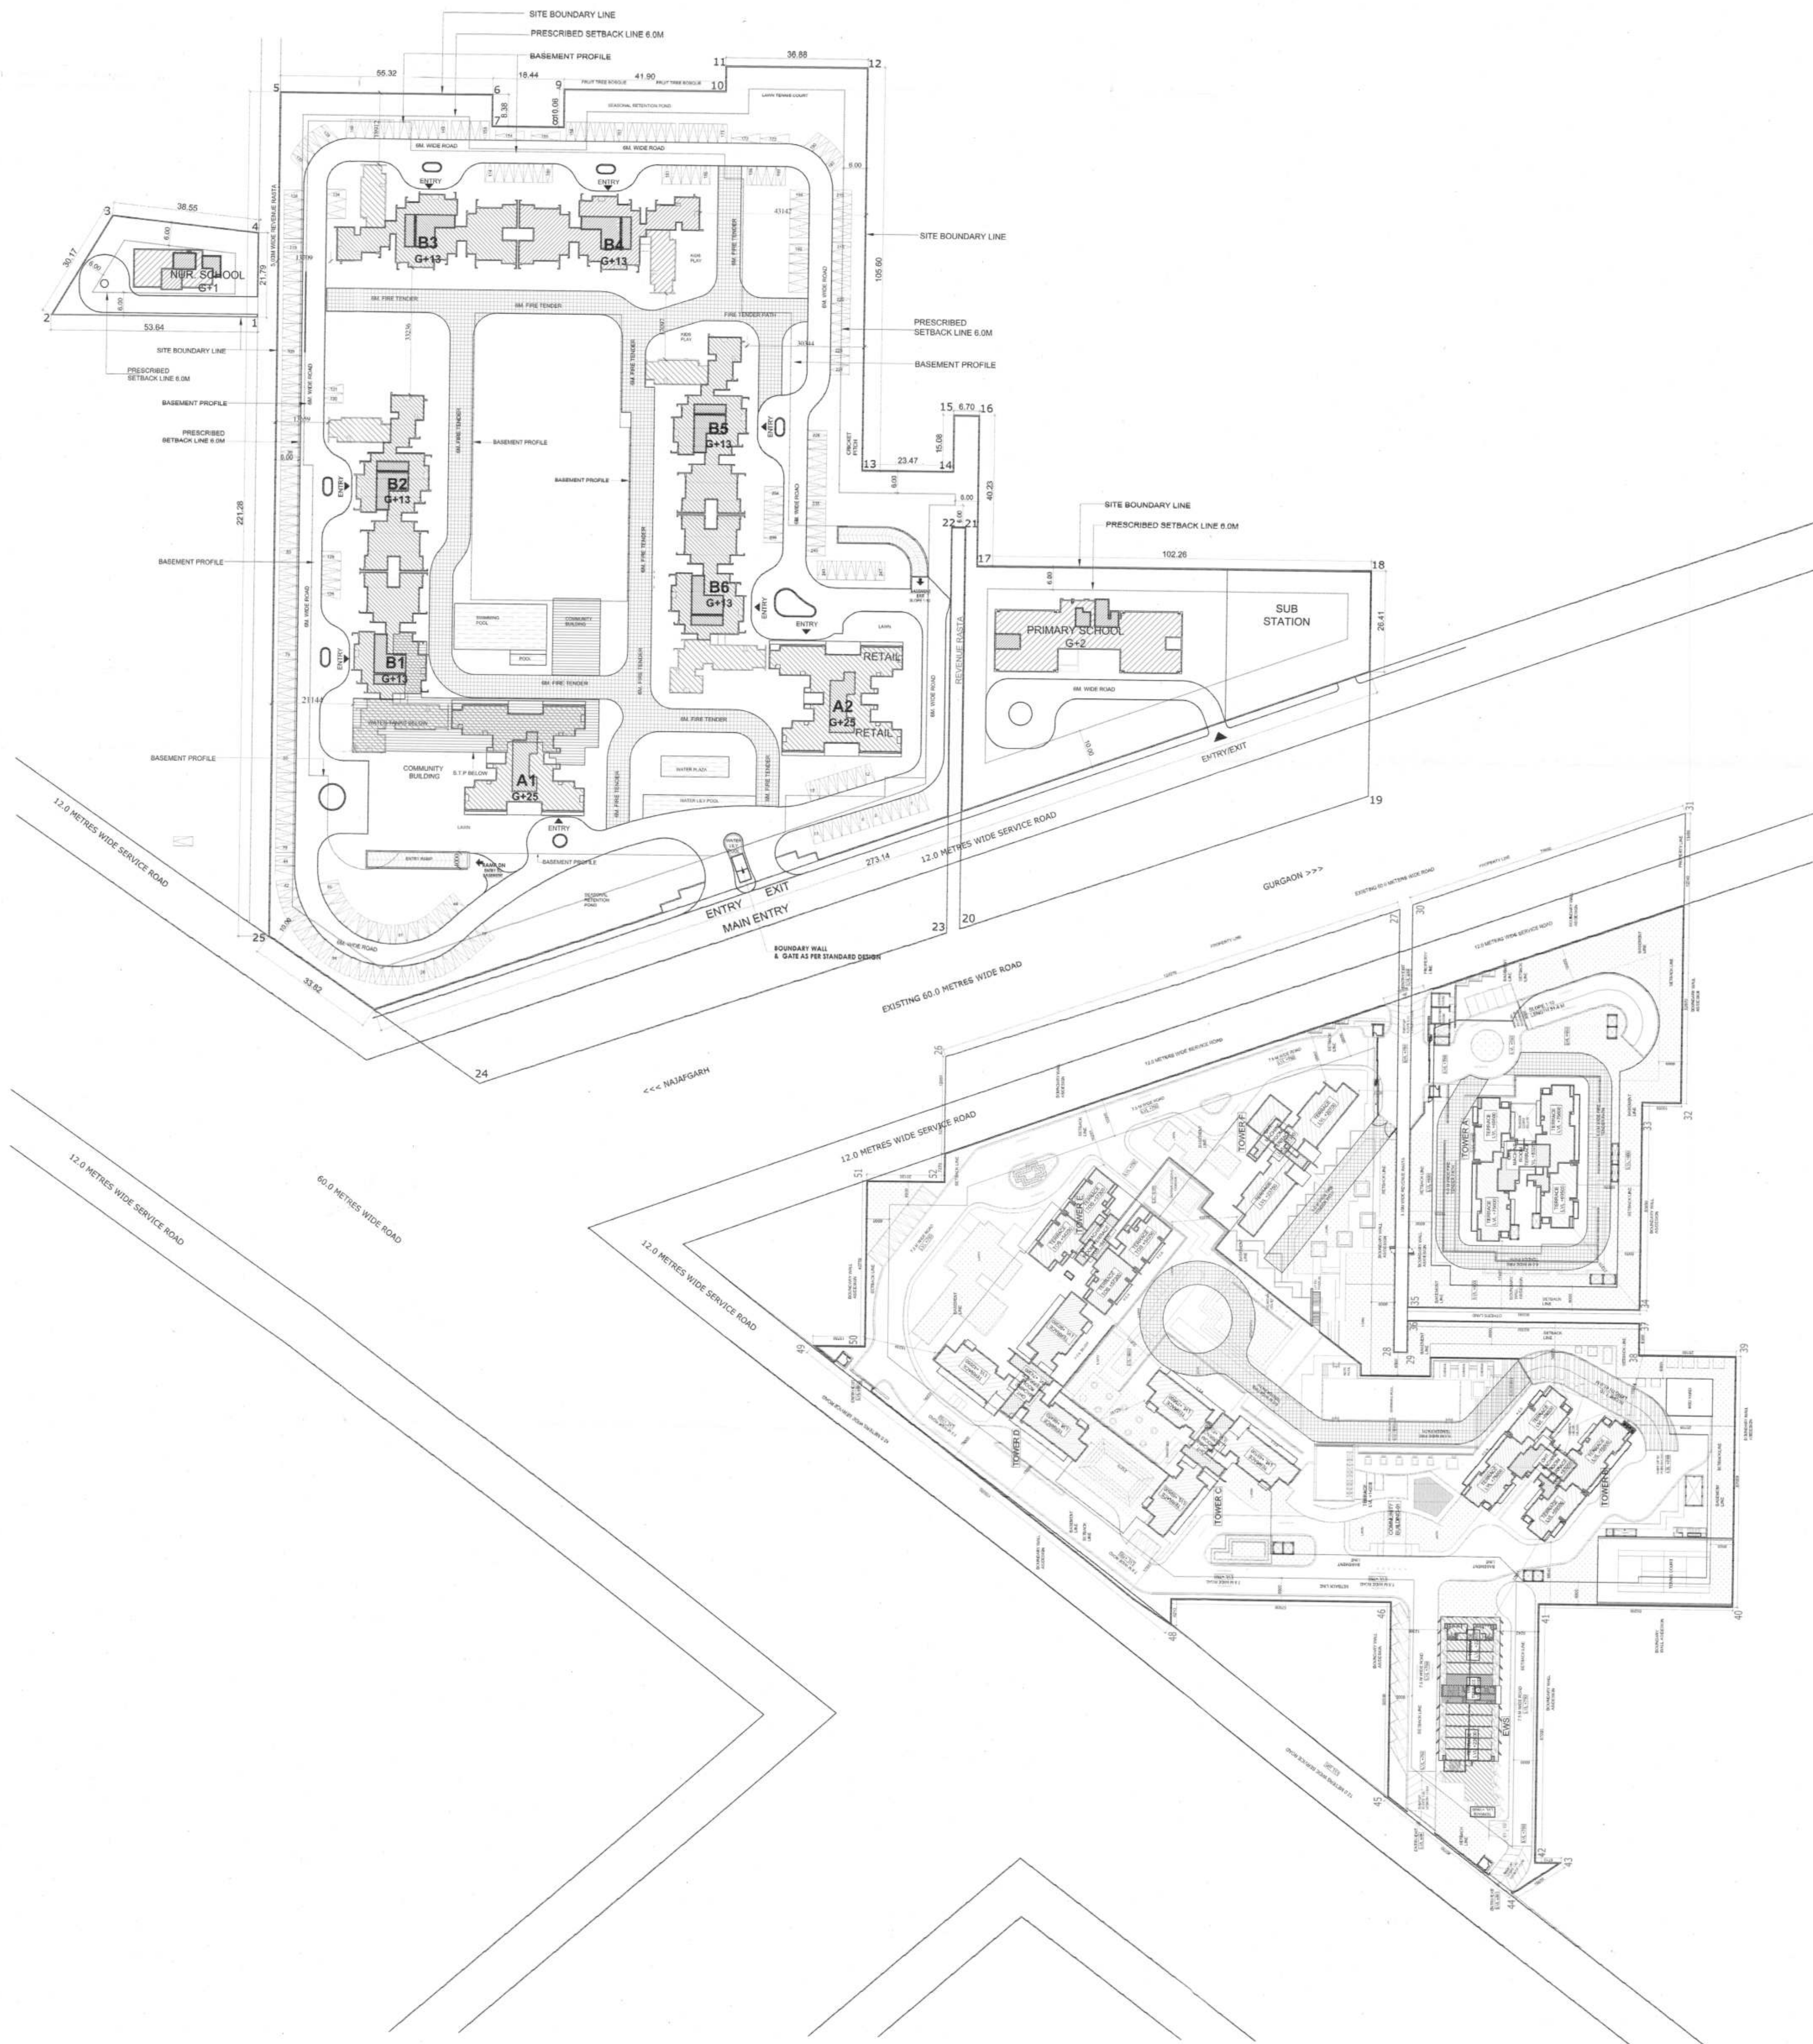

Architect's Signature
Munish K. Bhatia, Architect
Council of Architecture
Registration No. CA/07/10208

Owner's Signature

Stamp of the Project Consultant
Project Consultant
101A, Sector 27, Indira Nagar, New Delhi-110025
T: 011-2945601, 2459427
E: pardeepconsultant@gmail.com

Architect
Atrop Associates P. Ltd.
P-305, Sector-32, Gurgaon-122001
Ph: +91-124-455800, Fax: +91-124-455800
Website: www.aatrop.com

Structure
BPC Technical Project Consultants Pvt. Ltd.
B-74, Sector 27, Indira Nagar, New Delhi-110025
T: +91-124-455800, F: +91-124-455800

MEP
Pardeep Consultants
C-102, Sector 27, Indira Nagar, New Delhi-110025
T: 011-2945601, 2459427
E: pardeepconsultant@gmail.com

Stamp of the Project Consultant
Project Consultant
101A, Sector 27, Indira Nagar, New Delhi-110025
T: 011-2945601, 2459427
E: pardeepconsultant@gmail.com

Stamp of the Project Consultant
Project Consultant
101A, Sector 27, Indira Nagar, New Delhi-110025
T: 011-2945601, 2459427
E: pardeepconsultant@gmail.com

Stamp of the Project Consultant
Project Consultant
101A, Sector 27, Indira Nagar, New Delhi-110025
T: 011-2945601, 2459427
E: pardeepconsultant@gmail.com

Stamp of the Project Consultant
Project Consultant
101A, Sector 27, Indira Nagar, New Delhi-110025
T: 011-2945601, 2459427
E: pardeepconsultant@gmail.com

Stamp of the Project Consultant
Project Consultant
101A, Sector 27, Indira Nagar, New Delhi-110025
T: 011-2945601, 2459427
E: pardeepconsultant@gmail.com

Stamp of the Project Consultant
Project Consultant
101A, Sector 27, Indira Nagar, New Delhi-110025
T: 011-2945601, 2459427
E: pardeepconsultant@gmail.com

Stamp of the Project Consultant
Project Consultant
101A, Sector 27, Indira Nagar, New Delhi-110025
T: 011-2945601, 2459427
E: pardeepconsultant@gmail.com

Stamp of the Project Consultant
Project Consultant
101A, Sector 27, Indira Nagar, New Delhi-110025
T: 011-2945601, 2459427
E: pardeepconsultant@gmail.com

Stamp of the Project Consultant
Project Consultant
101A, Sector 27, Indira Nagar, New Delhi-110025
T: 011-2945601, 2459427
E: pardeepconsultant@gmail.com

Stamp of the Project Consultant
Project Consultant
101A, Sector 27, Indira Nagar, New Delhi-110025
T: 011-2945601, 2459427
E: pardeepconsultant@gmail.com

Stamp of the Project Consultant
Project Consultant
101A, Sector 27, Indira Nagar, New Delhi-110025
T: 011-2945601, 2459427
E: pardeepconsultant@gmail.com

Stamp of the Project Consultant
Project Consultant
101A, Sector 27, Indira Nagar, New Delhi-110025
T: 011-2945601, 2459427
E: pardeepconsultant@gmail.com

Drawing No.

Drawing Title

SITE PLAN (OVERALL) MP-001

Date

30.09.2015

Scale

1:750