

मानचित्र की स्वीकृति
कार्यालय के पास संख्या 3564 एफ/सेक्टर/प्लॉट/1.
संख्या/दिनांक 28/05/2008 द्वारा स्वीकृत
किये जाते हैं।

मुख्य (कार्यालय/वायलर निरीक्षक)
(उत्तराखण्ड)

PLAN NO. JS/170/162/07

PLAN OF THE FACTORY MAP
M/S. U.S. METAL PRODUCTS
AT PLOT NO. 78, SECTOR-5,
I.I.E., SIDCUL, HARIDWAR,
(UTTARAKHAND)

POWER DETAIL—

ELECTRIC POWER — 74.35 HP (INSTALLED)

GENERATOR POWER — 134.0 HP (STAND BY)

SCALE —

GENERAL SCALE — 1" = 10'-0"

 
SITE PLAN SCALE — 1" = 12'-0"

DRAWING SHEET

1/1

COLOUR REFERENCES—

1. FACTORY PREMISES SHOWN AS
2. EXISTING WORKS SHOWN AS



ELECTRIC POWER ——— T435HP (INSTALLED)
GENERATOR POWER ——— 1340HP (STAND BY)

SCALE —

GENERAL SCALE ——— 1" ——— 10.0'

SITE PLAN SCALE ——— 1" ——— 12.0'

DRAWING SHEET

1/1

COLOUR REFERENCES —

- | | | |
|-----|---------------------------------|--|
| 1. | FACTORY PERMISES SHOWN AS |  |
| 2. | EXISTING WORKS SHOWN AS |  |
| 3. | DRINKING WATER SHOWN AS |  |
| 4. | DRAINAGE SHOWN AS |  |
| 5. | UNDER GROUND WATER RESERVE TANK |  |
| 6. | FIRE EXTINGUISHERS SHOWN AS |  |
| 7. | FIRE HYDRANT SHOWN AS |  |
| 8. | FIRE STATION ——— | 12.0 KM |
| 9. | POLICE STATION ——— | 10.0 KM |
| 10. | EDUCATION POINT ——— | 5.0 KM |
| 11. | HOSPITAL POINT ——— | 4.0 KM |
| 12. | POPULATED AREA ——— | 5.0 KM |
| 13. | PETROL PUMP ——— | 7.0 KM |

SIGN OF MANAGER





SIGN OF OCCUPIER




ARCHITECT PLANNERS —

SANJAY MANI SHARMA
JAI ASSOCIATES
NEW SHARDA NAGAR
SAHARANPUR
MOB. 9412874075

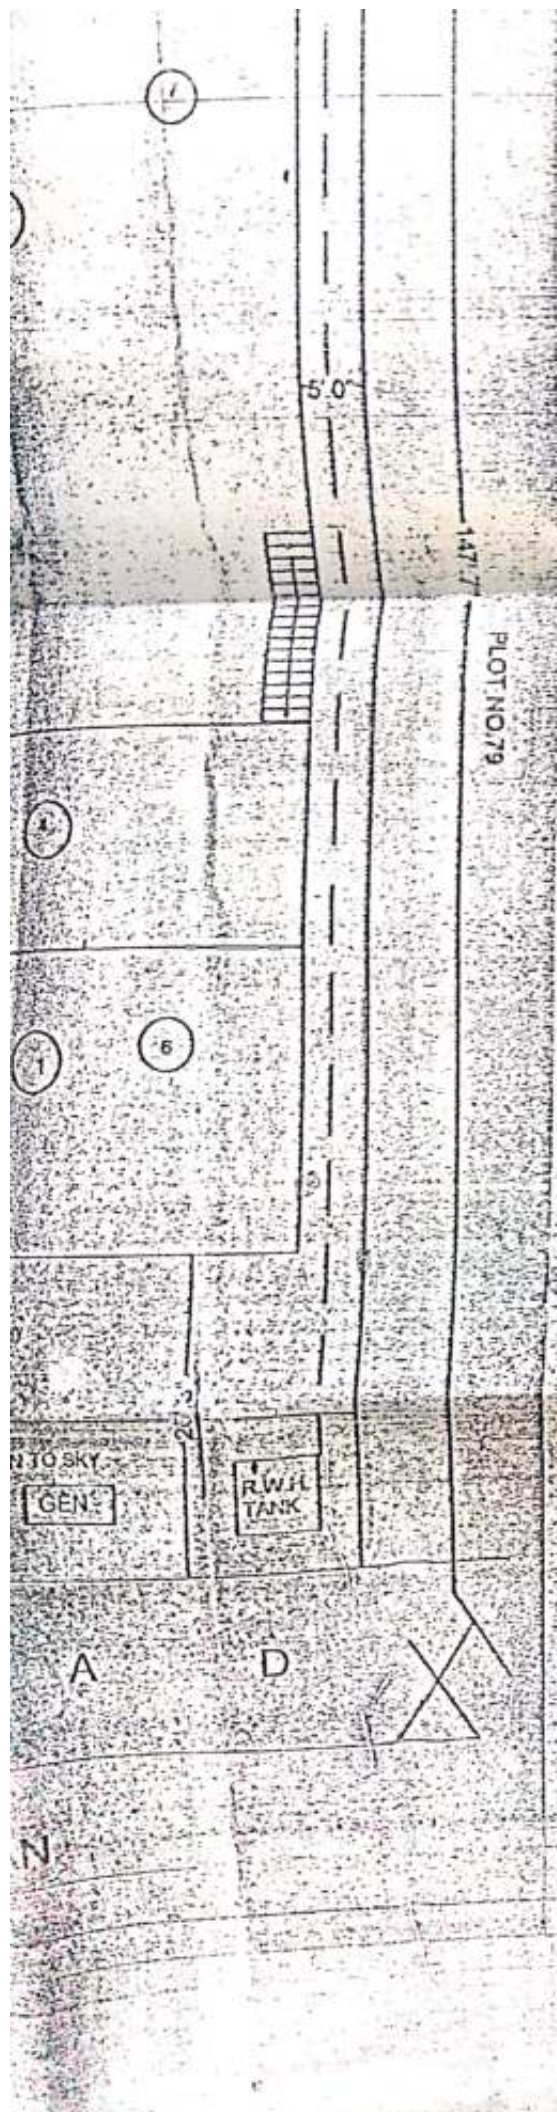

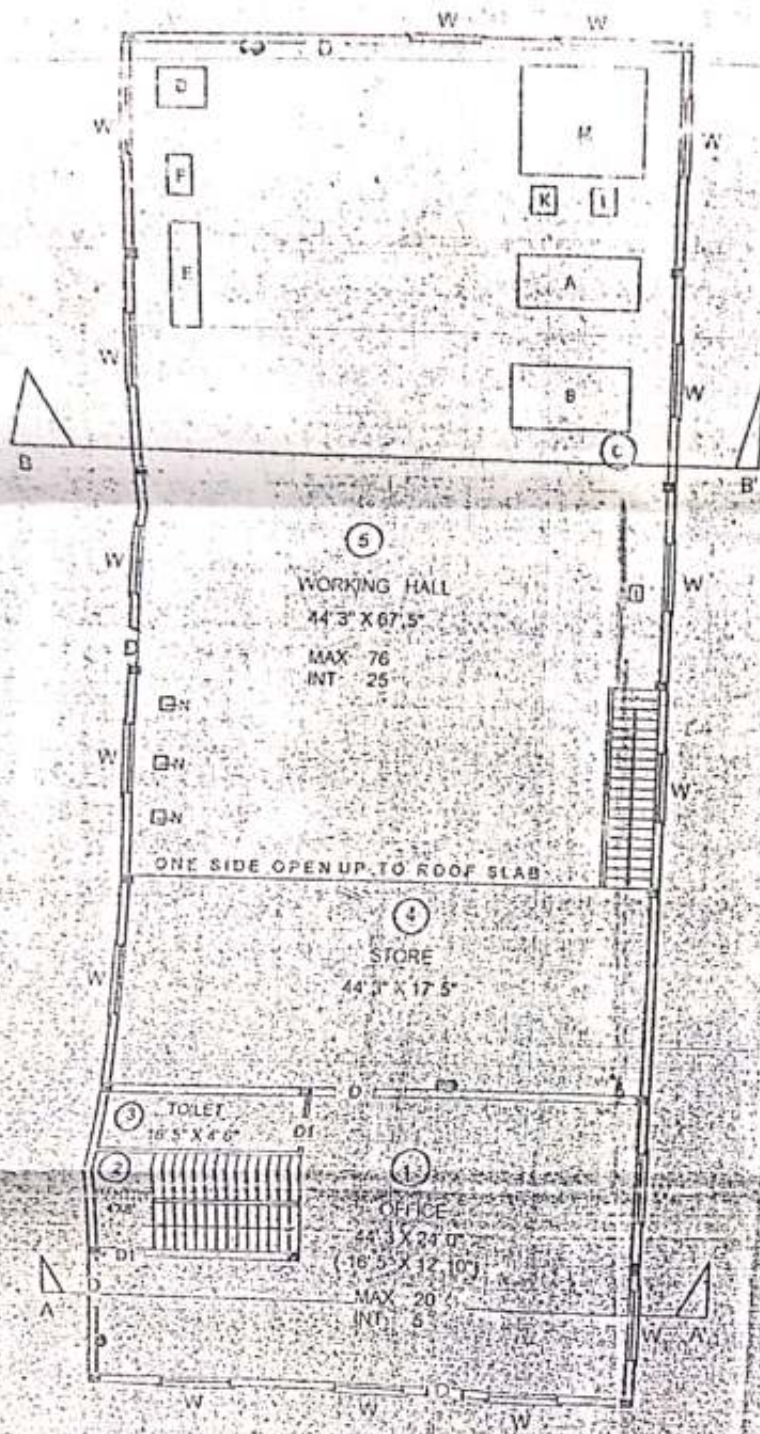

GROUND FLOOR PLAN

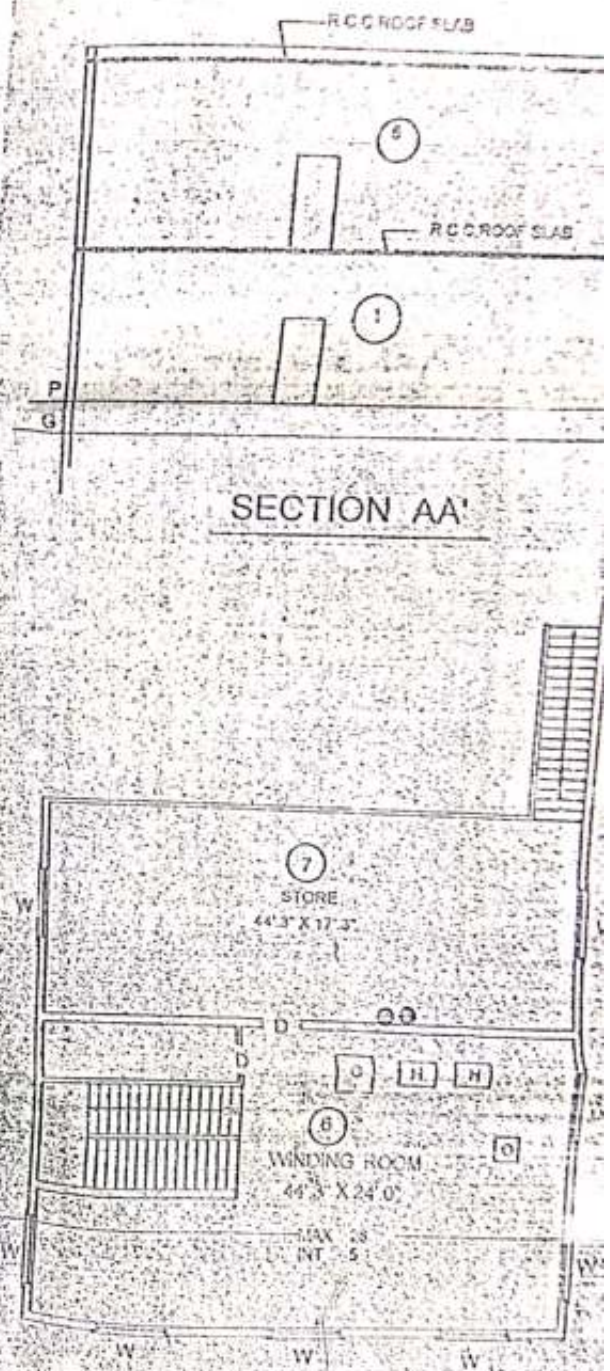

FIRST FLOOR PLAN

SECTION AA'

SECTION BB

S.NO	ITEM	QTY	UNIT	AMOUNT	REMARKS
1	CONCRETE	100	CUM	100	
2	REINFORCEMENT	100	KG	100	
3	BRICKS	100	NO	100	
4	CEMENT	100	KG	100	
5	SAND	100	CUM	100	
6	GRAVEL	100	CUM	100	
7	LABOR	100	HR	100	
8	WATER	100	LIT	100	
9	WATER SUPPLY	100	HR	100	
10	WATER SUPPLY	100	HR	100	
11	WATER SUPPLY	100	HR	100	
12	WATER SUPPLY	100	HR	100	
13	WATER SUPPLY	100	HR	100	
14	WATER SUPPLY	100	HR	100	
15	WATER SUPPLY	100	HR	100	
16	WATER SUPPLY	100	HR	100	
17	WATER SUPPLY	100	HR	100	
18	WATER SUPPLY	100	HR	100	
19	WATER SUPPLY	100	HR	100	
20	WATER SUPPLY	100	HR	100	

ITEM	QTY	UNIT	AMOUNT	REMARKS
1	100	CUM	100	
2	100	KG	100	
3	100	NO	100	
4	100	KG	100	
5	100	CUM	100	
6	100	CUM	100	
7	100	HR	100	
8	100	LIT	100	
9	100	HR	100	
10	100	HR	100	
11	100	HR	100	
12	100	HR	100	
13	100	HR	100	
14	100	HR	100	
15	100	HR	100	
16	100	HR	100	
17	100	HR	100	
18	100	HR	100	
19	100	HR	100	
20	100	HR	100	

SECTION AA

BOUNDARY WALL HEIGHT 7' 0"

PLOT NO. 77

PASSAGE

REINFORCED 574