


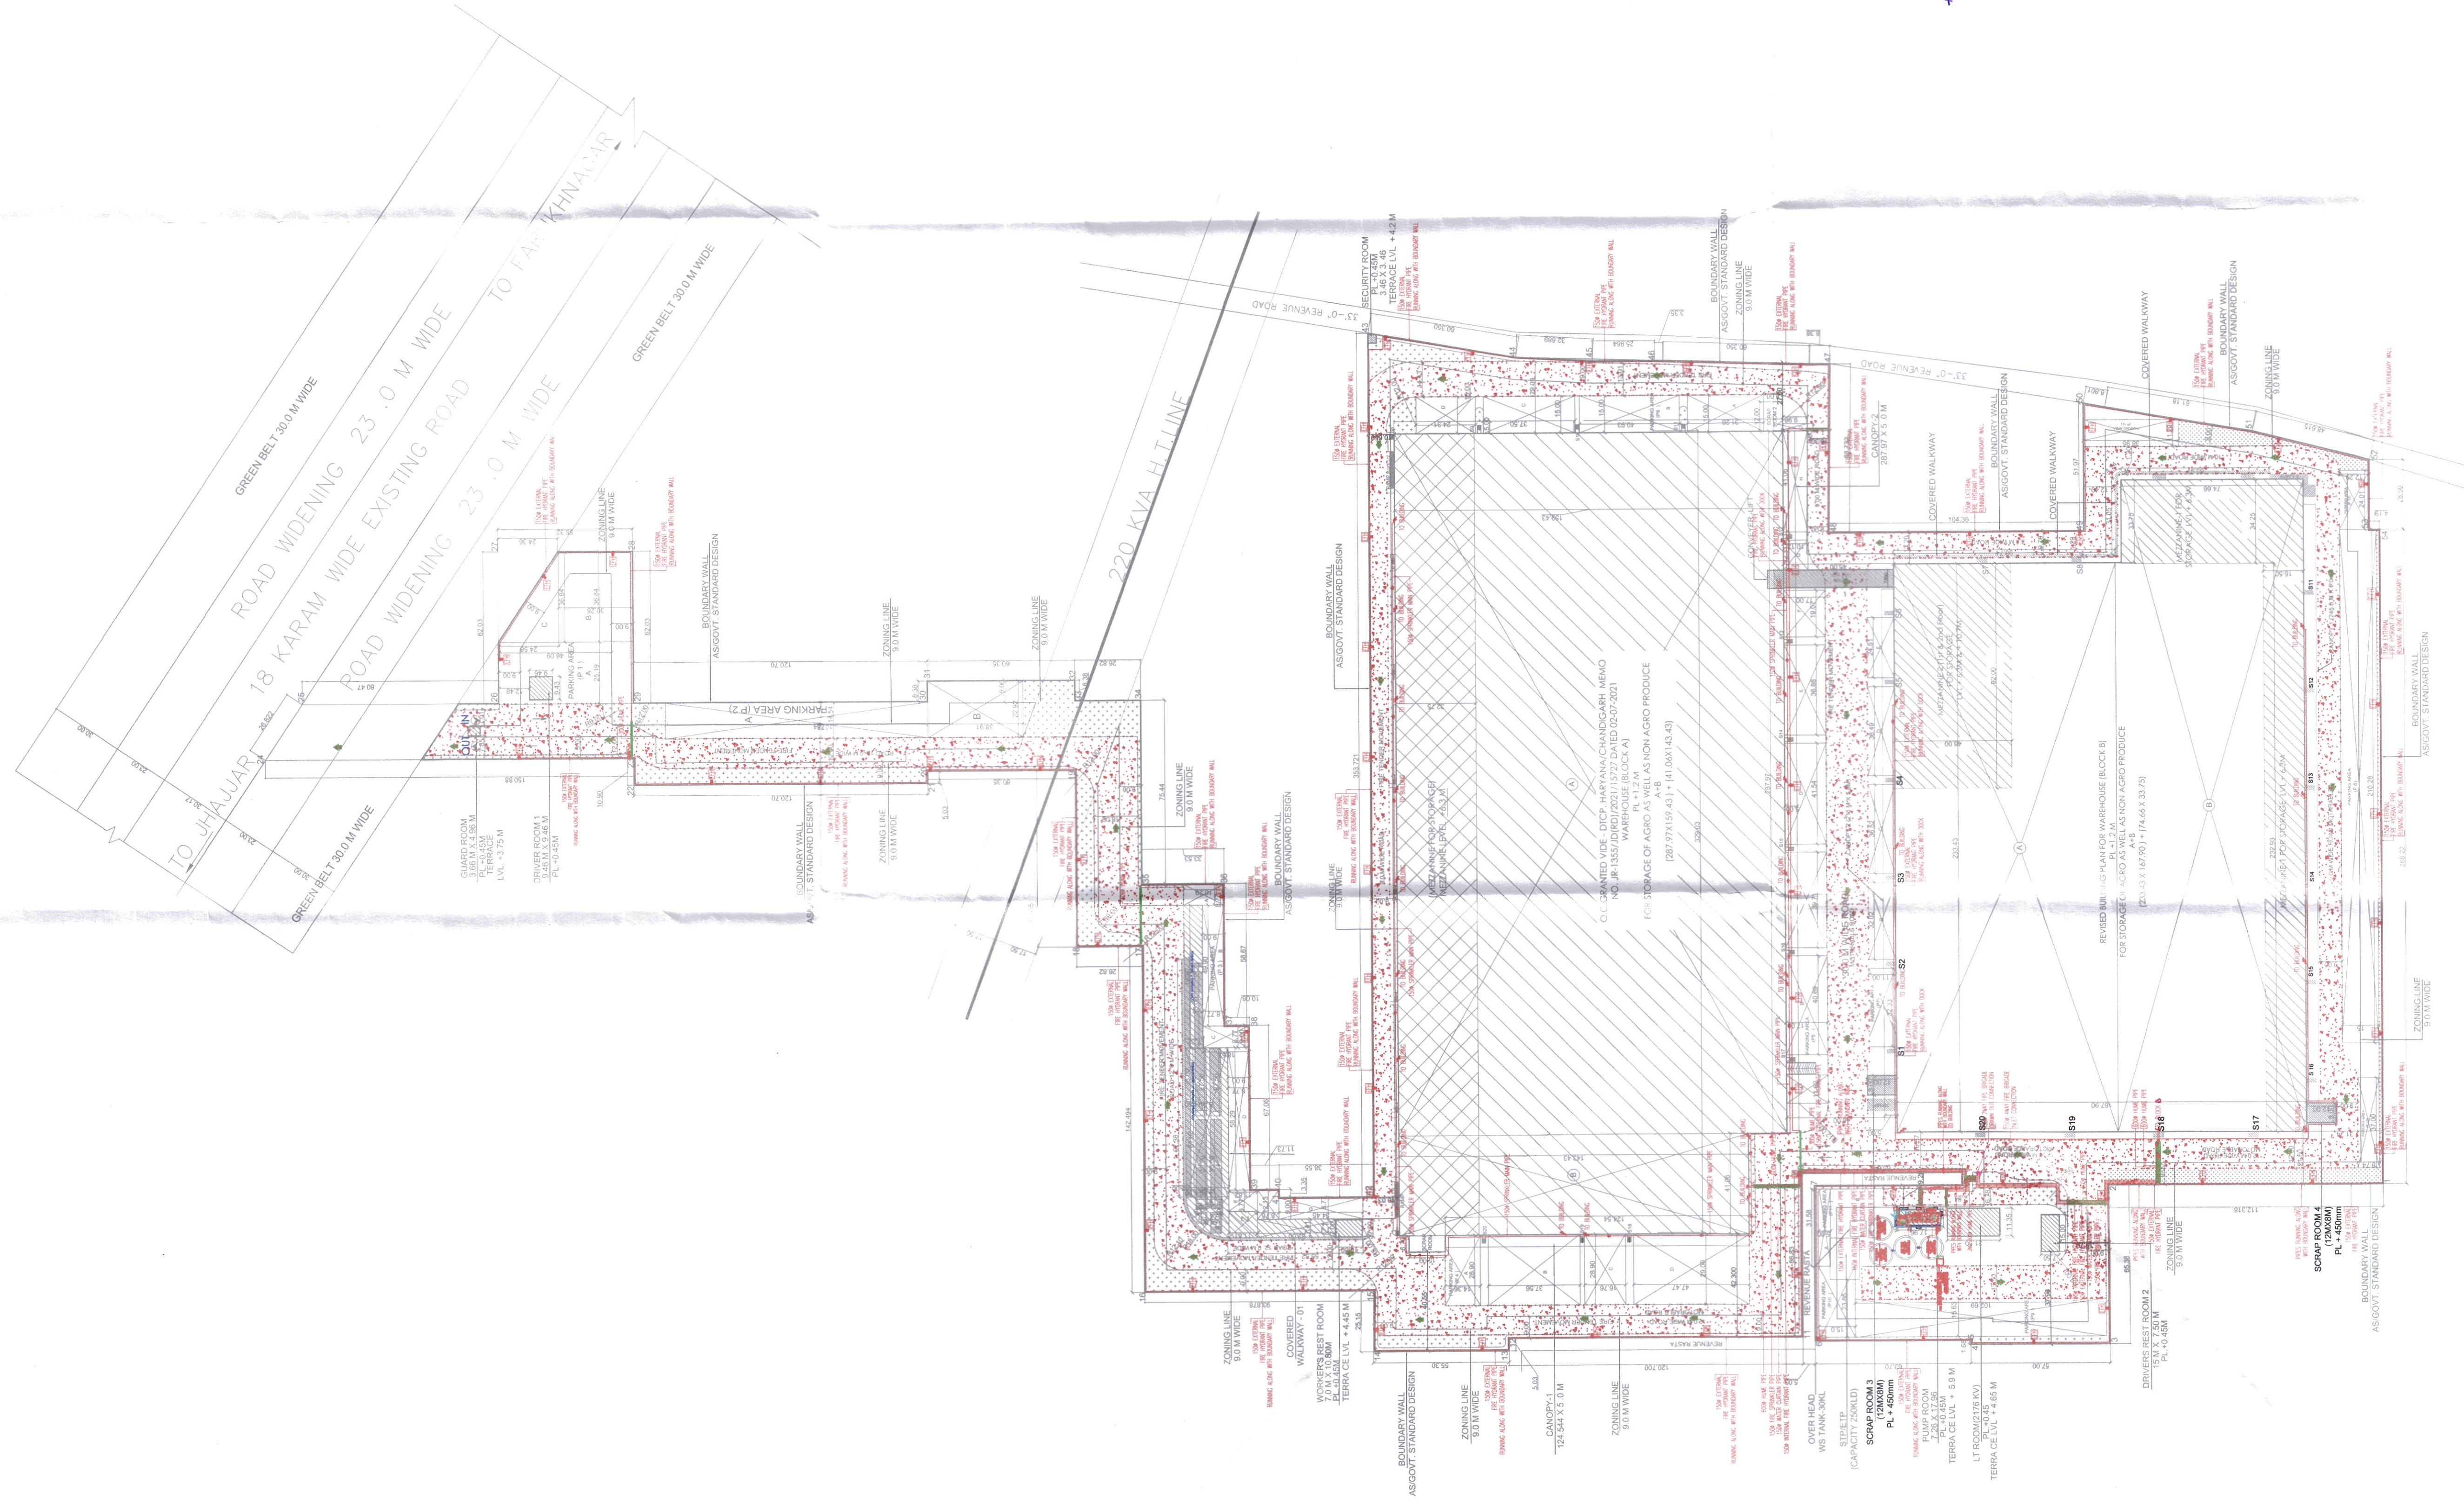

STP (HQ) Member Secretary, BPAC
STP (HQ) Member Secretary, BPAC
DOT (HQ) Member Secretary, BPAC
DOT (HQ) Member Secretary, BPAC

FIRE-FIGHTING LEGEND:-	
	EXTERNAL FIRE HYDRANT PIPE
	INTERNAL FIRE HYDRANT PIPE
	SPRINKLER MAIN PIPE
	EXTERNAL FIRE HOSE
	HUME PIPE
	4 WAY FIRE BRIGADE CONNECTION
	2 WAY FIRE BRIGADE CONNECTION
	INSTALLATION CONTROL VALVE
	WATER CUPTAN MAIN PIPE
	TRAFFIC CIRCULATION

OWNER'S SIGN


RANJEET YADAV
ARCHITECT
CA/200536
Date: 21-08-2023

PROJECT SIGN


RANJEET YADAV
ARCHITECT
CA/200536
Date: 21-08-2023

PROJECT TITLE

SITE PLAN

SHEET TITLE

FIRE FIGHTING LAYOUT

DRAWING NO.

SD - 09

SCALE

DATE

21-08-2023

THE BUILDING PLAN FOR WAREHOUSE FOR STORAGE OF AGRO AS WELL AS NON-AGRO PRODUCE FOR AN AREA MEASURING 17026.63 SQM IN REVENUE ESTATE OF VILLAGE YAKUBPUR, TERAIL BADI DIST. JHAJJAR FOR P.J. WATERSSUN PVT. LTD.

NOTES:
1. ALL DIMENSIONS ARE IN METERS.
2. ALL DIMENSIONS ARE TO FACE UNLESS OTHERWISE SPECIFIED.
3. ALL DIMENSIONS ARE TO FACE UNLESS OTHERWISE SPECIFIED.
4. ALL DIMENSIONS ARE TO FACE UNLESS OTHERWISE SPECIFIED.