


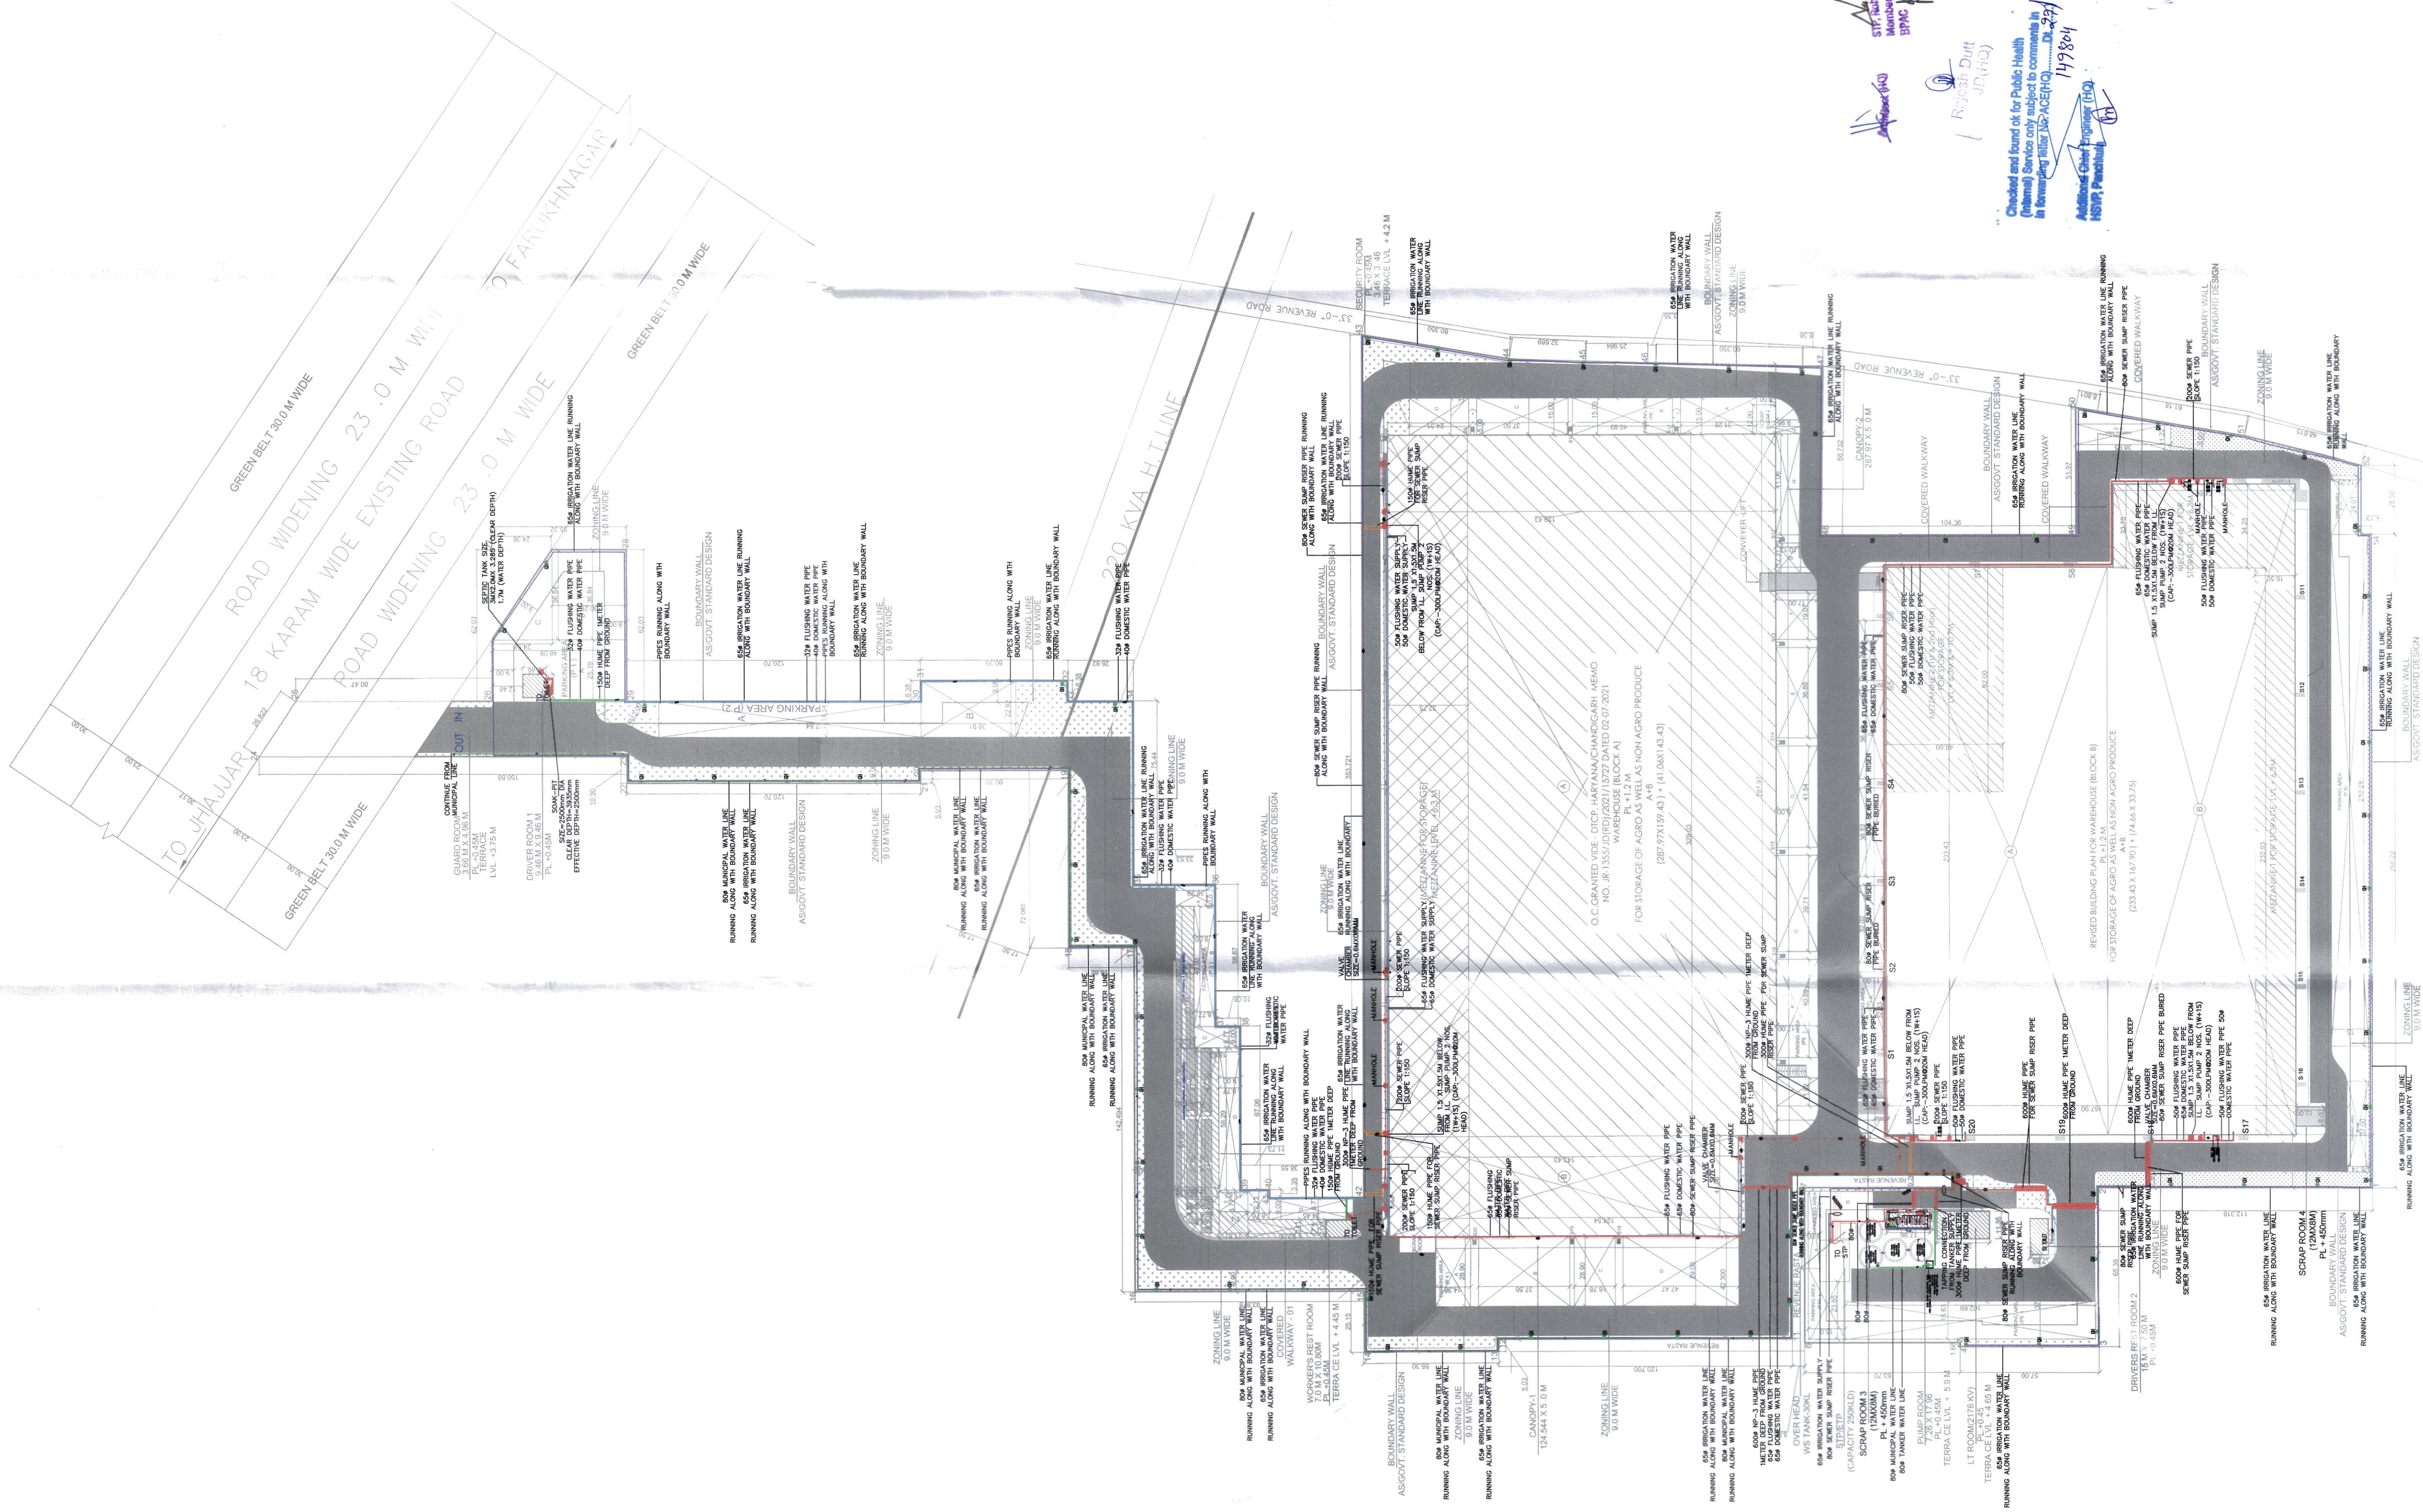

LEGENDS:-

CWS	COLD WATER SUPPLY PIPE
FWS	FLUSHING WATER SUPPLY PIPE
MWS	MUNICIPAL WATER SUPPLY PIPE
TWS	TANKER WATER SUPPLY PIPE
IRS	IRRIGATION SUPPLY PIPE
FD	FLOW DIRECTION
IV	ISOLATION VALVE
300mm IP-3 HOME PIPE	
GH	GARDEN HYDRANT
VC	VALVE CHAMBER, (SIZE-600X600MM)

PLUMBING LEGEND:-

SYMBOL	DESCRIPTION
—	SEWER PIPE
—	SEWAGE SUMP RISER PIPE
—	SEWER MANHOLE

OWNER'S SIGN:

ARCHITECT'S SIGN:

ARCHITECT: **RANJEET YADAV**
ARCHITECT
CA2005/8179

SHEET TITLE: **SITE PLAN**
SEWER & WATER SUPPLY LAYOUT

DRAWING NO: **SD-06**

DATE: **21-05-2021**

SCALE: **1:100**

NOTES:-
1. ALL OFFICE WORK IS TO BE DONE IN THE OFFICE.
2. ALL WORK IS TO BE DONE IN THE OFFICE.
3. ALL WORK IS TO BE DONE IN THE OFFICE.
4. ALL WORK IS TO BE DONE IN THE OFFICE.

NOTE: THE FIRM WILL BE USED
HYDRO PNEUMATIC SYSTEM.

FOR VILLAGE YAKUBPUR, TEHSIL BADI, DIST. JHAJHAR
AREA MEASURING 17028.63 SQM. IN REVENUE ESTATE
OF VILLAGE YAKUBPUR, TEHSIL BADI, DIST. JHAJHAR
FOR P.J. WAREHOUSING PVT. LTD.