


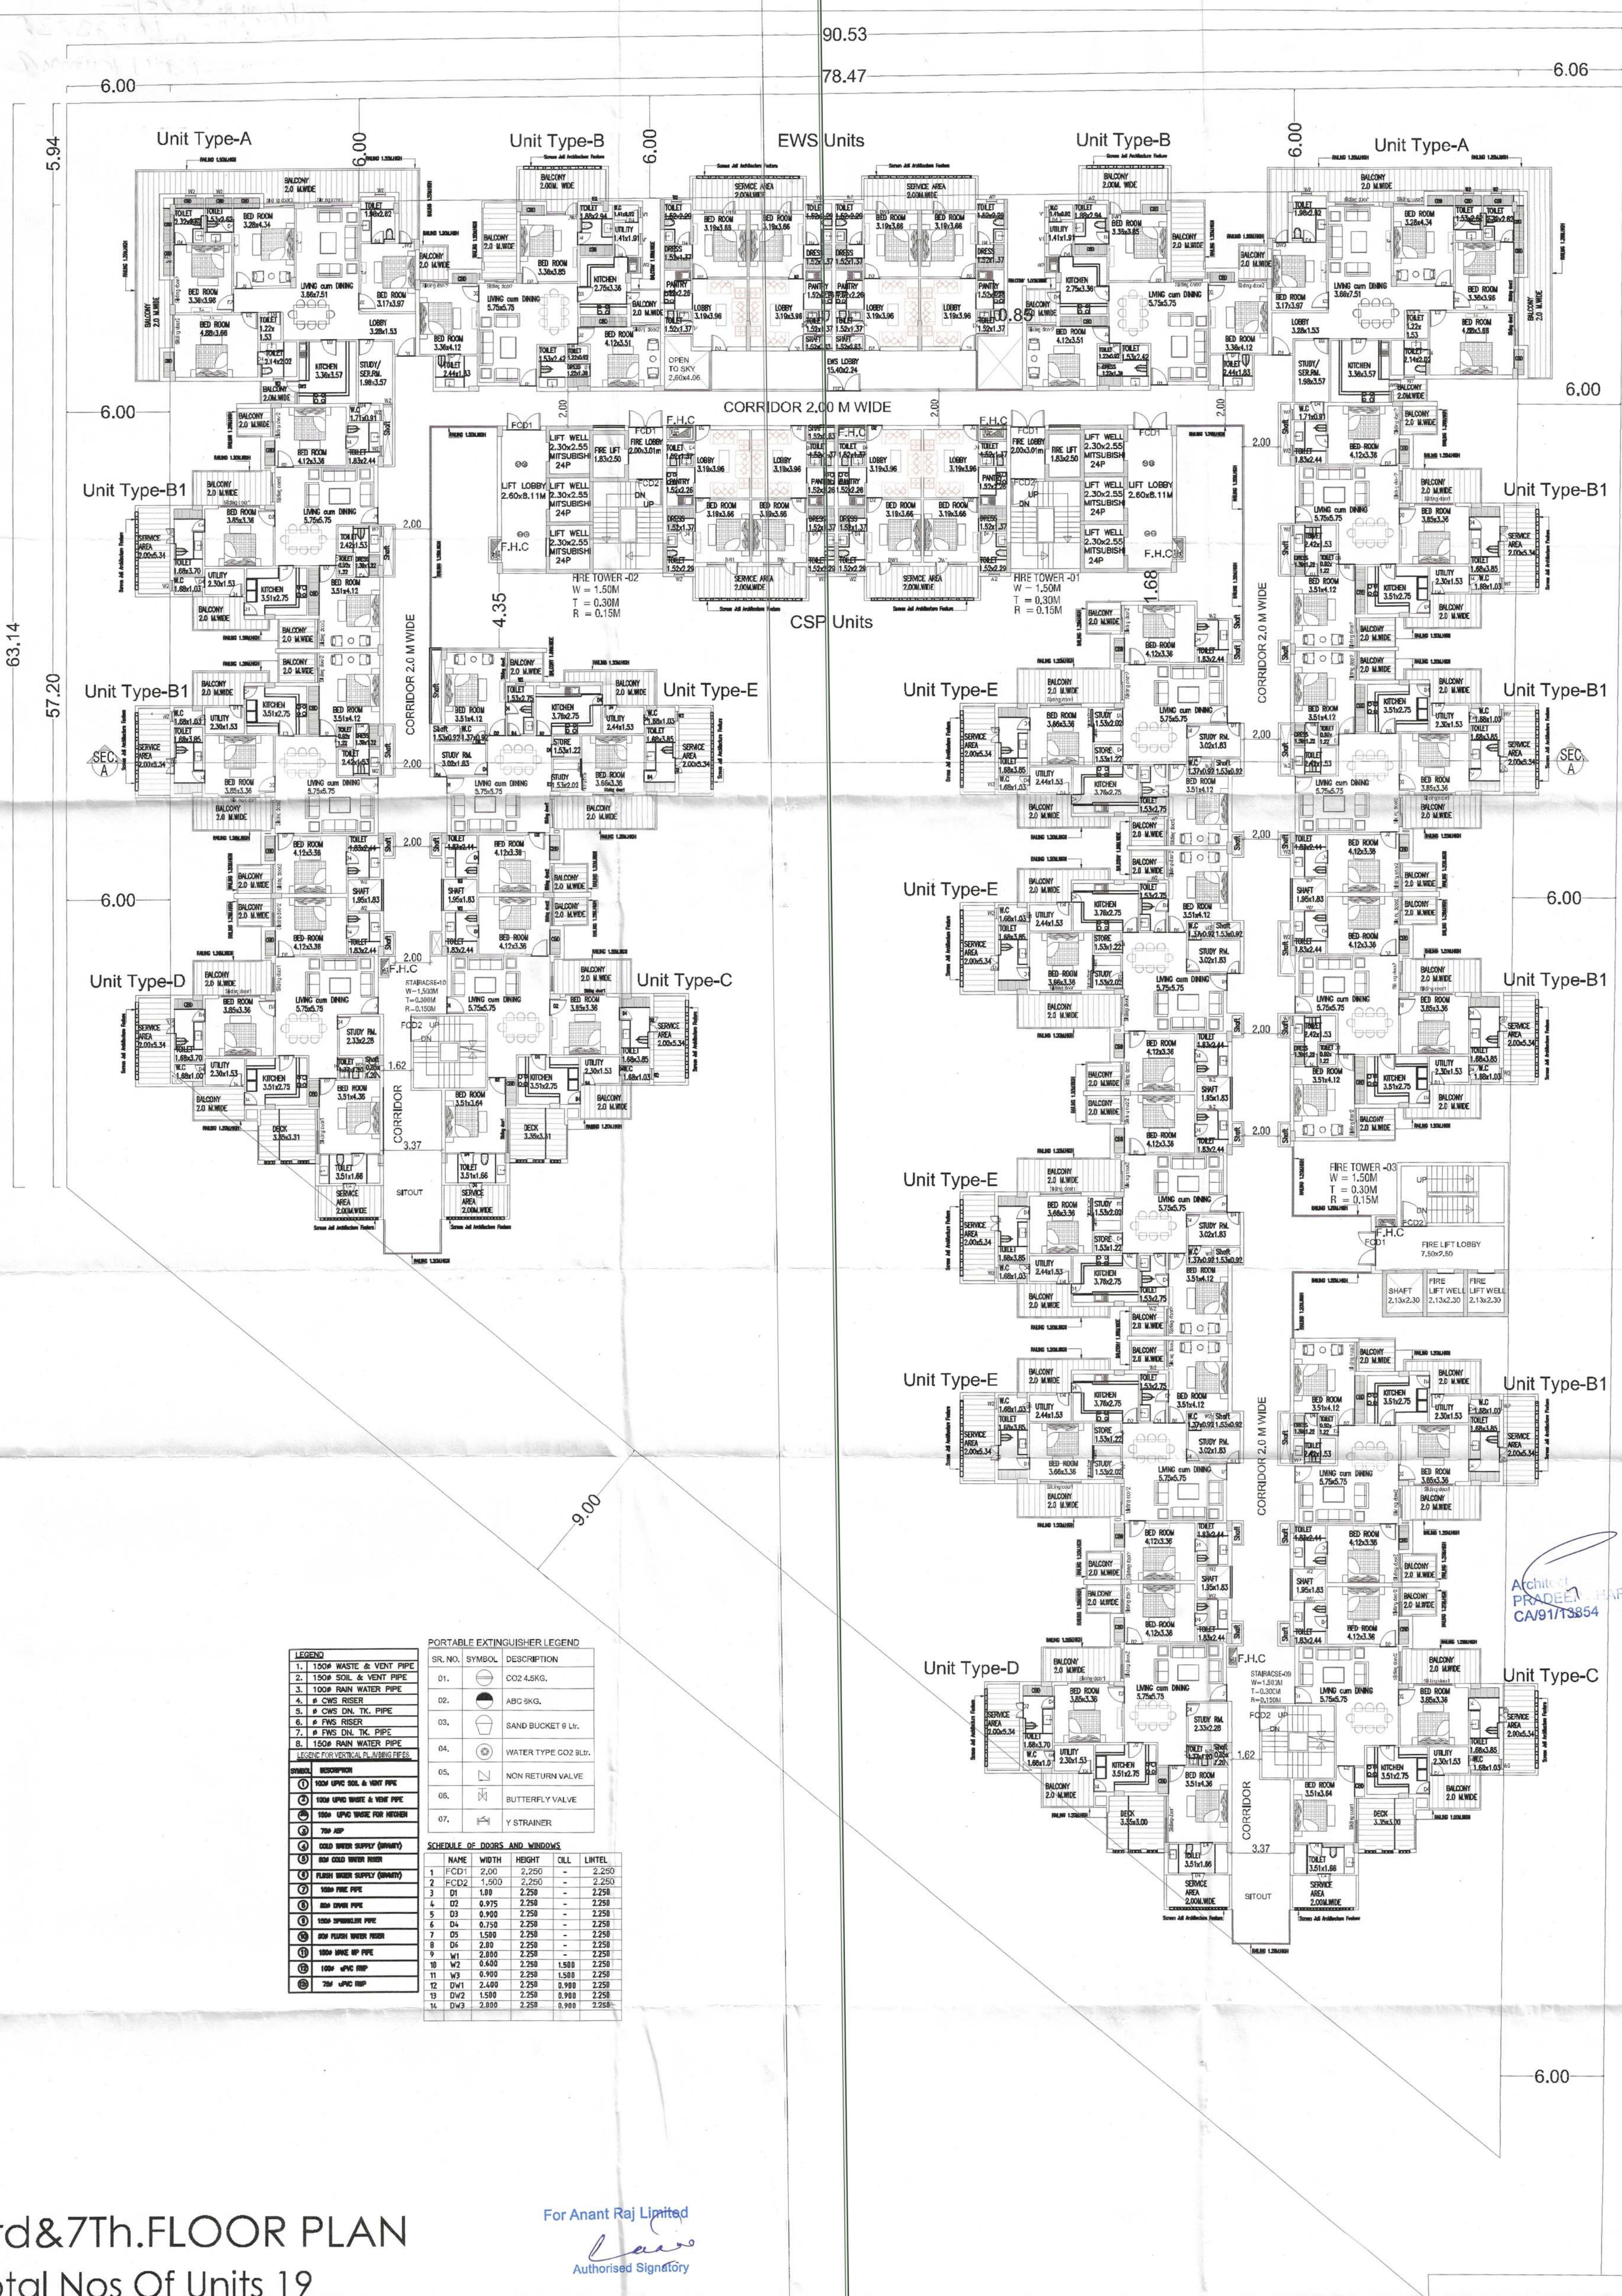

| LEGEND                       |                             |
|------------------------------|-----------------------------|
| 1.                           | 1500 WASTE & VENT PIPE      |
| 2.                           | 1500 SOIL & VENT PIPE       |
| 3.                           | 1500 RAIN WATER PIPE        |
| 4.                           | 1500 CWS RISER              |
| 5.                           | 1500 CWS DN. TK. PIPE       |
| 6.                           | 1500 FMS RISER              |
| 7.                           | 1500 FMS DN. TK. PIPE       |
| 8.                           | 1500 RAIN WATER PIPE        |
| LEGEND FOR VERTICAL PLUMBING |                             |
| 1.                           | 1500 UPVC SOIL & VENT PIPE  |
| 2.                           | 1500 UPVC WASTE & VENT PIPE |
| 3.                           | 1500 UPVC WASTE FOR KITCHEN |
| 4.                           | 750 RSP                     |
| 5.                           | COOD WATER SUPPLY (DRINKY)  |
| 6.                           | RSP COOD WATER RISER        |
| 7.                           | FLUSH WATER SUPPLY (DRINKY) |
| 8.                           | 1500 FMS PIPE               |
| 9.                           | RSP FMS PIPE                |
| 10.                          | 1500 SPMERLITE PIPE         |
| 11.                          | COOD FLUSH WATER RISER      |
| 12.                          | 1500 WASTE UP PIPE          |
| 13.                          | 1500 WASTE DOW PIPE         |
| 14.                          | 750 UPVC RSP                |

| PORTABLE EXTINGUISHER LEGEND |                     |
|------------------------------|---------------------|
| 01.                          | CO2 4.5KG.          |
| 02.                          | ABC 9KG.            |
| 03.                          | SAND BUCKET 9 Lt.   |
| 04.                          | WATER TYPE CO2 SLT. |
| 05.                          | NON RETURN VALVE    |
| 06.                          | BUTTERFLY VALVE     |
| 07.                          | Y STRAINER          |

| SCHEDULE OF DOORS AND WINDOWS |       |        |       |
|-------------------------------|-------|--------|-------|
| NAME                          | WIDTH | HEIGHT | LITEL |
| 1. FCD1                       | 2.00  | 2.250  | -     |
| 2. FCD2                       | 1.500 | 2.250  | -     |
| 3. D1                         | 1.80  | 2.250  | -     |
| 4. D2                         | 0.975 | 2.250  | -     |
| 5. D3                         | 0.900 | 2.250  | -     |
| 6. D4                         | 0.750 | 2.250  | -     |
| 7. D5                         | 1.500 | 2.250  | -     |
| 8. D6                         | 2.80  | 2.250  | -     |
| 9. W1                         | 2.800 | 2.250  | -     |
| 10. W2                        | 0.600 | 2.250  | 1.500 |
| 11. W3                        | 0.900 | 2.250  | 1.500 |
| 12. D41                       | 2.400 | 2.250  | 0.900 |
| 13. D42                       | 1.500 | 2.250  | 0.900 |
| 14. D43                       | 2.800 | 2.250  | 0.900 |

3rd&7Th.FLOOR PLAN  
Total Nos Of Units 19

For Anant Raj Limited  
Authorised Signatory

PROJECT :-  
PROP. BUILDING PLAN GROUP HOUSING AT BEARING KHASRA  
NO 8/26/2 AREA MEASURING 2.947 ACRES AT  
VILLAGE KAPASHERA TEHSIL VASANT VIHAR NEW DELHI  
BELONGING TO- M/s Anant Raj Limited  
Through Its Authorized signatory Sh. Ajay Pathania

Architects  
PRADEEP SHARMA  
ARCHITECTS ASSOCIATE  
64 POORVI MARG, VASANT VIHAR NEW DELHI  
CONSULTANTS  
NNC DESIGN INTERNATIONAL  
CONSULTING STRUCTURAL ENGINEERS  
G-70, 2nd FLOOR, JASWANT PLAZA, NEAR KALINDI KUNJ  
MAIN SARITA VIHAR ROAD, OKHLA, NEW DELHI-110025  
PHONE NO.: +91-11-26940734/5/6/7/8 FAX: 26940738  
E-Mail : nnc\_consultants@hotmail.com  
Web : www.nncdesigninternational.com

|           |       |               |                     |       |            |       |  |
|-----------|-------|---------------|---------------------|-------|------------|-------|--|
| Drawn     | MANOJ | Date          | 26-04-2021          | Scale | 26-04-2021 | NORTH |  |
| Revisions |       |               |                     |       |            |       |  |
| SHEET NO. | 1.7   | Drawing Title | 3rd& 7th.FLOOR PLAN |       |            |       |  |

Attested Copy of Online SBP  
ID No. 1003582 DT 06.09.21  
D/MAN  
Bldg (HQ)  
SUMC