


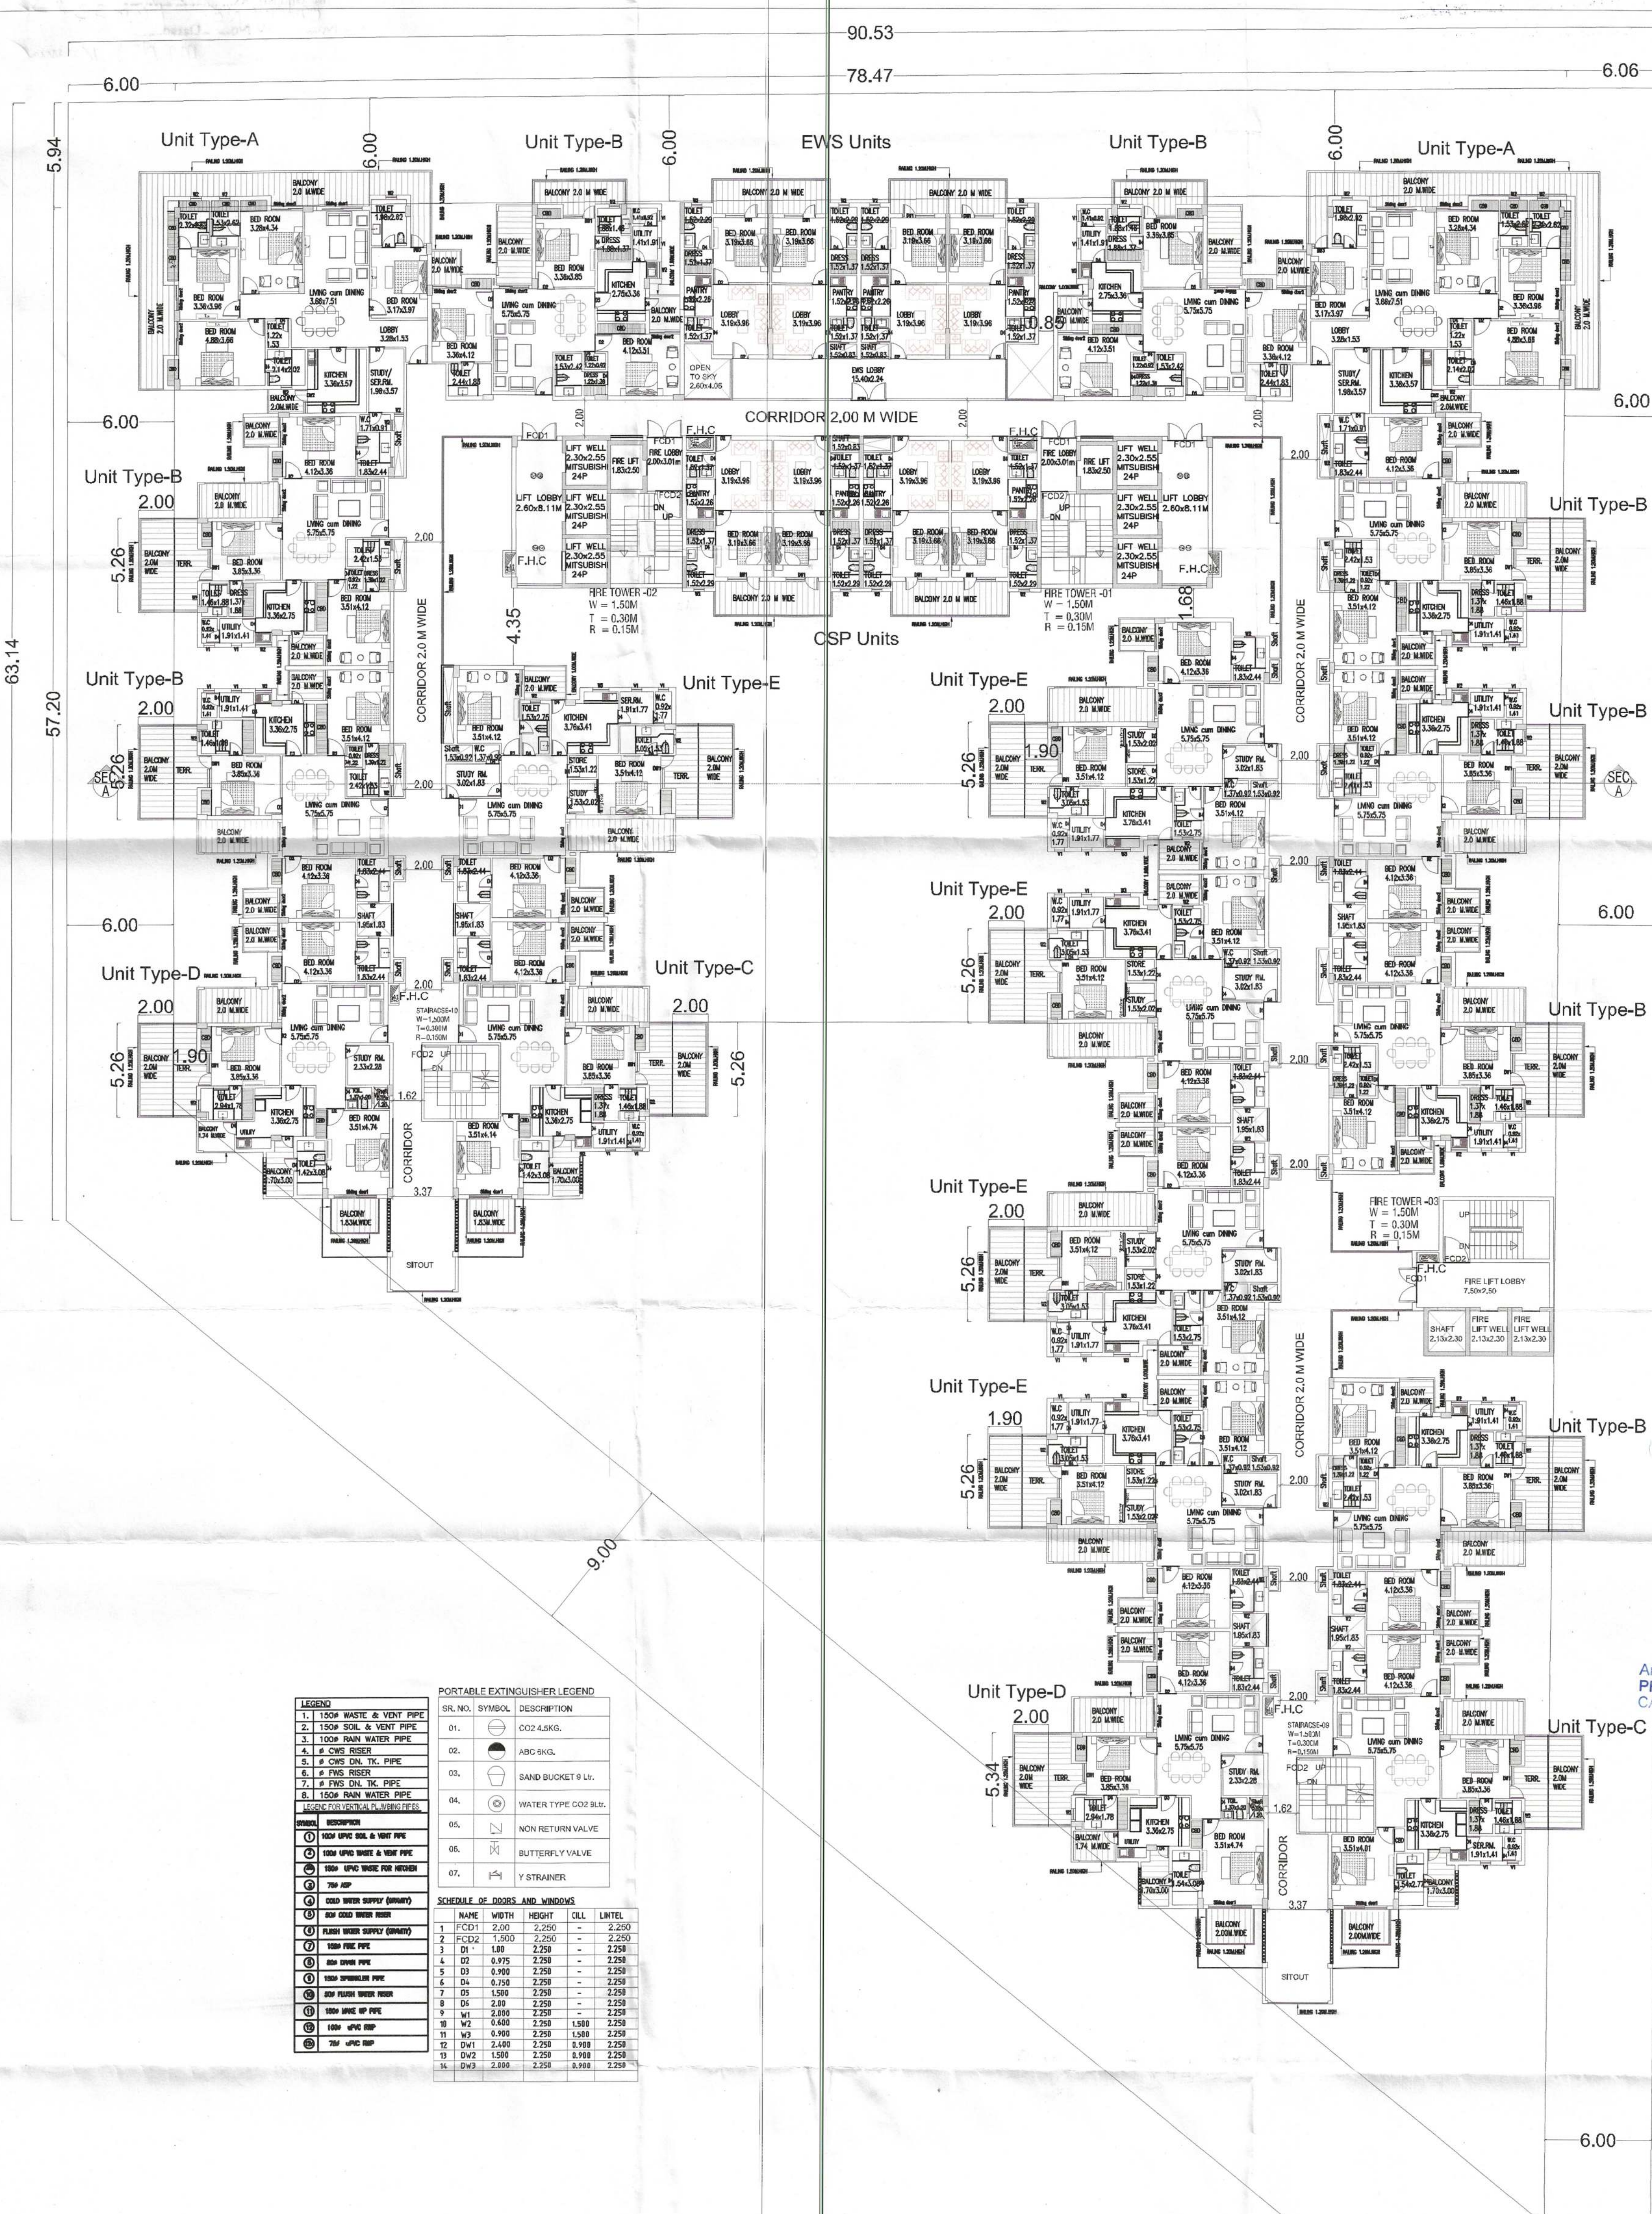

LEGEND	
1.	100W WASTE & VENT PIPE
2.	150W SOIL & VENT PIPE
3.	100P RAIN WATER PIPE
4.	8" CWS RISER
5.	8" PWS ON TK. PIPE
6.	8" PWS RISER
7.	8" PWS ON TK. PIPE
8.	150W RAIN WATER PIPE
LEGEND FOR VERTICAL PLUMBING PIPES	
SYMBOL	DESCRIPTION
1	100W UPVC SOIL & VENT PIPE
2	150W UPVC SOIL & VENT PIPE
3	100P UPVC WASTE & VENT PIPE
4	8" UPVC WASTE FOR KITCHEN
5	8" UPVC WASTE FOR KITCHEN
6	8" UPVC WASTE FOR KITCHEN
100	8" UPVC WASTE FOR KITCHEN

PORTABLE EXTINGUISHER LEGEND		
SR. NO.	SYMBOL	DESCRIPTION
01.		CO2 4.5KG.
02.		ABC 3KG.
03.		SAND BUCKET 9 Lt.
04.		WATER TYPE CO2 SLB.
05.		NON RETURN VALVE
06.		BUTTERFLY VALVE
07.		Y STRAINER

SCHEDULE OF DOORS AND WINDOWS				
	NAME	WIDTH	HEIGHT	LINTEL
1.	FCD1	2.00	2.250	2.250
2.	FCD2	1.500	2.250	2.250
3.	D1	1.80	2.250	2.250
4.	D2	0.975	2.250	2.250
5.	D3	0.900	2.250	2.250
6.	D4	0.750	2.250	2.250
7.	D5	1.500	2.250	2.250
8.	D6	2.80	2.250	2.250
9.	W1	2.800	2.250	2.250
10.	W2	0.400	2.250	1.500 2.250
11.	W3	0.900	2.250	1.500 2.250
12.	DW1	2.400	2.250	0.900 2.250
13.	DW2	1.500	2.250	0.900 2.250
14.	DW3	2.800	2.250	0.900 2.250

5Th.&9Th.FLOOR PLAN
Total Nos Of Units 19

For Anant Raj Limited
Signature
Authorised Signatory

PROJECT :-
PROP. BUILDING PLAN GROUP HOUSING AT BEARING KHASRA
NO 8/26/2 AREA MEASURING 2.947 ACRES AT
VILLAGE KAPASHERA TEHSIL VASANT VIHAR NEW DELHI
BELONGING TO- M/s Anant Raj Limited
Through Its Authorized signatory Sh. Ajay Pathania

Architects
PRADEEP SHARMA
ARCHITECTS ASSOCIATE
64 POORVI MARG, VASANT VIHAR N.DELHI

CONSULTANTS
NNC DESIGN INTERNATIONAL
CONSULTING STRUCTURAL ENGINEERS
G-70, 2nd FLOOR, JASWANT PLAZA, NEAR KALINDI KUNJ
MAIN SARITA VIHAR ROAD, OKHLA, NEW DELHI-110025
PHONE NO. : +91-11-26940734/5/6/7/8 FAX: 26940738
E-Mail : nnc_consultants@hotmail.com
Web : www.nncdesigninternational.com

Drawn	MANOJ	Date	26-04-2021	Scale	26-04-2021	NORTH	
Revisions							
SHEET NO.	1.9	Drawing Title	5th.&9th FLOOR PLAN				

Attested Copy of Online SBP
ID No. 10073854
D/MAN
Bldg (HQ)
SDMC