



BASEMENT - II NON FAR AREA DETAIL				
TOTAL AREA	255.563	X	193.078	= 49345.56
LESS AREA				
B1	1	X	P-Line Area	X
B2	1	X	87.16	X
B3	1	X	P-Line Area	X
B4	1	X	85.90	X
B5	1	X	28.72	X
B6	0.5	X	59.18	X
B7	0.5	X	28.72	X
B8	0.5	X	53.62	X
B9	0.5	X	40.63	X
B10	1	X	P-Line Area	X
B11	1	X	P-Line Area	X
TOTAL BASEMENT AREA = TOTAL AREA - LESS AREA				
			49343.59	= 18475.91
				= 30867.89
TOTAL NON FAR AREA = TOTAL BASEMENT AREA - 15% FAR AREA - CUTOUT AREA				
	30867.89	-	794.96	= 945.91
				= 29125.82

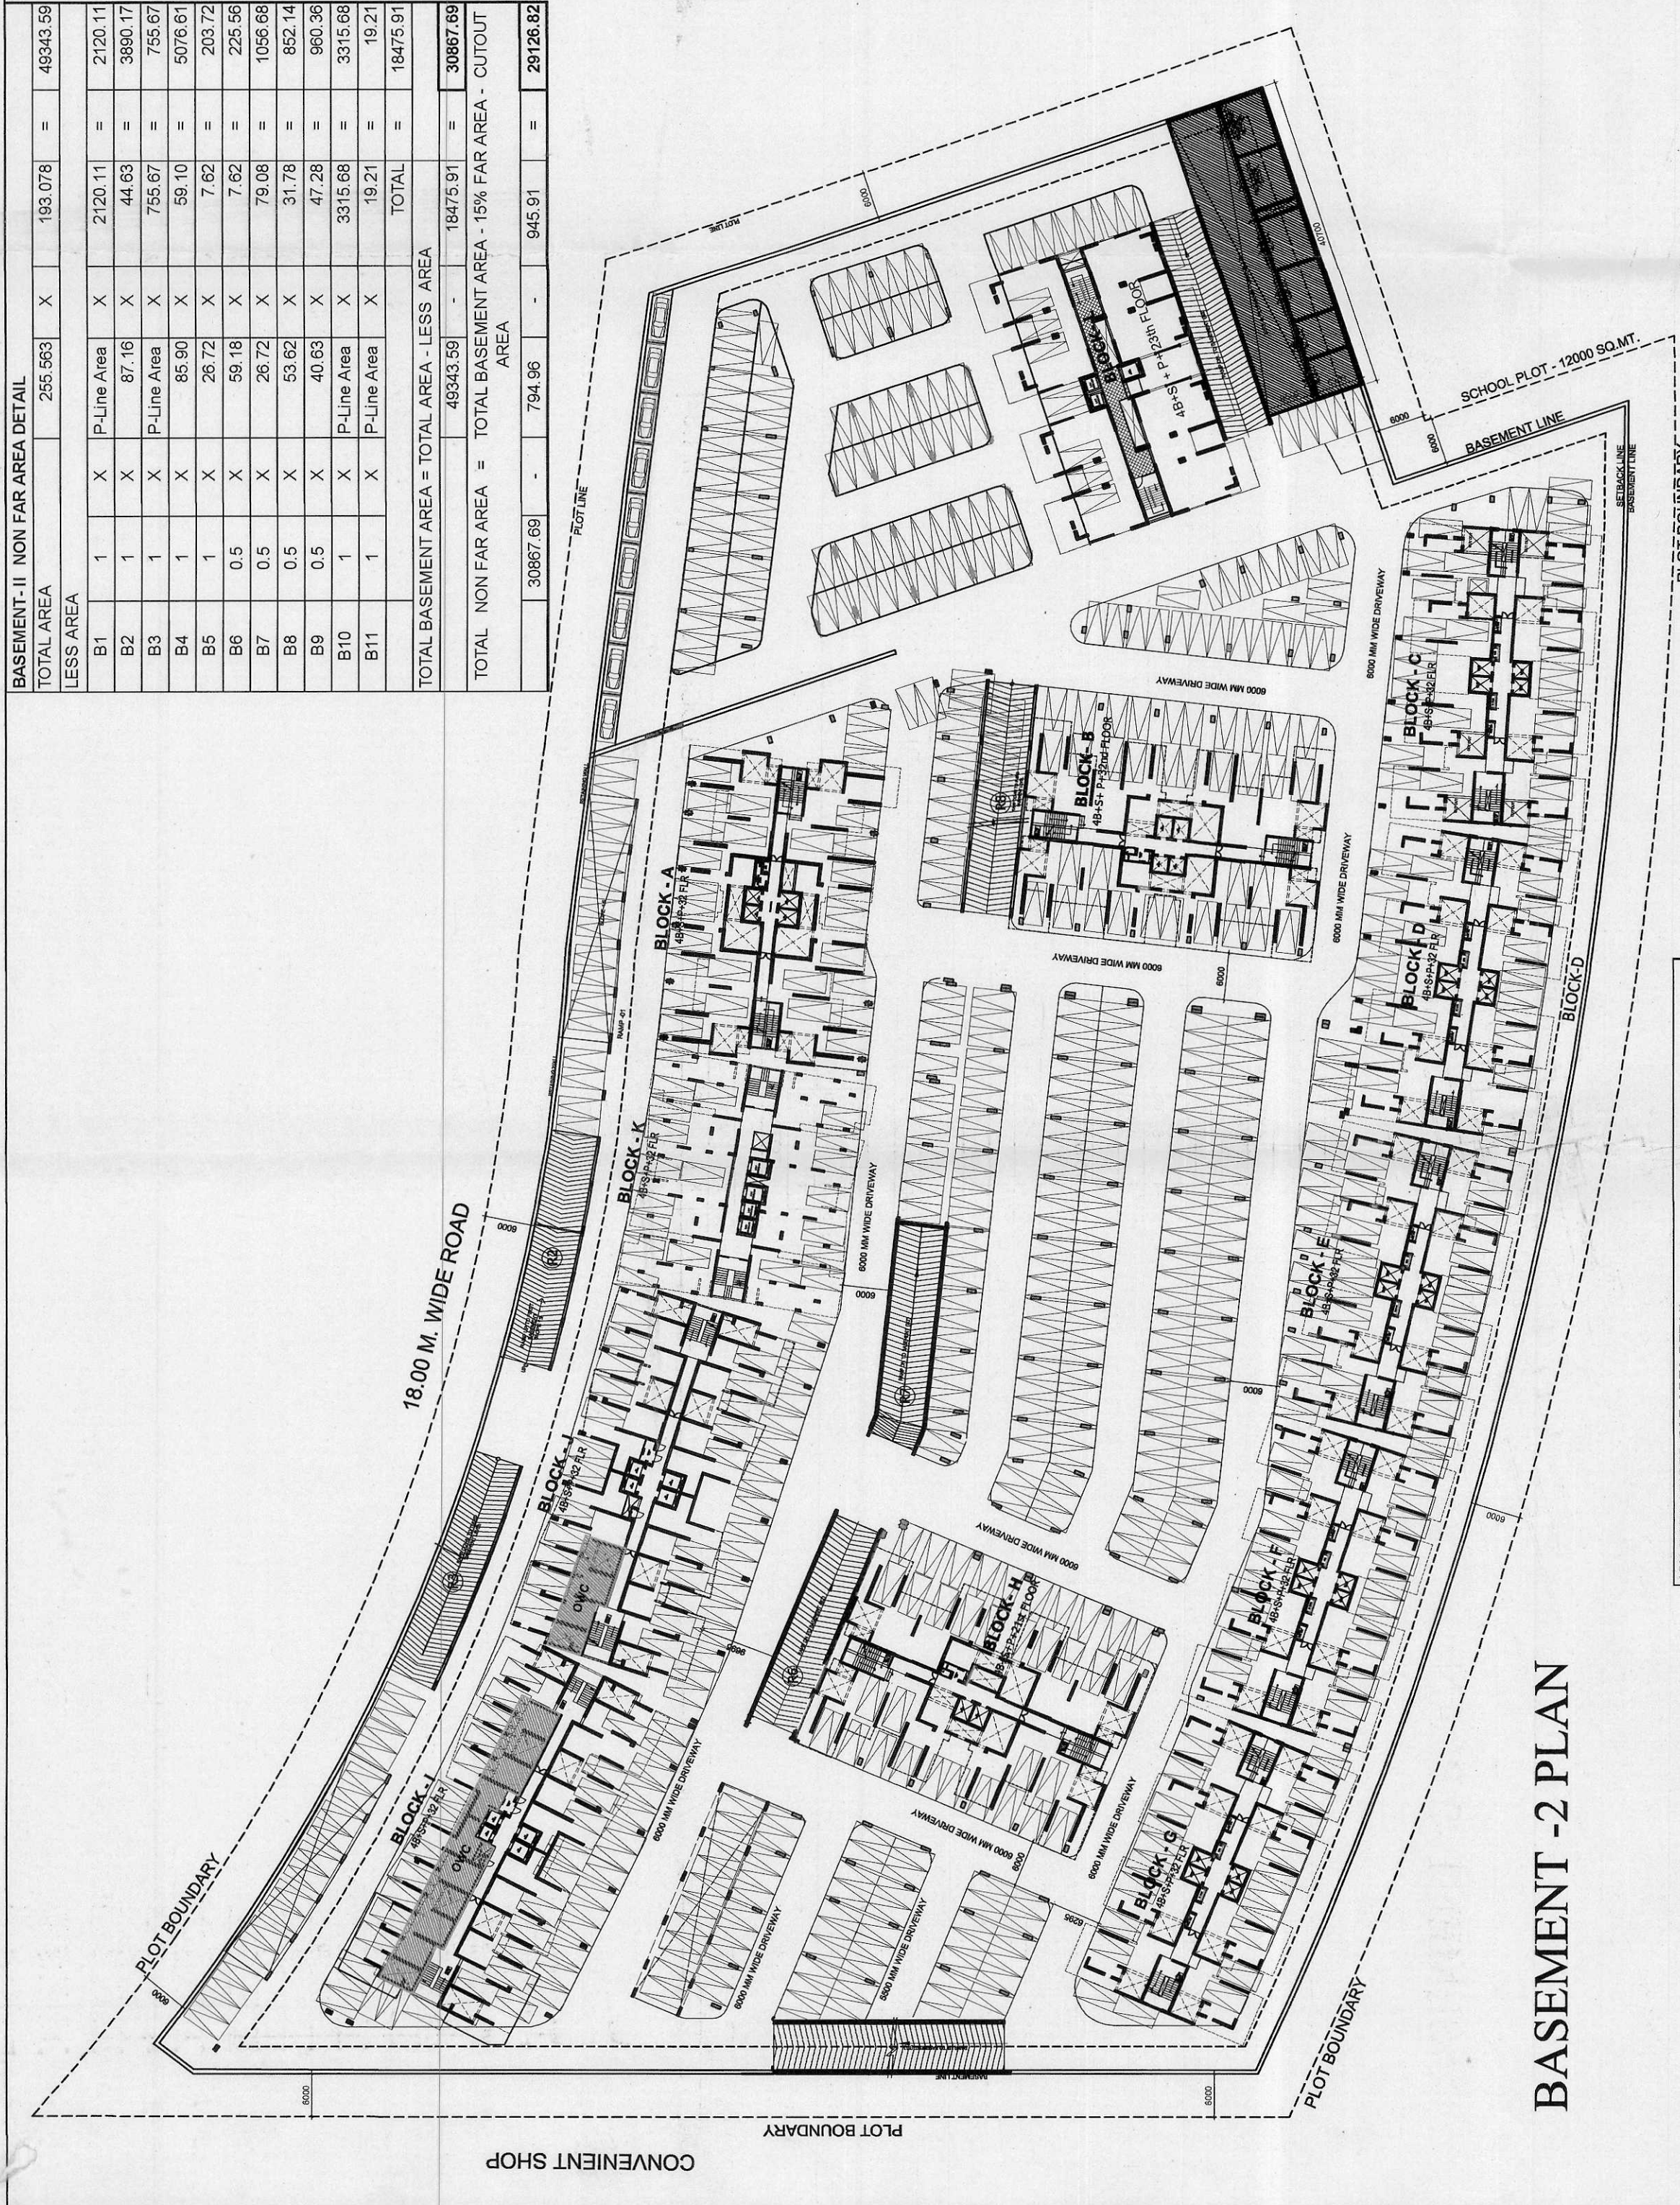


BASEMENT - 2 PLAN

15% PRESCRIBED FAR AREA DETAIL				
(a) O.W.C				
1	1	X	7.000	X
2	1	X	14.340	X
3	1	X	4.545	X
4	1	X	3.170	X
5	1	X	11.720	X
6	1	X	6.925	X
7	1	X	7.835	X
TOTAL				
				274.00
(b) FIRE & PLUMBING PLANT ROOM				
	1	X	40.70	X
				6.50
				284.45
(c) UGT				
	1	X	40.70	X
				6.30
				256.41
TOTAL 15% FAR AREA (b)+(c)				
				794.96

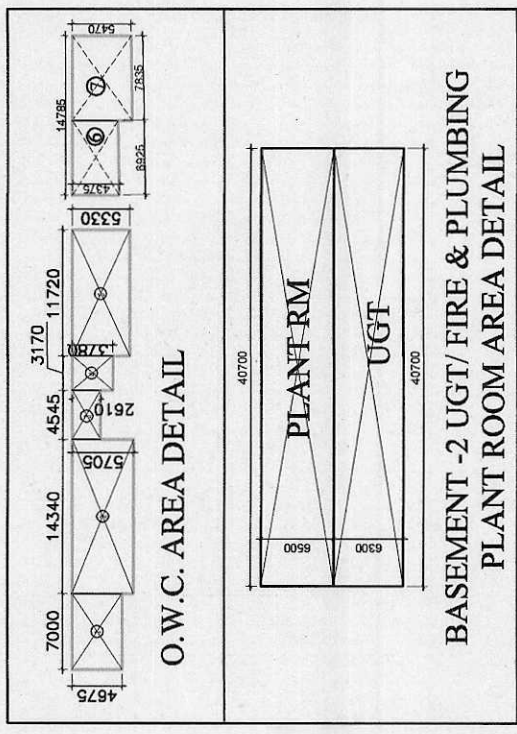


TOTAL BASEMENT LOBBY AREA		
S.NO.	BLOCKS	AREA
1	BLOCK - A	= 117.97
2	BLOCK - B	= 117.97
3	BLOCK - C	= 153.35
4	BLOCK - D	= 153.35
5	BLOCK - E	= 153.35
6	BLOCK - F	= 153.35
7	BLOCK - G	= 153.35
8	BLOCK - H	= 108.14
9	BLOCK - I	= 154.69
10	BLOCK - J	= 154.69
11	BLOCK - K	= 125.61
12	BLOCK - L	= 121.34
TOTAL		= 1667.16

BASEMENT LOBBY AREA DETAIL				
BLOCK - A & B				
1	2	X	6.130	X
2	2	X	9.805	X
3	1	X	4.510	X
TOTAL				
				117.97
BLOCK - C, D, E, F & G				
1	2	X	6.660	X
2	2	X	8.130	X
3	1	X	4.510	X
TOTAL				
				153.35
BLOCK - H				
1	2	X	6.130	X
2	2	X	9.805	X
3	1	X	4.510	X
TOTAL				
				108.14
BLOCK - I & J				
1	2	X	7.105	X
2	1	X	4.325	X
3	1	X	4.590	X
4	1	X	3.150	X
5	1	X	7.225	X
TOTAL				
				154.69
BLOCK - K				
1	1	X	12.860	X
2	1	X	2.42	X
3	1	X	7.855	X
4	1	X	2.410	X
5	1	X	7.425	X
TOTAL				
				32.67
BLOCK - L				
L-1	1	X	3.150	X
L-2	1	X	2.700	X
L-3	1	X	2.150	X
L-4	1	X	2.300	X
L-5	1	X	3.150	X
TOTAL				
				121.34

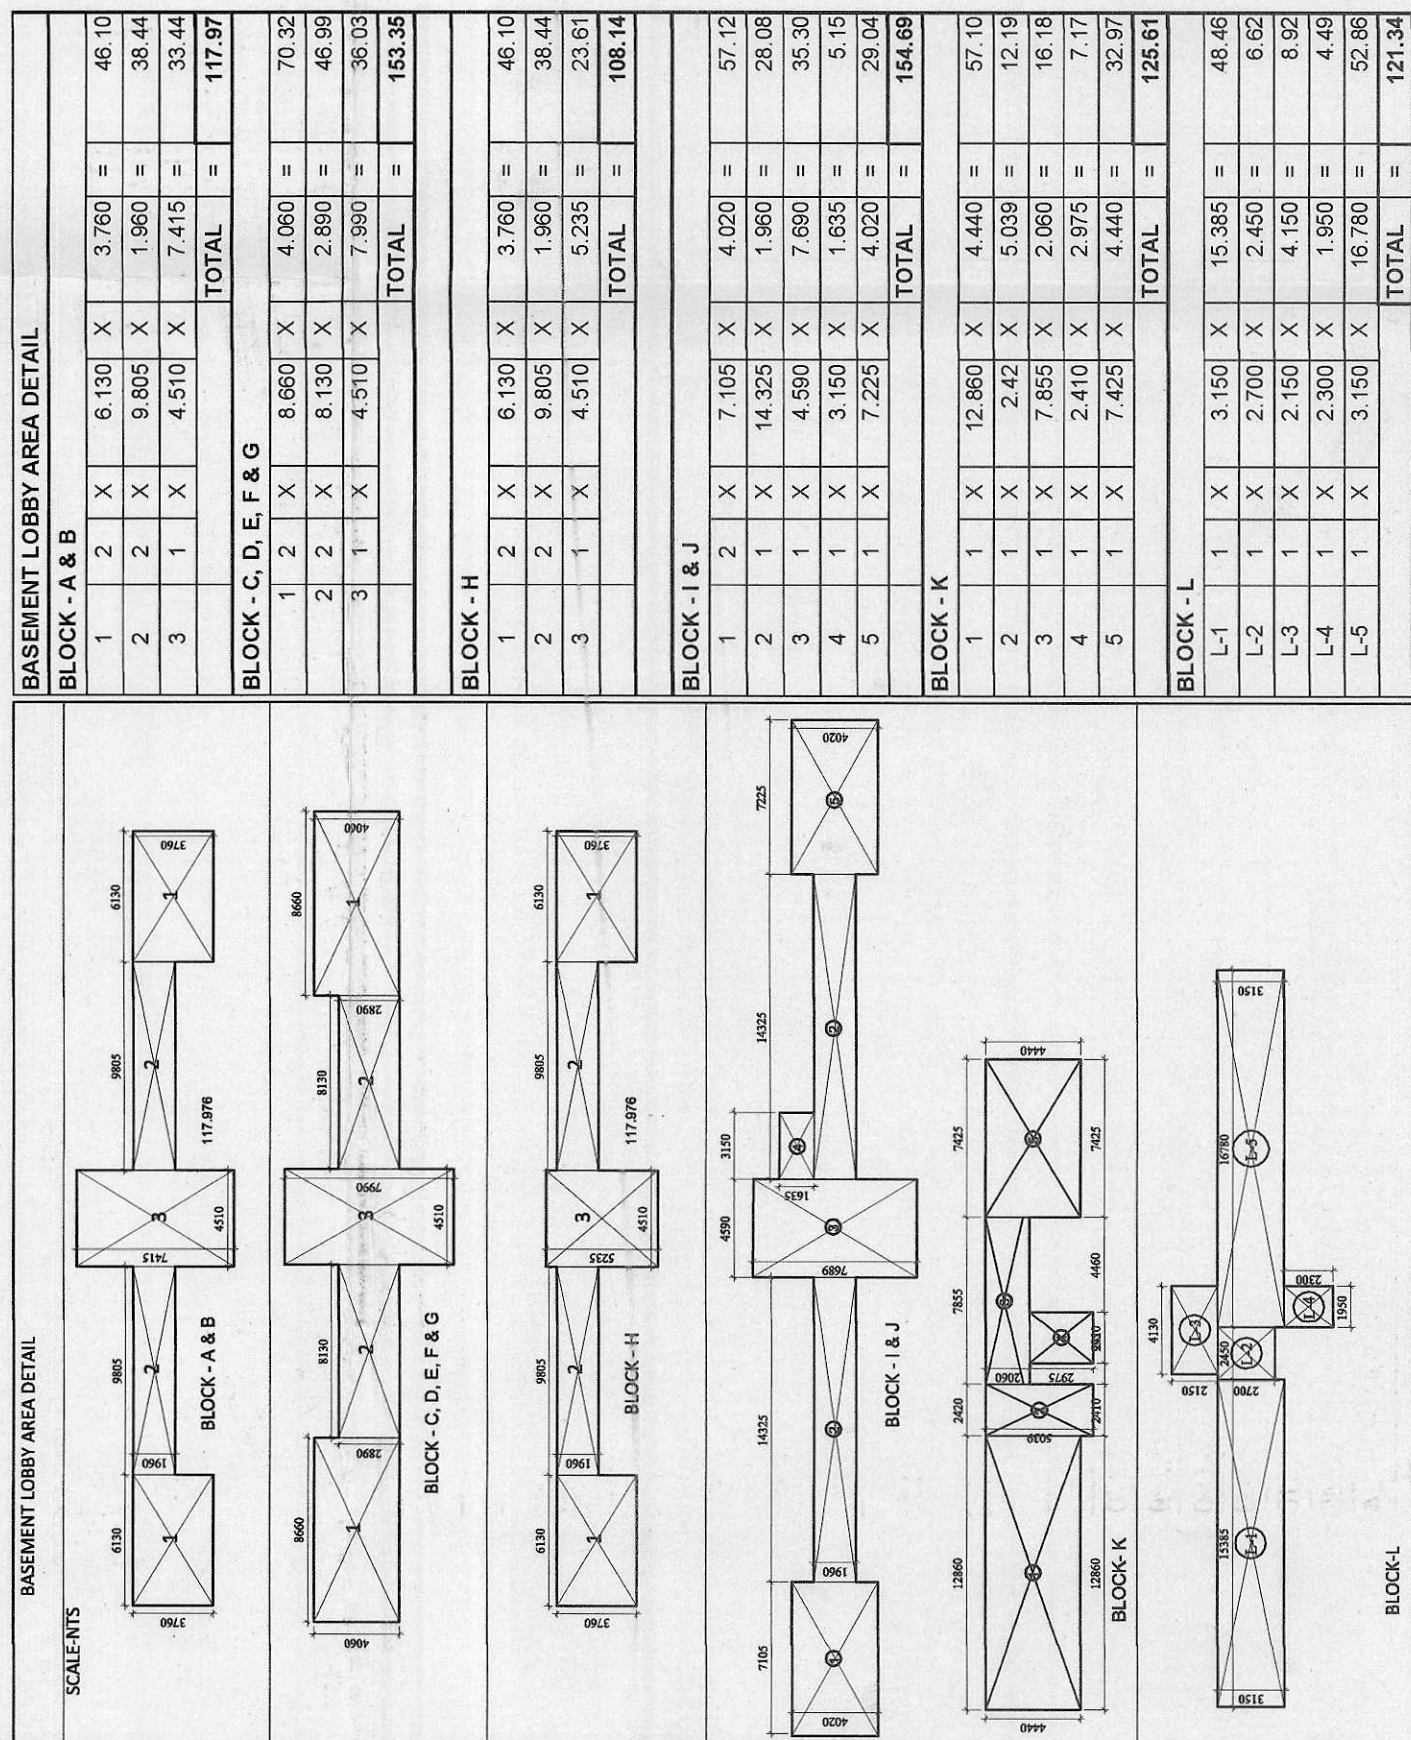

BASEMENT - 2 AREA DETAIL

CUTOUT AND STORAGE, AREA DEAIL

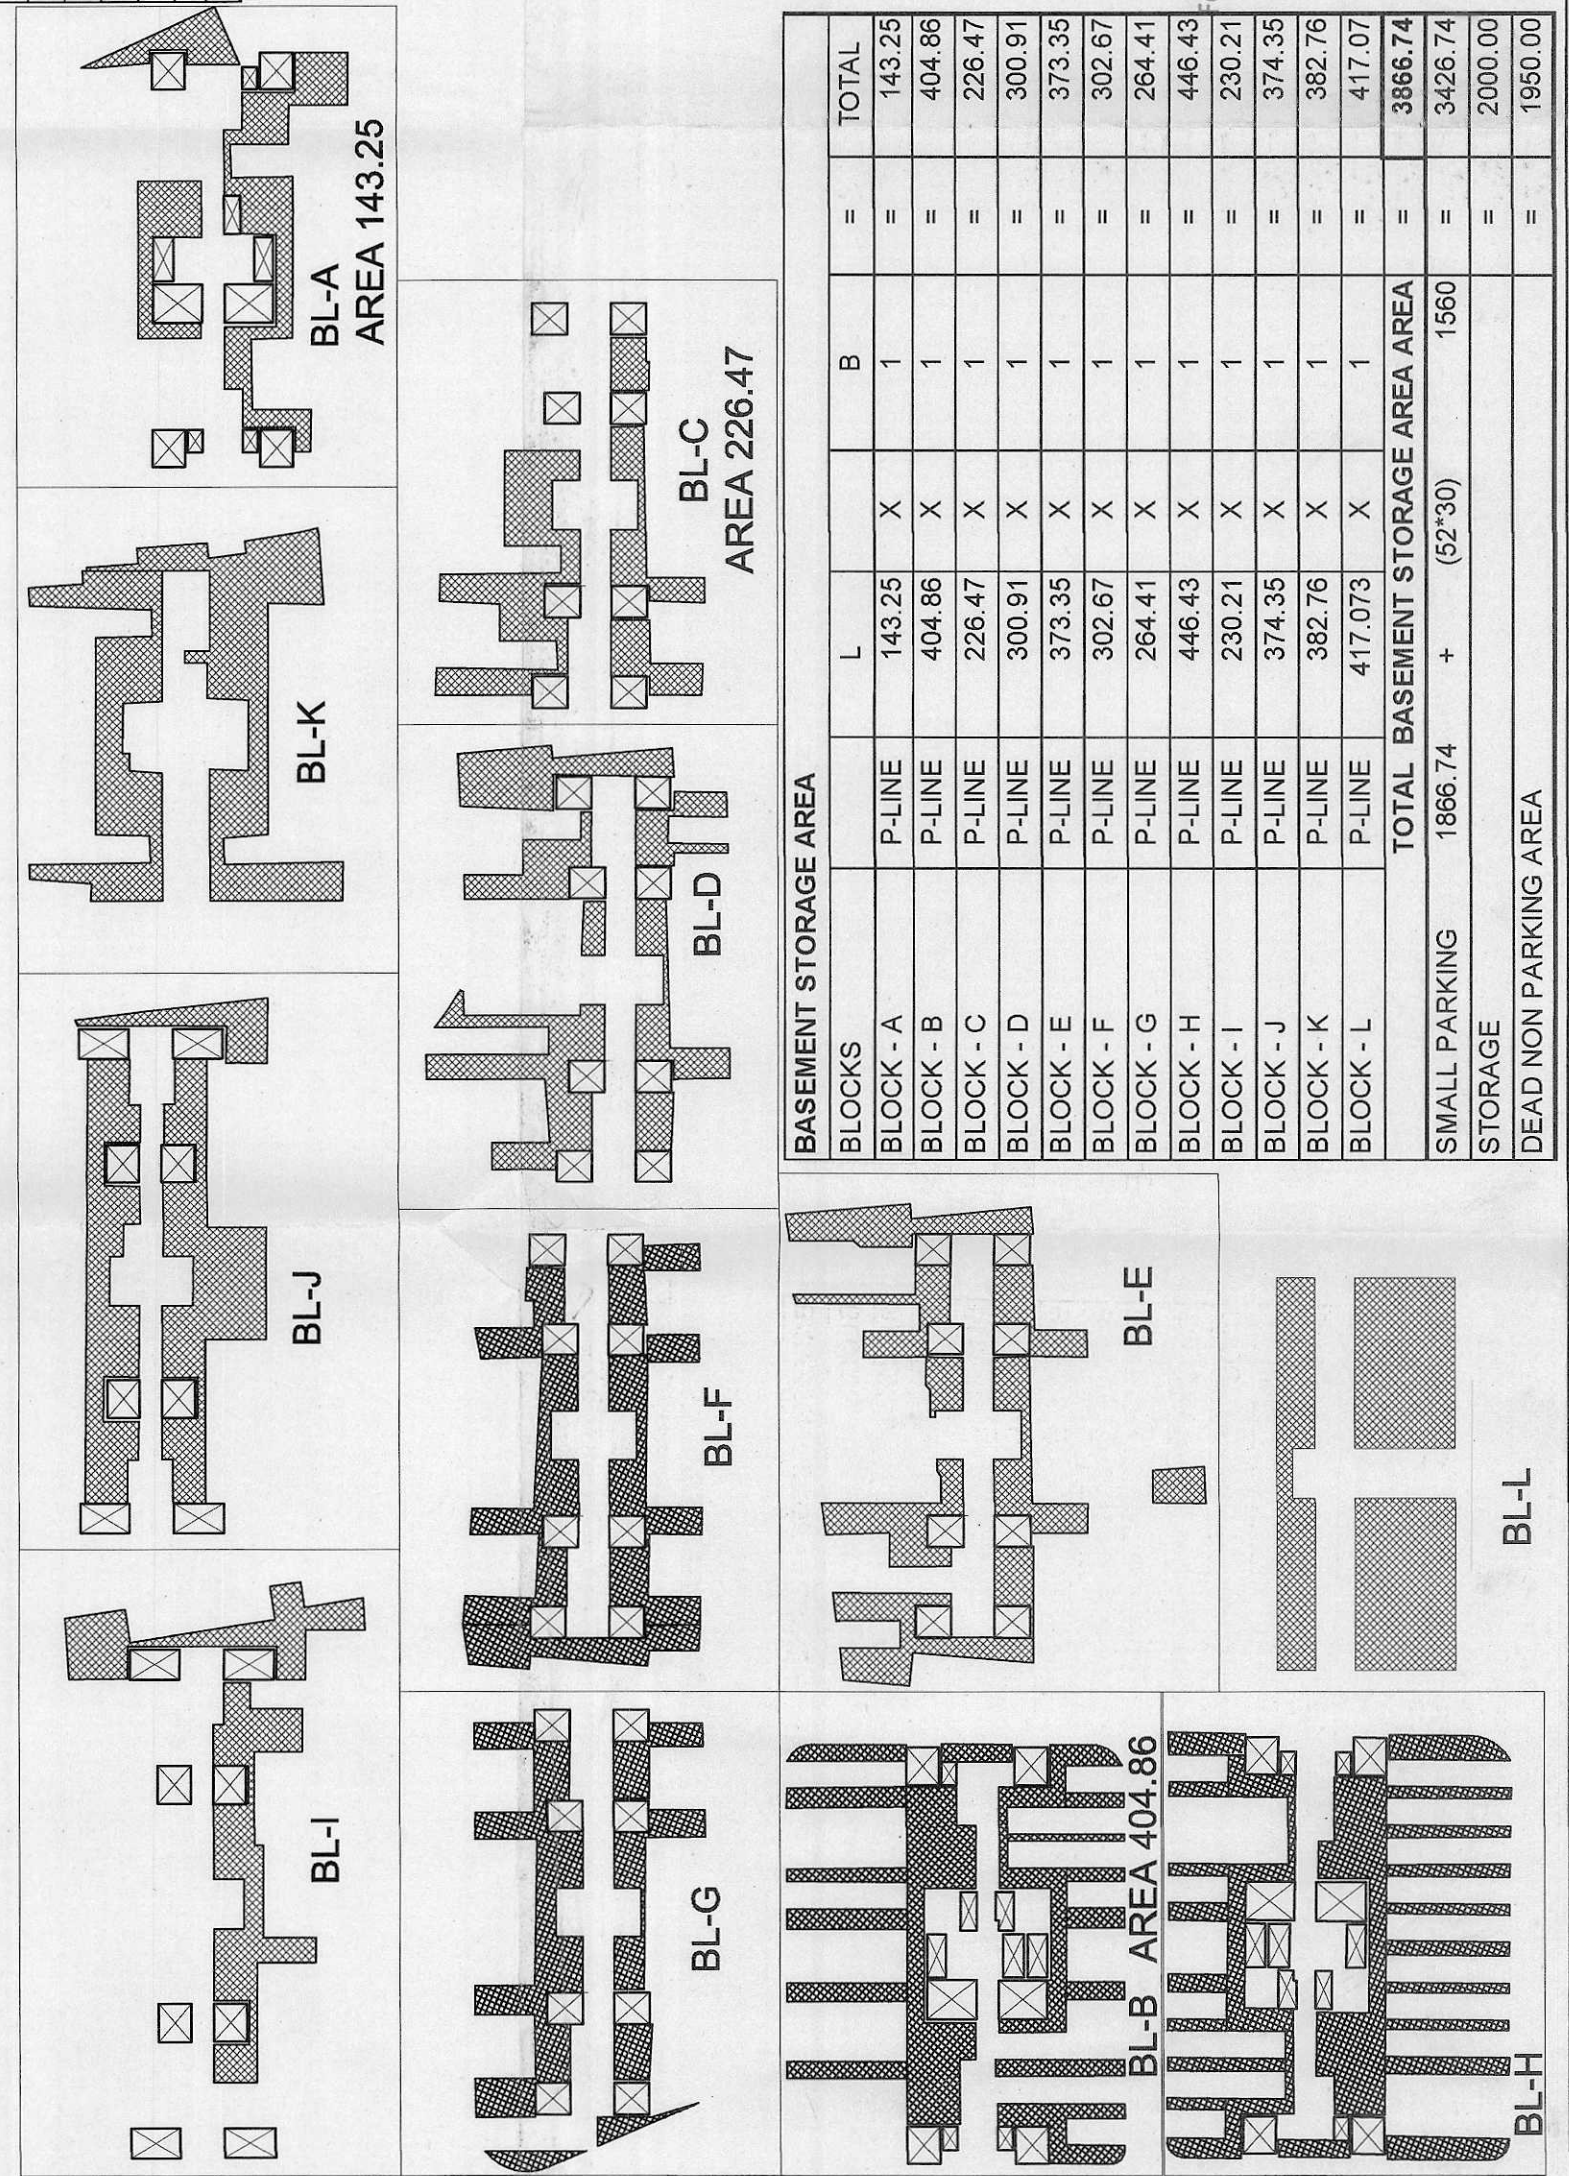

CUTOUT FOR VENTILATION AREA				
BLOCKS	P-LINE	L	B	=
BLOCK - A	P-LINE	103.430	X	1
BLOCK - B	P-LINE	113.18	X	1
BLOCK - C, D, E, F & G	P-LINE	76.740	X	5
BLOCK - H	P-LINE	118.110	X	1
BLOCK - I & J	P-LINE	94.310	X	2
BLOCK - K	P-LINE	38.867	X	1
BLOCK - L	P-LINE			
TOTAL BASEMENT CUTOUT AREA				
				= 946.91

CLIENT :-
GAURSONS HI-TECH INFRASTRUCTURE (P) LIMITED
GAUR BIZ PARK PLOT NO. - 1, ABHAY KHAND- II,
INDRAPURAM, GHAZIABAD

PROJECT :-
GROUP HOUSING PROJECT - GAUR CITY,
AT PLOT NO GC- 7/GH-01, SECTOR - 04,
GREATER NOIDA

REVISD SUBMISSION DRAWING

SCALE :-

TITLE :-

FLOOR PLAN & AREA DETAIL

OWNER'S SIGN

ARCHITECT SIGN

Gaursons Hi-Tech Infrastructure Pvt. Ltd.
KAILASH JAGANMAL ARCHITECTS
(CA-86-1/IND-01)
Gaur Biz Park, Plot No. 1
Abhay Khand, Ghaziabad, U.P.

GC-7
BASEMENT- II
DRG. NO. :- SD-05