
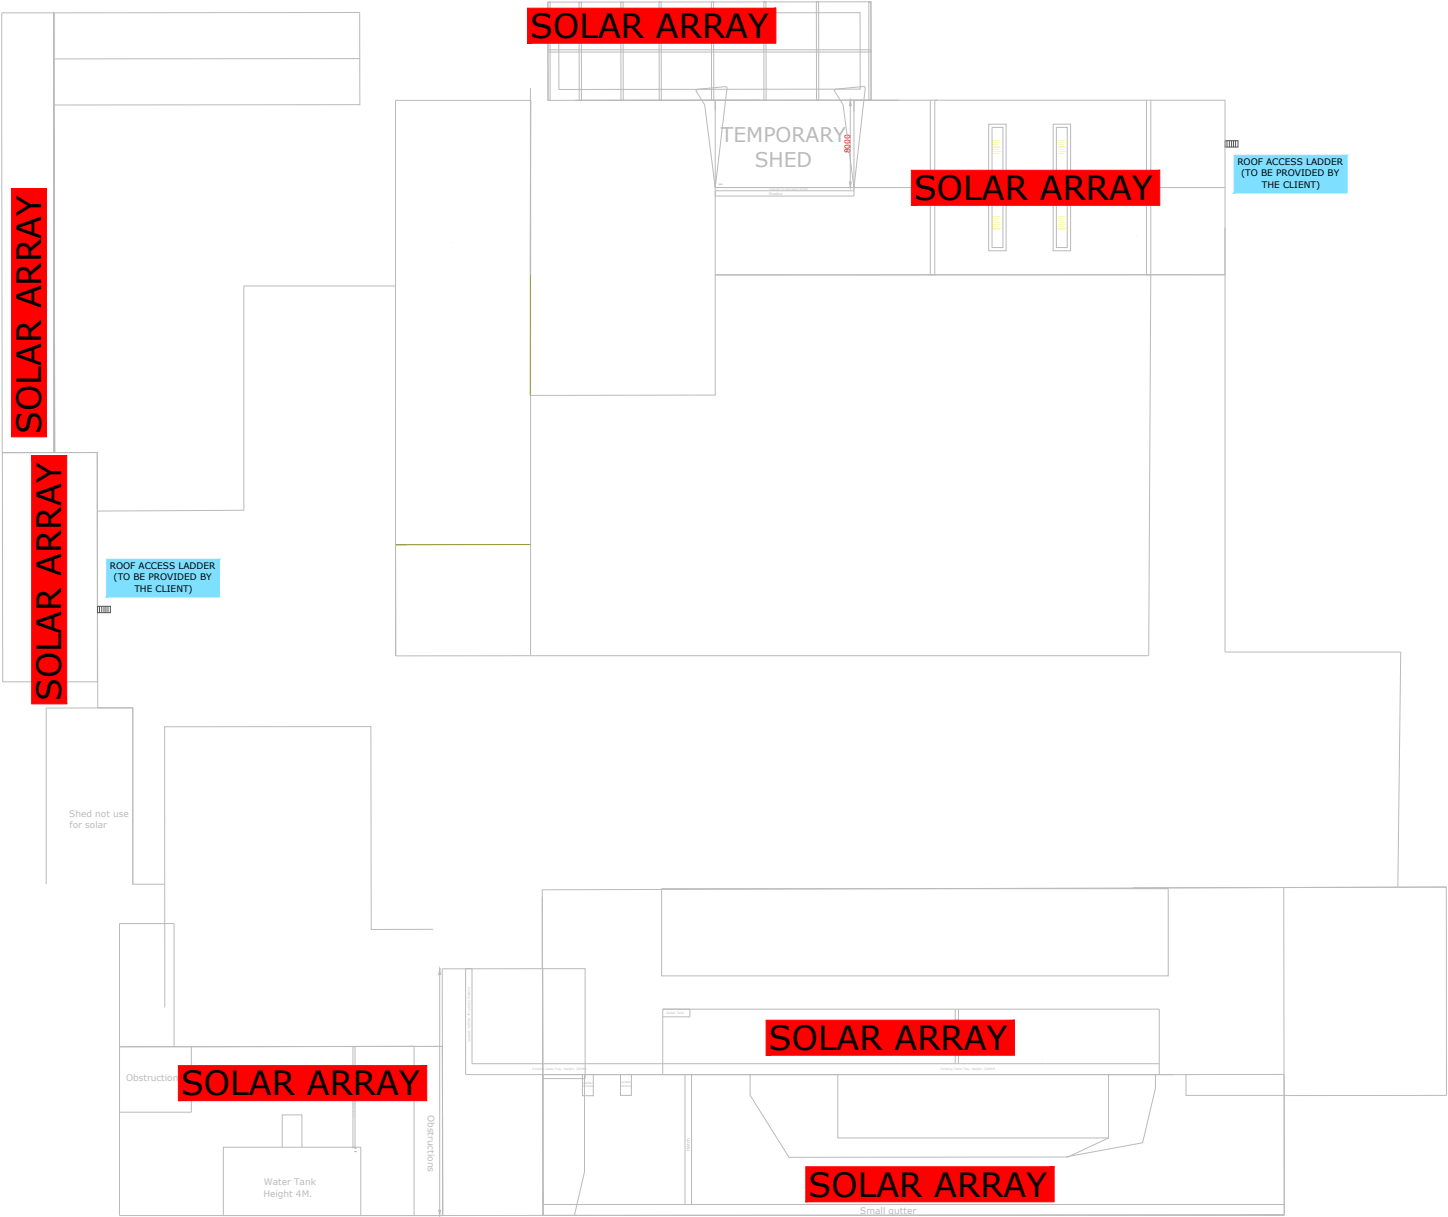
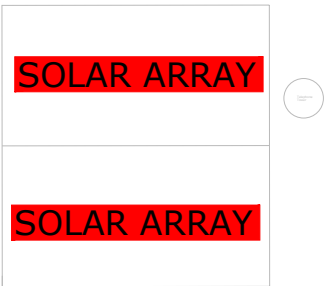
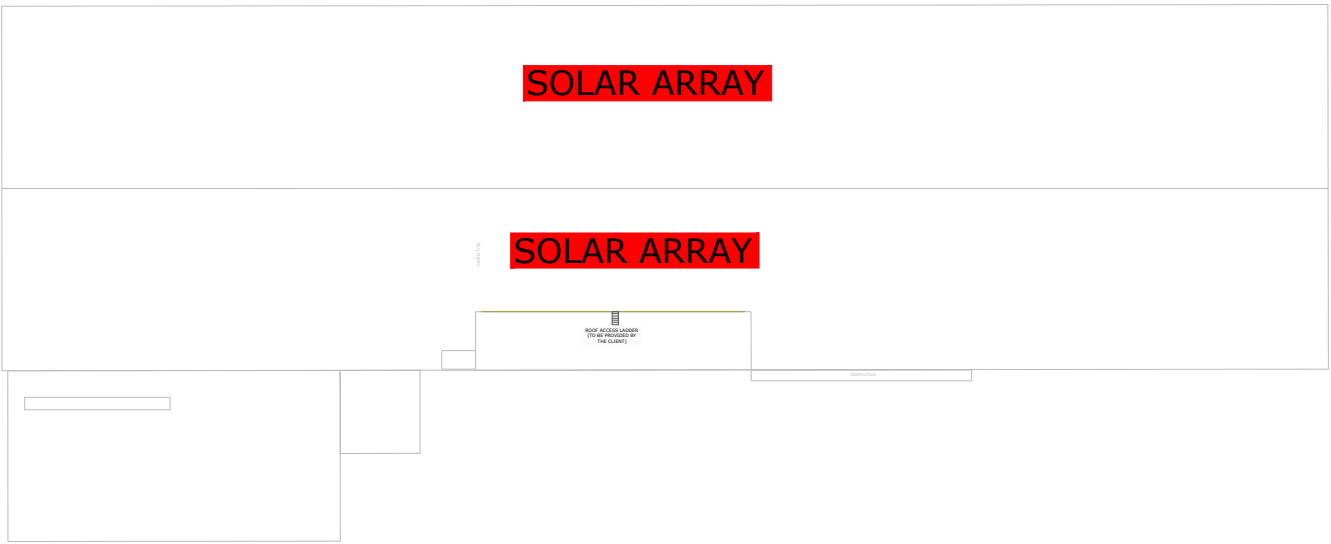


PROJECT DEVELOPER

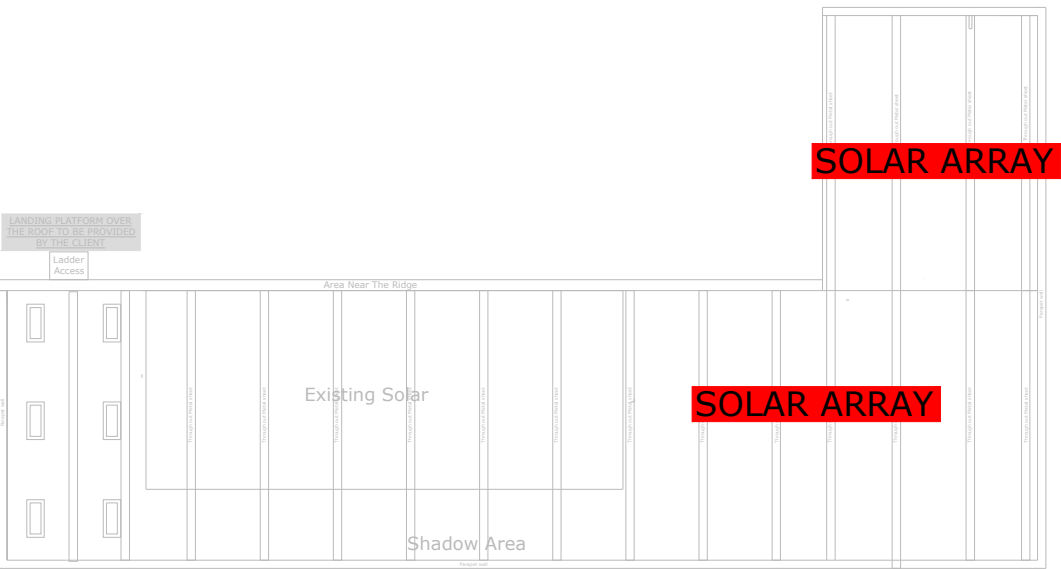

An SHV Energy Company

SunSource Square, Tower A, 5th Floor
Club 125, Sector 125, Noida - 201301
email: contact@sunsorce-energy.com
Ph: +91 8130033213
www.sunsorce-energy.com

PROJECT CO-DEVELOPER



H-12, 1st FLOOR SECTOR 9, NOIDA,
UTTAR PRADESH, 201301

PROJECT NAME
Stride Pharma

PROJECT ADDRESS
KRSG
BENGALURU

SITE PLAN

REVISION HISTORY				
REV	DESCRIPTION	DRW	CHK	
0	DRAFT REVIEW	VS	VA	01/06/2022
1	CAPACITY REVISED	VS	VA	03/06/2022

PROJECT NUMBER			PAGE	SIZE
			A3	
SHEET NUMBER		SCALE		
3		NTS		
DISC.	DWG NO.	SEQUENCE	SUPP.	
	PV-1			

ISSUED FOR
APPROVAL


SYSTEM PROPERTIES	
DESCRIPTION	DETAILS
NO. OF MODULES	600 Nos
MODULE WATTAGE	320 Wp
INVERTER CAPACITY	(1)110kW (1) 25KW
MOUNTING SYSTEM TYPE	INDUSTRIAL SHED
SOLAR ARRAY AZIMUTH	8° / -172°
SOLAR MODULE TILT	ALONG THE SHED
TOTAL DC SYSTEM SIZE	192.0 kWp

Array	No of Modules	kWp	Array Azimuth	Tilt	Size Of Inverter
1	160	51.2	-172°	8°	(1)110KW
2	440	140.8	8°	8°	(1)25KW
Total	600	192.0			

LEGEND

SOLAR MODULE

SHADOW

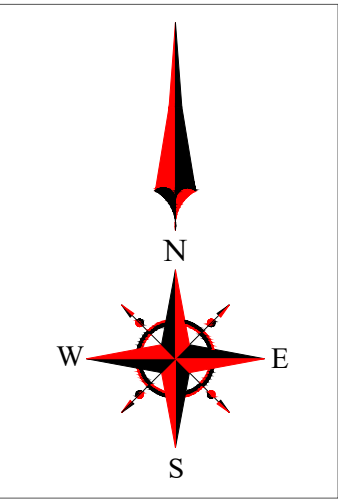

PROJECT DEVELOPER

SunSource ENERGY

An SHV Energy Company

SunSource Square, Tower A, 5th Floor
Club 125, Sector 125, Noida - 201301
email: contact@sunsource-energy.com
Ph: +91 8130033213
www.sunsource-energy.com

PROJECT CO-DEVELOPER

Solar Solutions

H-12, 1st FLOOR SECTOR 9, NOIDA,
UTTAR PRADESH, 201301

PROJECT NAME

Stride Pharma

PROJECT ADDRESS

KRSG
BENGALURU

MODULE LAYOUT

ARRAY (1 & 2)

REVISION HISTORY				
REV	DESCRIPTION	DRW	CHK	
0	DRAFT REVIEW	VS	VA	01/06/2022
1	CAPACITY REVISED	VS	VA	03/06/2022


PROJECT NUMBER

PAGE SIZE

A3

SHEET NUMBER		SCALE	
8		NTS	
DISC.	DWG NO.	SEQUENCE	SUPP.
	PV-2		

ISSUED FOR
APPROVAL

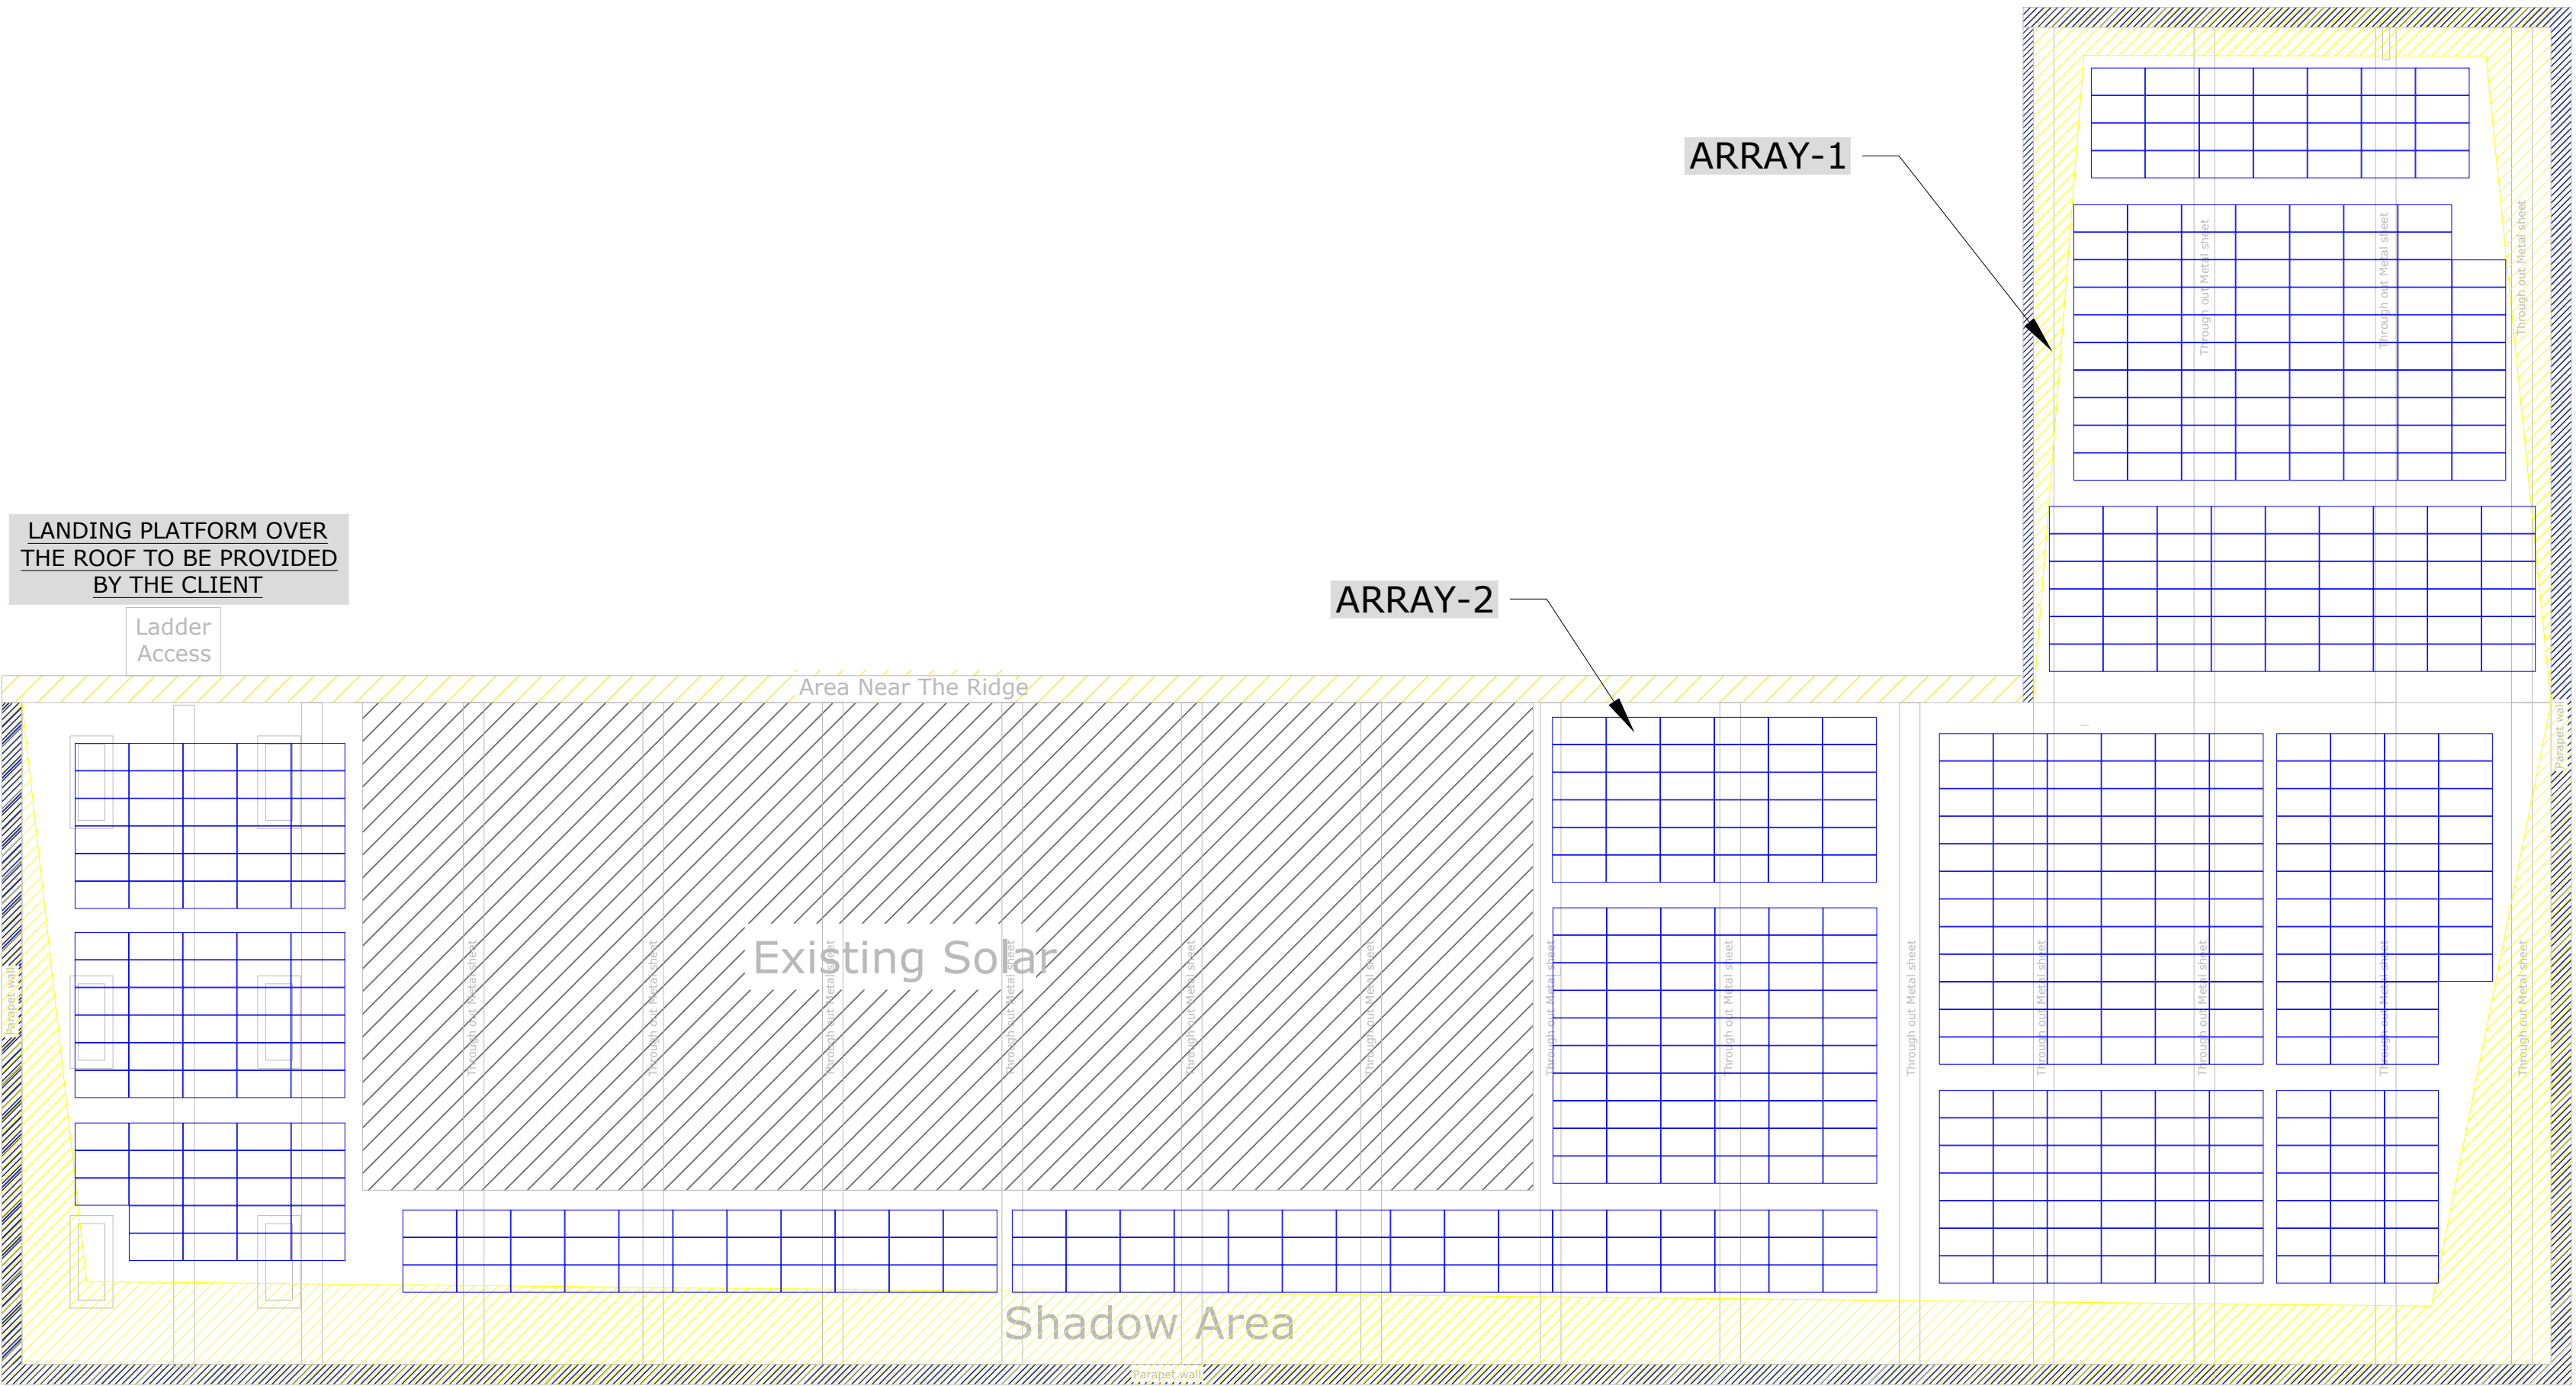


SYSTEM PROPERTIES	
DESCRIPTION	DETAILS
NO. OF MODULES	1580 Nos
MODULE WATTAGE	320Wp
INVERTER CAPACITY	(3)110kW (1) 20kW
MOUNTING SYSTEM TYPE	INDUSTRIAL SHED/RCC
SOLAR ARRAY AZIMUTH	8° / -172°
SOLAR MODULE TILT	ALONG THE SHED
TOTAL DC SYSTEM SIZE	505.60 kWp

Array	No of Modules	kWp	Array Azimuth	Tilt	Size Of Inverter
3	800	256	-172°	8°	(3)110KW (1)20KW
4	680	218	8°	8°	
5	100	32	8°	15°	

LEGEND

SOLAR MODULE

SHADOW

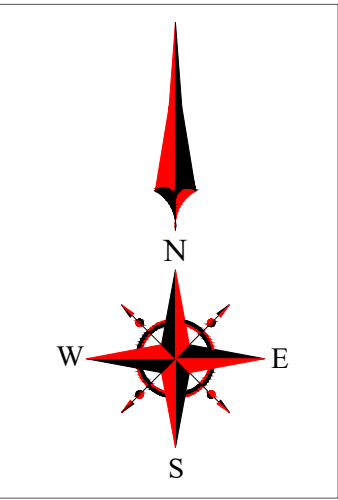

PROJECT DEVELOPER

SunSource ENERGY

An SHV Energy Company

SunSource Square, Tower A, 5th Floor
Club 125, Sector 125, Noida - 201301
email: contact@sunsorce-energy.com
Ph: +91 8130033213
www.sunsorce-energy.com

PROJECT CO-DEVELOPER

H-12, 1St FLOOR SECTOR 9, NOIDA,
UTTAR PRADESH, 201301

PROJECT NAME

Stride Pharma

PROJECT ADDRESS

KRSG
BENGALURU

MODULE LAYOUT

ARRAY (3 to 5)

REVISION HISTORY				
REV	DESCRIPTION	DRW	CHK	
0	DRAFT REVIEW	VS	VA	01/06/2022
1	CAPACITY REVISED	VS	VA	03/06/2022

PROJECT NUMBER			PAGE SIZE
			A3
SHEET NUMBER		SCALE	
9		NTS	
DISC.	DWG NO.	SEQUENCE	SUPP.
	PV-2		

ISSUED FOR
APPROVAL


SYSTEM PROPERTIES	
DESCRIPTION	DETAILS
NO. OF MODULES	749 Nos
MODULE WATTAGE	320Wp
INVERTER CAPACITY	(1)40kW, (2)80KW
MOUNTING SYSTEM TYPE	INDUSTRIAL SHED
SOLAR ARRAY AZIMUTH	8° / -172°
SOLAR MODULE TILT	ALONG THE SHED
TOTAL DC SYSTEM SIZE	239.68 kWp

Array	No of Modules	kWp	Array Azimuth	Tilt	Size Of Inverter
6	72	23.04	8°	15°	(1)80kW
7	67	21.44	-172°	15°	
8	70	22.40	8°	15°	
9	140	44.80	-82°	5°	(1)40KW
10	234	74.88	8°	15°	(1)80kW
11	86	27.52	8° / -82°	15°	
12	80	25.60	-82°	15°	
Total	749	239.68			

LEGEND

SOLAR MODULE

SHADOW

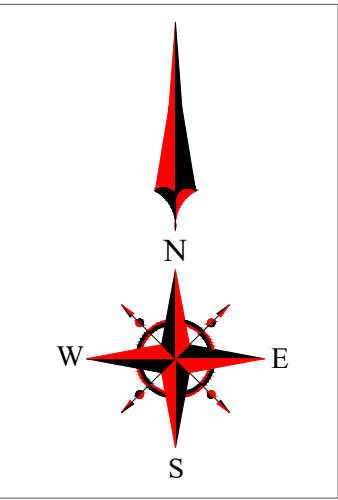

PROJECT DEVELOPER

SunSource ENERGY

An SHV Energy Company

SunSource Square, Tower A, 5th Floor
Club 125, Sector 125, Noida - 201301
email: contact@sunsorce-energy.com
Ph: +91 8130033213
www.sunsorce-energy.com

PROJECT CO-DEVELOPER

Solar Solutions

H-12, 1st FLOOR SECTOR 9, NOIDA,
UTTAR PRADESH, 201301

PROJECT NAME

Stride Pharma

PROJECT ADDRESS


KRSG
BENGALURU

MODULE LAYOUT
ARRAY (6 to 12)

REVISION HISTORY				
REV	DESCRIPTION	DRW	CHK	
0	DRAFT REVIEW	VS	VA	01/06/2022
1	CAPACITY REVISED	VS	VA	03/06/2022

PROJECT NUMBER		PAGE SIZE	
		A3	
SHEET NUMBER		SCALE	
10		NTS	
DISC.	DWG NO.	SEQUENCE	SUPP.
	PV-2		

ISSUED FOR
APPROVAL

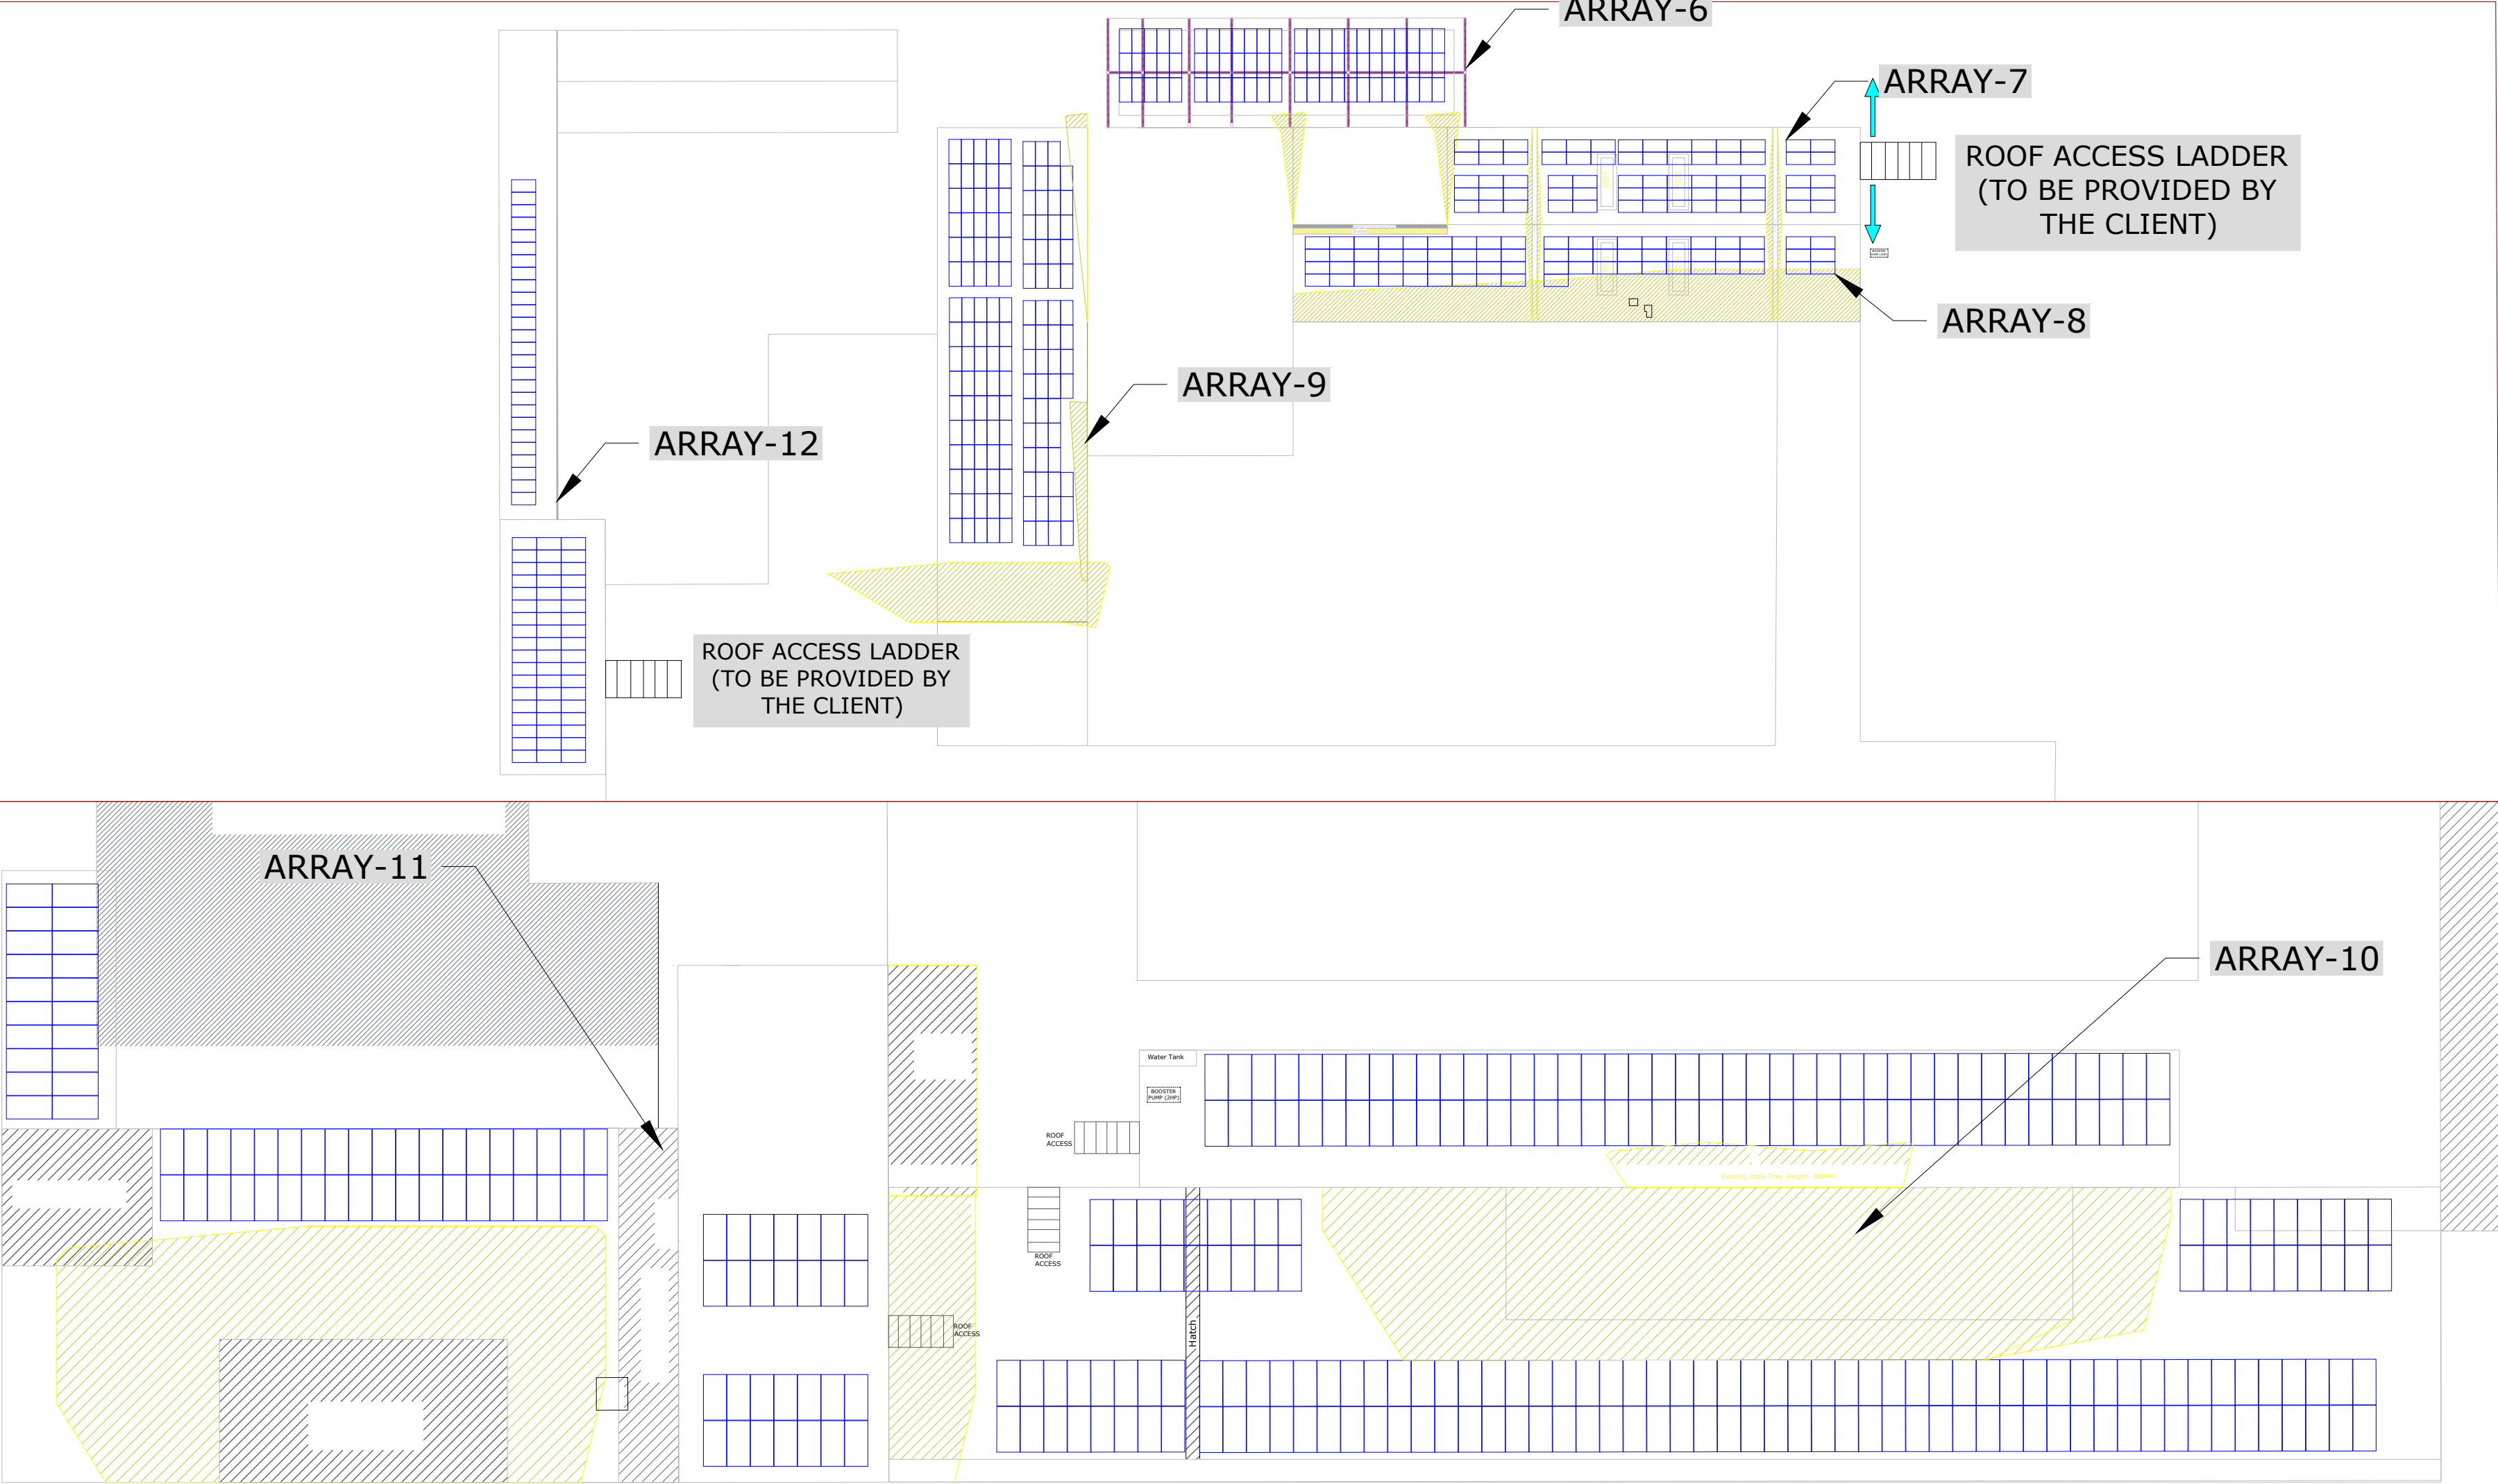


SYSTEM PROPERTIES	
DESCRIPTION	DETAILS
NO. OF MODULES	180 Nos
MODULE WATTAGE	320Wp
INVERTER CAPACITY	(1)50kW
MOUNTING SYSTEM TYPE	INDUSTRIAL SHED
SOLAR ARRAY AZIMUTH	8° / -172°
SOLAR MODULE TILT	ALONG THE SHED
TOTAL DC SYSTEM SIZE	57.6 kWp

Array	No of Modules	kWp	Array Azimuth	Tilt	Size Of Inverter
13	100	32	8°	12°	(1)50KW
14	80	25.6	-172°	12°	
Total	180	57.6			

LEGEND

SOLAR MODULE

SHADOW

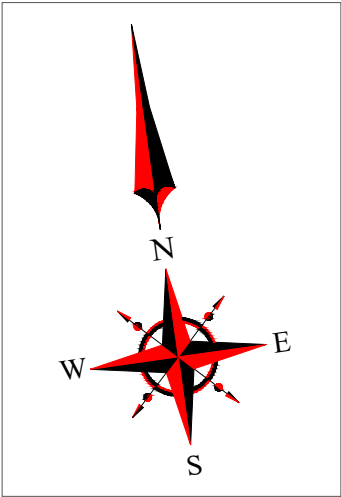

PROJECT DEVELOPER

SunSource ENERGY

An SHV Energy Company

SunSource Square, Tower A, 5th Floor
Club 125, Sector 125, Noida - 201301
email: contact@sunsorce-energy.com
Ph: +91 8130033213
www.sunsorce-energy.com

PROJECT CO-DEVELOPER

H-12, 1st FLOOR SECTOR 9, NOIDA,
UTTAR PRADESH, 201301

PROJECT NAME

Stride Pharma

PROJECT ADDRESS


KRSG
BENGALURU

MODULE LAYOUT

ARRAY (13 & 14)

REVISION HISTORY				
REV	DESCRIPTION	DRW	CHK	
0	DRAFT REVIEW	VS	VA	01/06/2022
1	CAPACITY REVISED	VS	VA	03/06/2022
PROJECT NUMBER				PAGE SIZE
				A3
SHEET NUMBER		SCALE		
11		NTS		
DISC.	DWG NO.	SEQUENCE		SUPP.
	PV-2			

ISSUED FOR APPROVAL

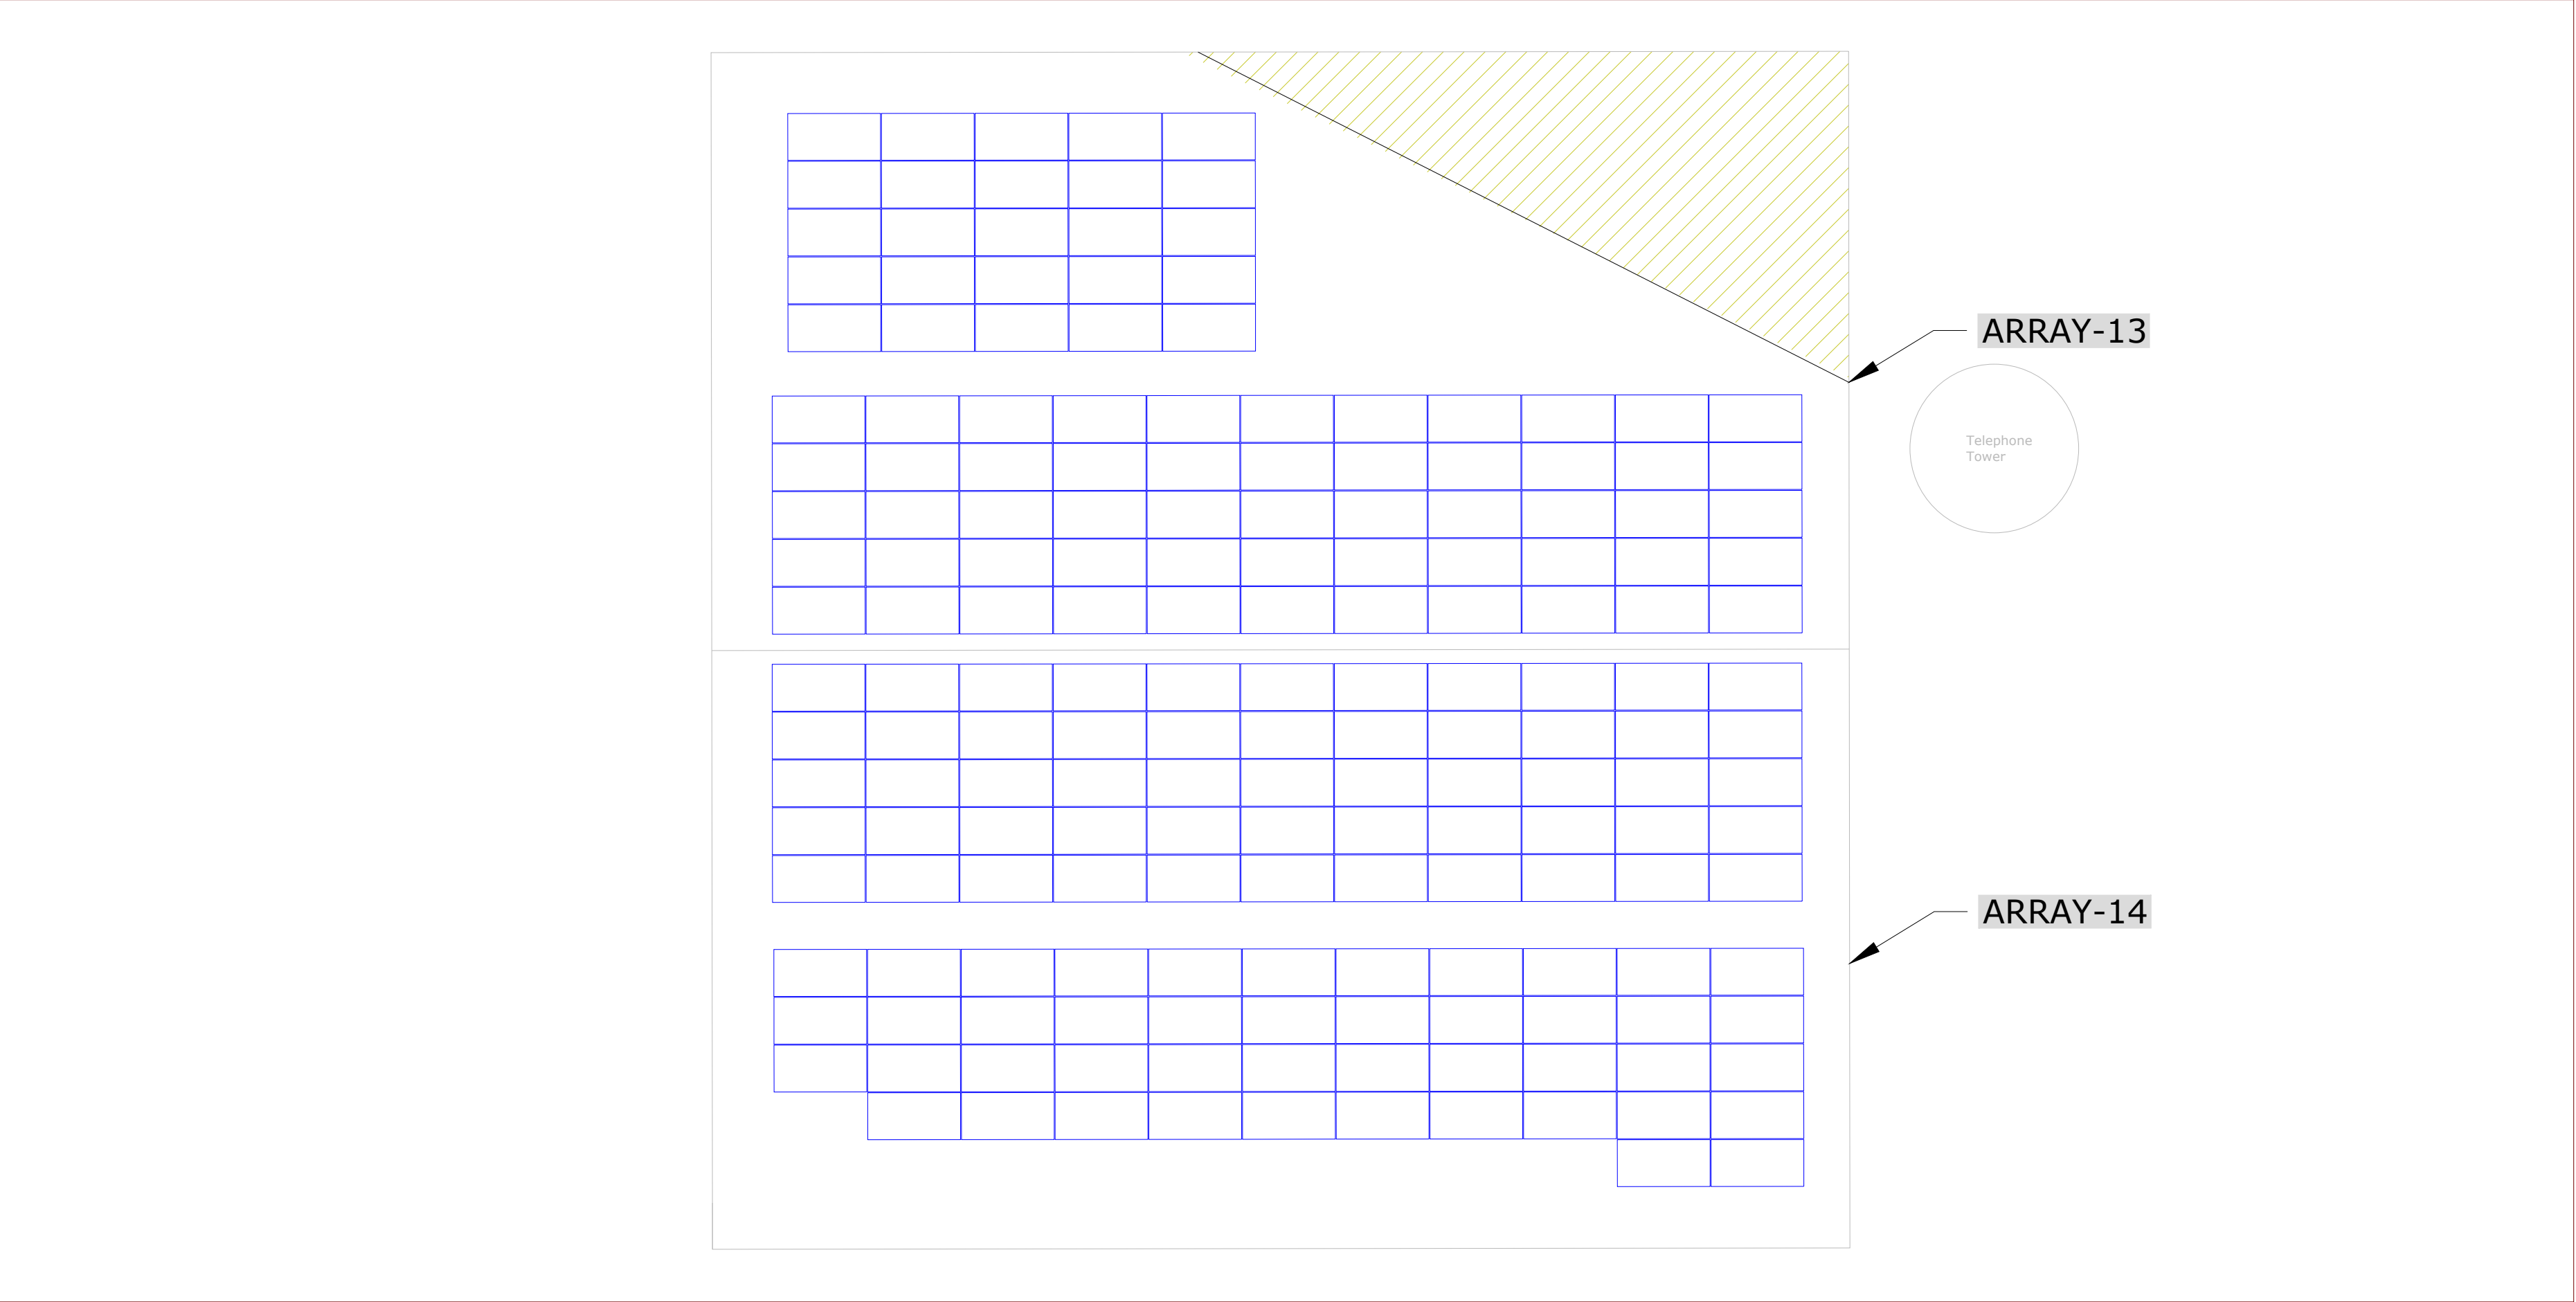

PROJECT DEVELOPER

PROJECT CO-DEVELOPER



PROJECT ADDRESS

KRSG
BENGALURU


SINGLE LINE DIAGRAM ARRAY (1 & 2)

ISSUED FOR
APPROVAL

[illegible]

ISSUED FOR
APPROVAL



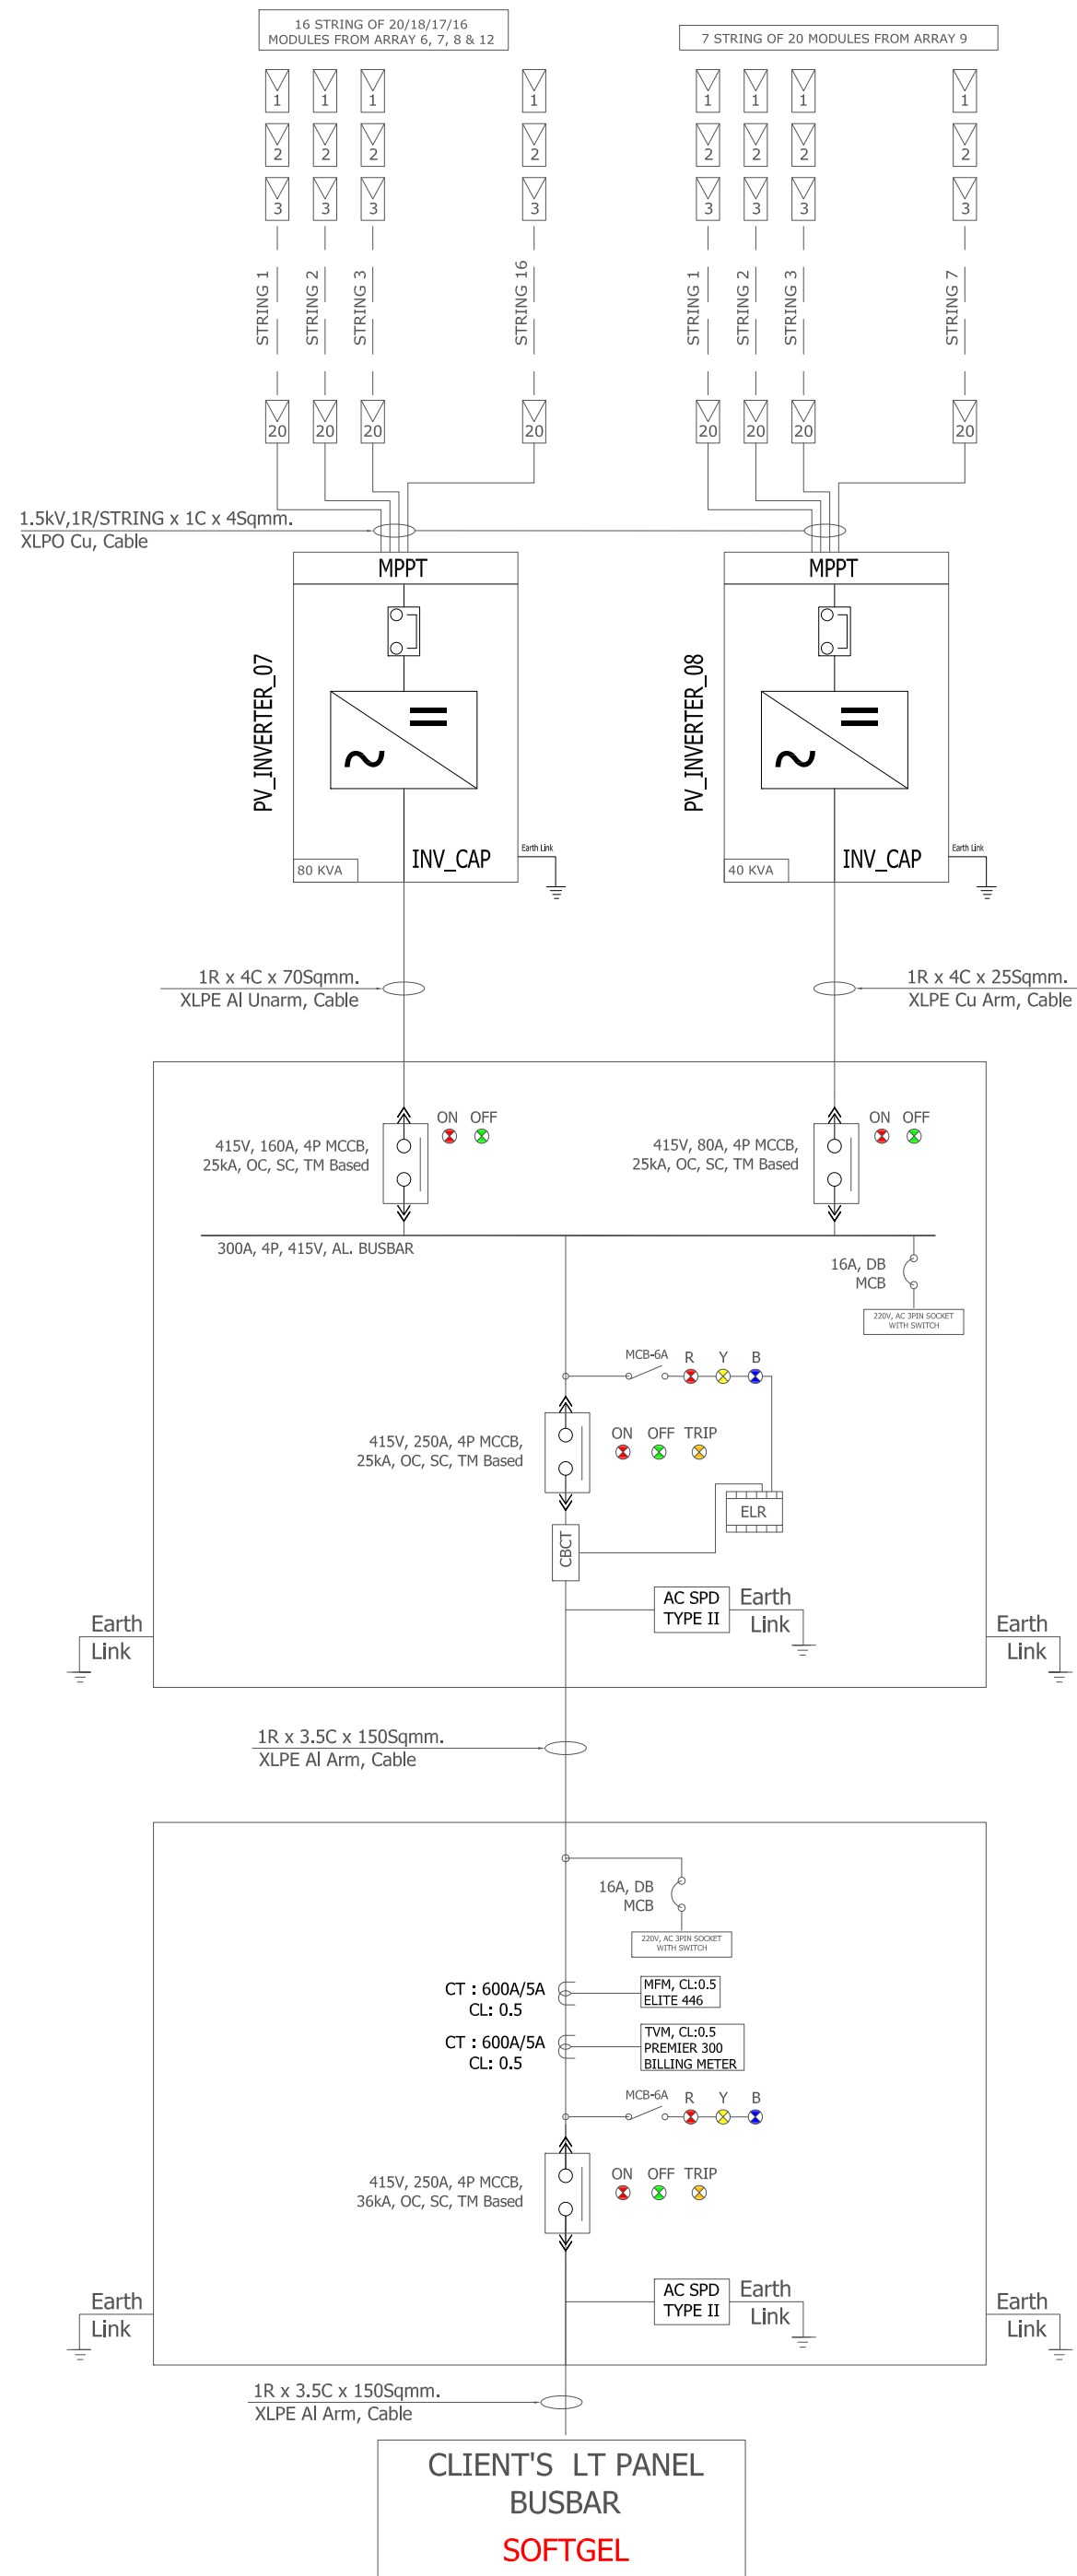

PROJECT DEVELOPER



An SHV Energy Company

SunSource Square, Tower A, 5th Floor
Club 125, Sector 125, Noida - 201301
email: contact@sunsorce-energy.com
Ph: +91 8130033213
www.sunsorce-energy.com

PROJECT CO-DEVELOPER



H-12, 1st FLOOR SECTOR 9, NOIDA,
UTTAR PRADESH, 201301

PROJECT NAME

Stride Pharma

PROJECT ADDRESS

KRSG
BENGALURU

SINGLE LINE DIAGRAM ARRAY (6 to 9 & 12)

REVISION HISTORY

REV	DESCRIPTION	DRW	CHK	
0	DRAFT REVIEW	VS	VA	01/06/2022
1	CAPACITY REVISED	VS	VA	03/06/2022

PROJECT NUMBER

PAGE SIZE

A3

SHEET NUMBER

SCALE

30

NTS

DISC.


DWG NO.

SEQUENCE

SUPP.

E-1

ISSUED FOR
APPROVAL

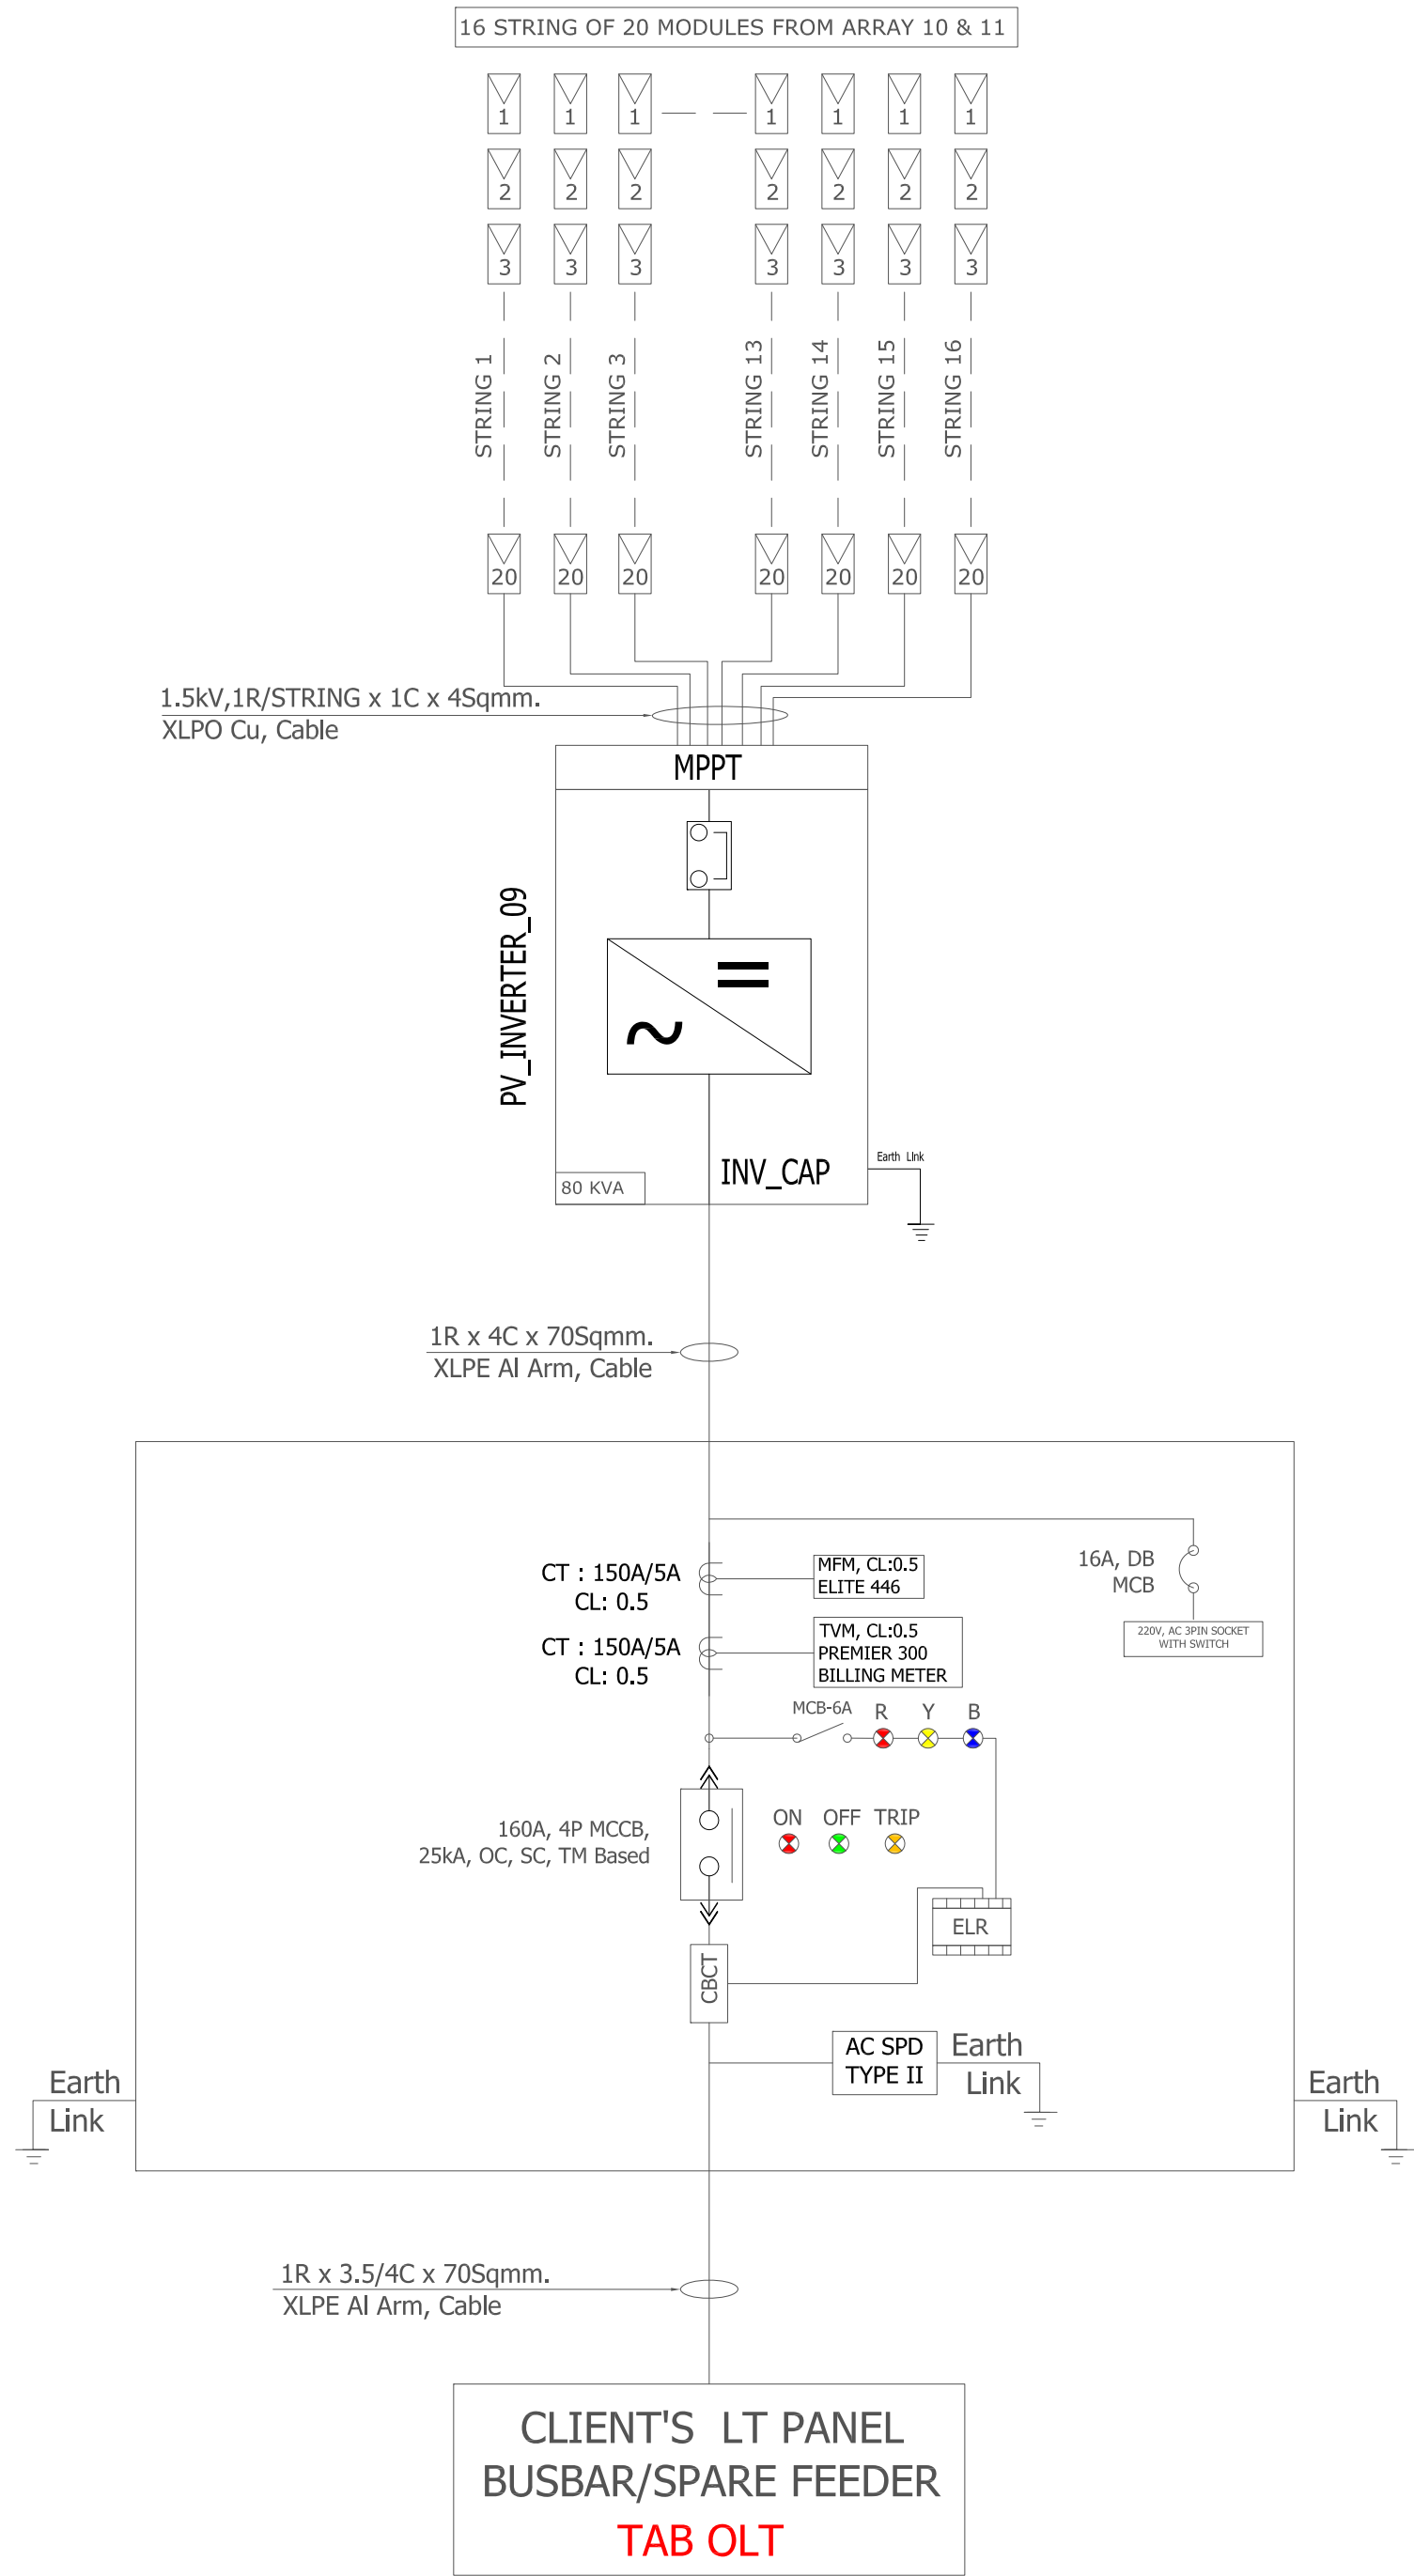

PROJECT DEVELOPER



An SHV Energy Company

SunSource Square, Tower A, 5th Floor
Club 125, Sector 125, Noida - 201301
email: contact@sunsorce-energy.com
Ph: +91 8130033213
www.sunsorce-energy.com

PROJECT CO-DEVELOPER



H-12, 1st FLOOR SECTOR 9, NOIDA,
UTTAR PRADESH, 201301

PROJECT NAME

Stride Pharma

PROJECT ADDRESS


KRSG
BENGALURU

SINGLE LINE DIAGRAM ARRAY (10 & 11)

REVISION HISTORY				
REV	DESCRIPTION	DRW	CHK	
0	DRAFT REVIEW	VS	VA	01/06/2022
1	CAPACITY REVISED	VS	VA	03/06/2022

PROJECT NUMBER			PAGE SIZE
			A3
SHEET NUMBER		SCALE	
31		NTS	
DISC.	DWG NO.	SEQUENCE	SUPP.
	E-1		

ISSUED FOR
APPROVAL

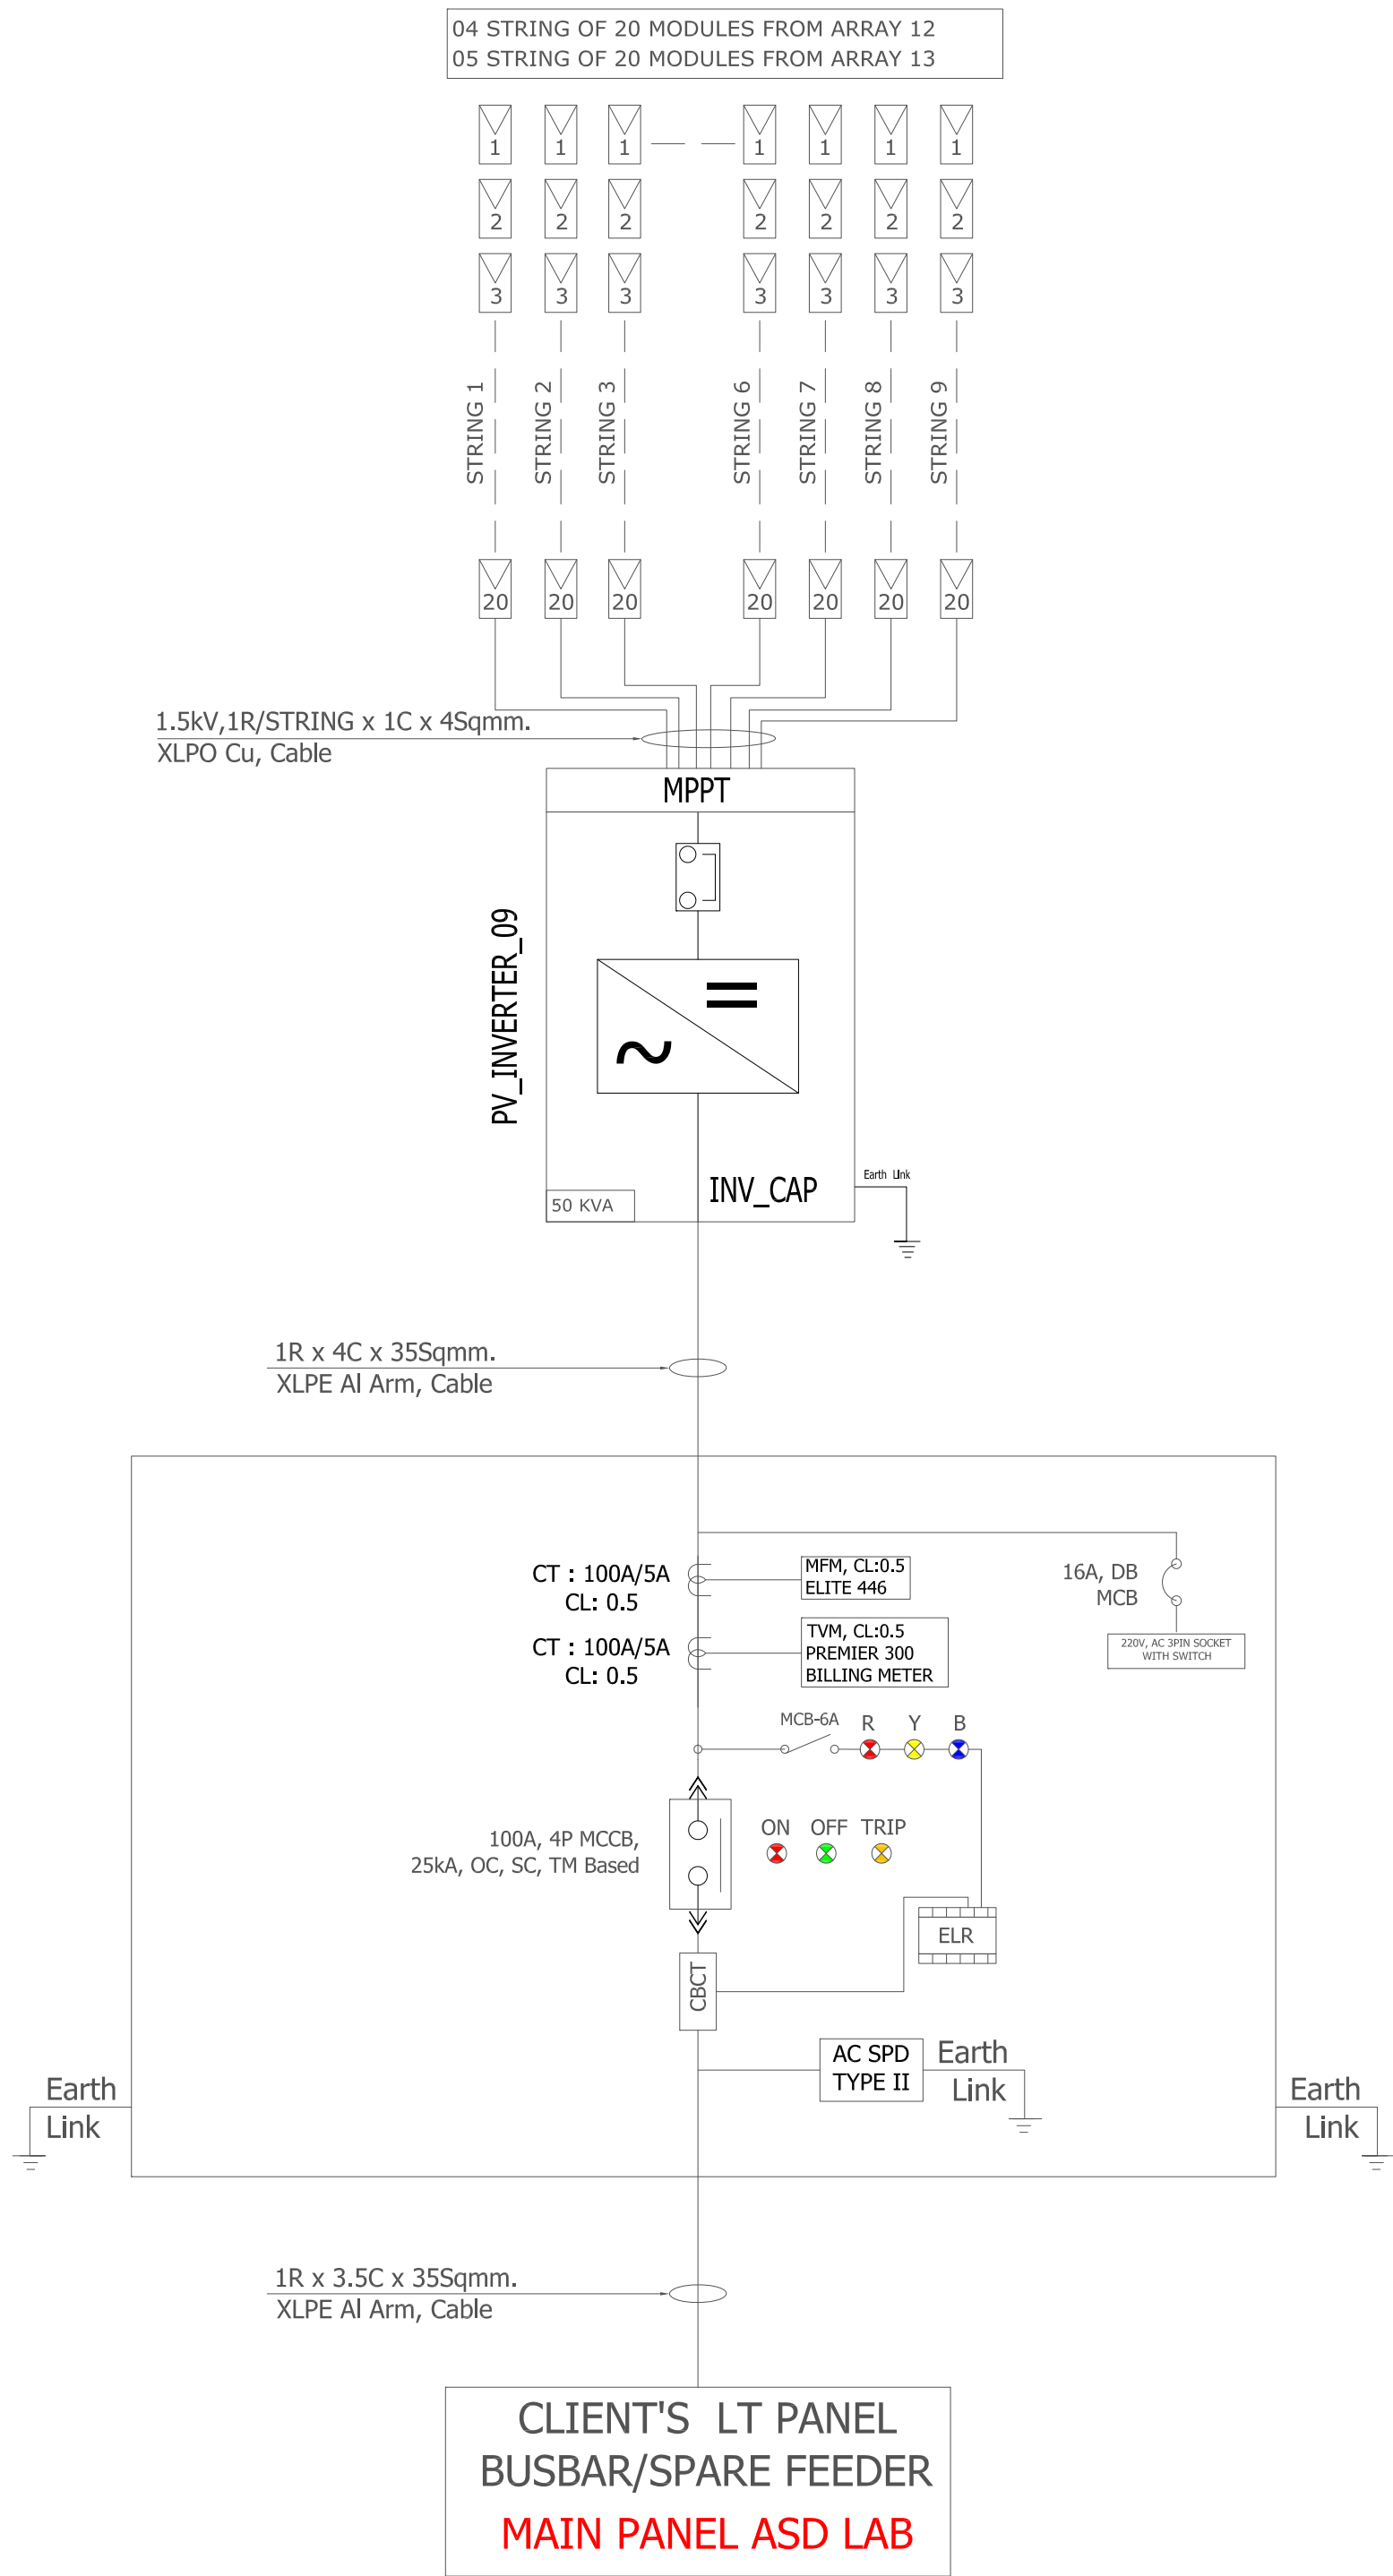

PROJECT DEVELOPER



An SHV Energy Company

SunSource Square, Tower A, 5th Floor
Club 125, Sector 125, Noida - 201301
email: contact@sunsorce-energy.com
Ph: +91 8130033213
www.sunsorce-energy.com

PROJECT CO-DEVELOPER



H-12, 1st FLOOR SECTOR 9, NOIDA,
UTTAR PRADESH, 201301

PROJECT NAME

Stride Pharma

PROJECT ADDRESS

KRSG
BENGALURU

SINGLE LINE DIAGRAM ARRAY (13 & 14)

REVISION HISTORY

REV	DESCRIPTION	DRW	CHK	
0	DRAFT REVIEW	VS	VA	01/06/2022
1	CAPACITY REVISED	VS	VA	03/06/2022

PROJECT NUMBER

PAGE SIZE

A3

SHEET NUMBER

32

SCALE

NTS

DISC.

DWG NO.

SEQUENCE

SUPP.

E-1

ISSUED FOR
APPROVAL