
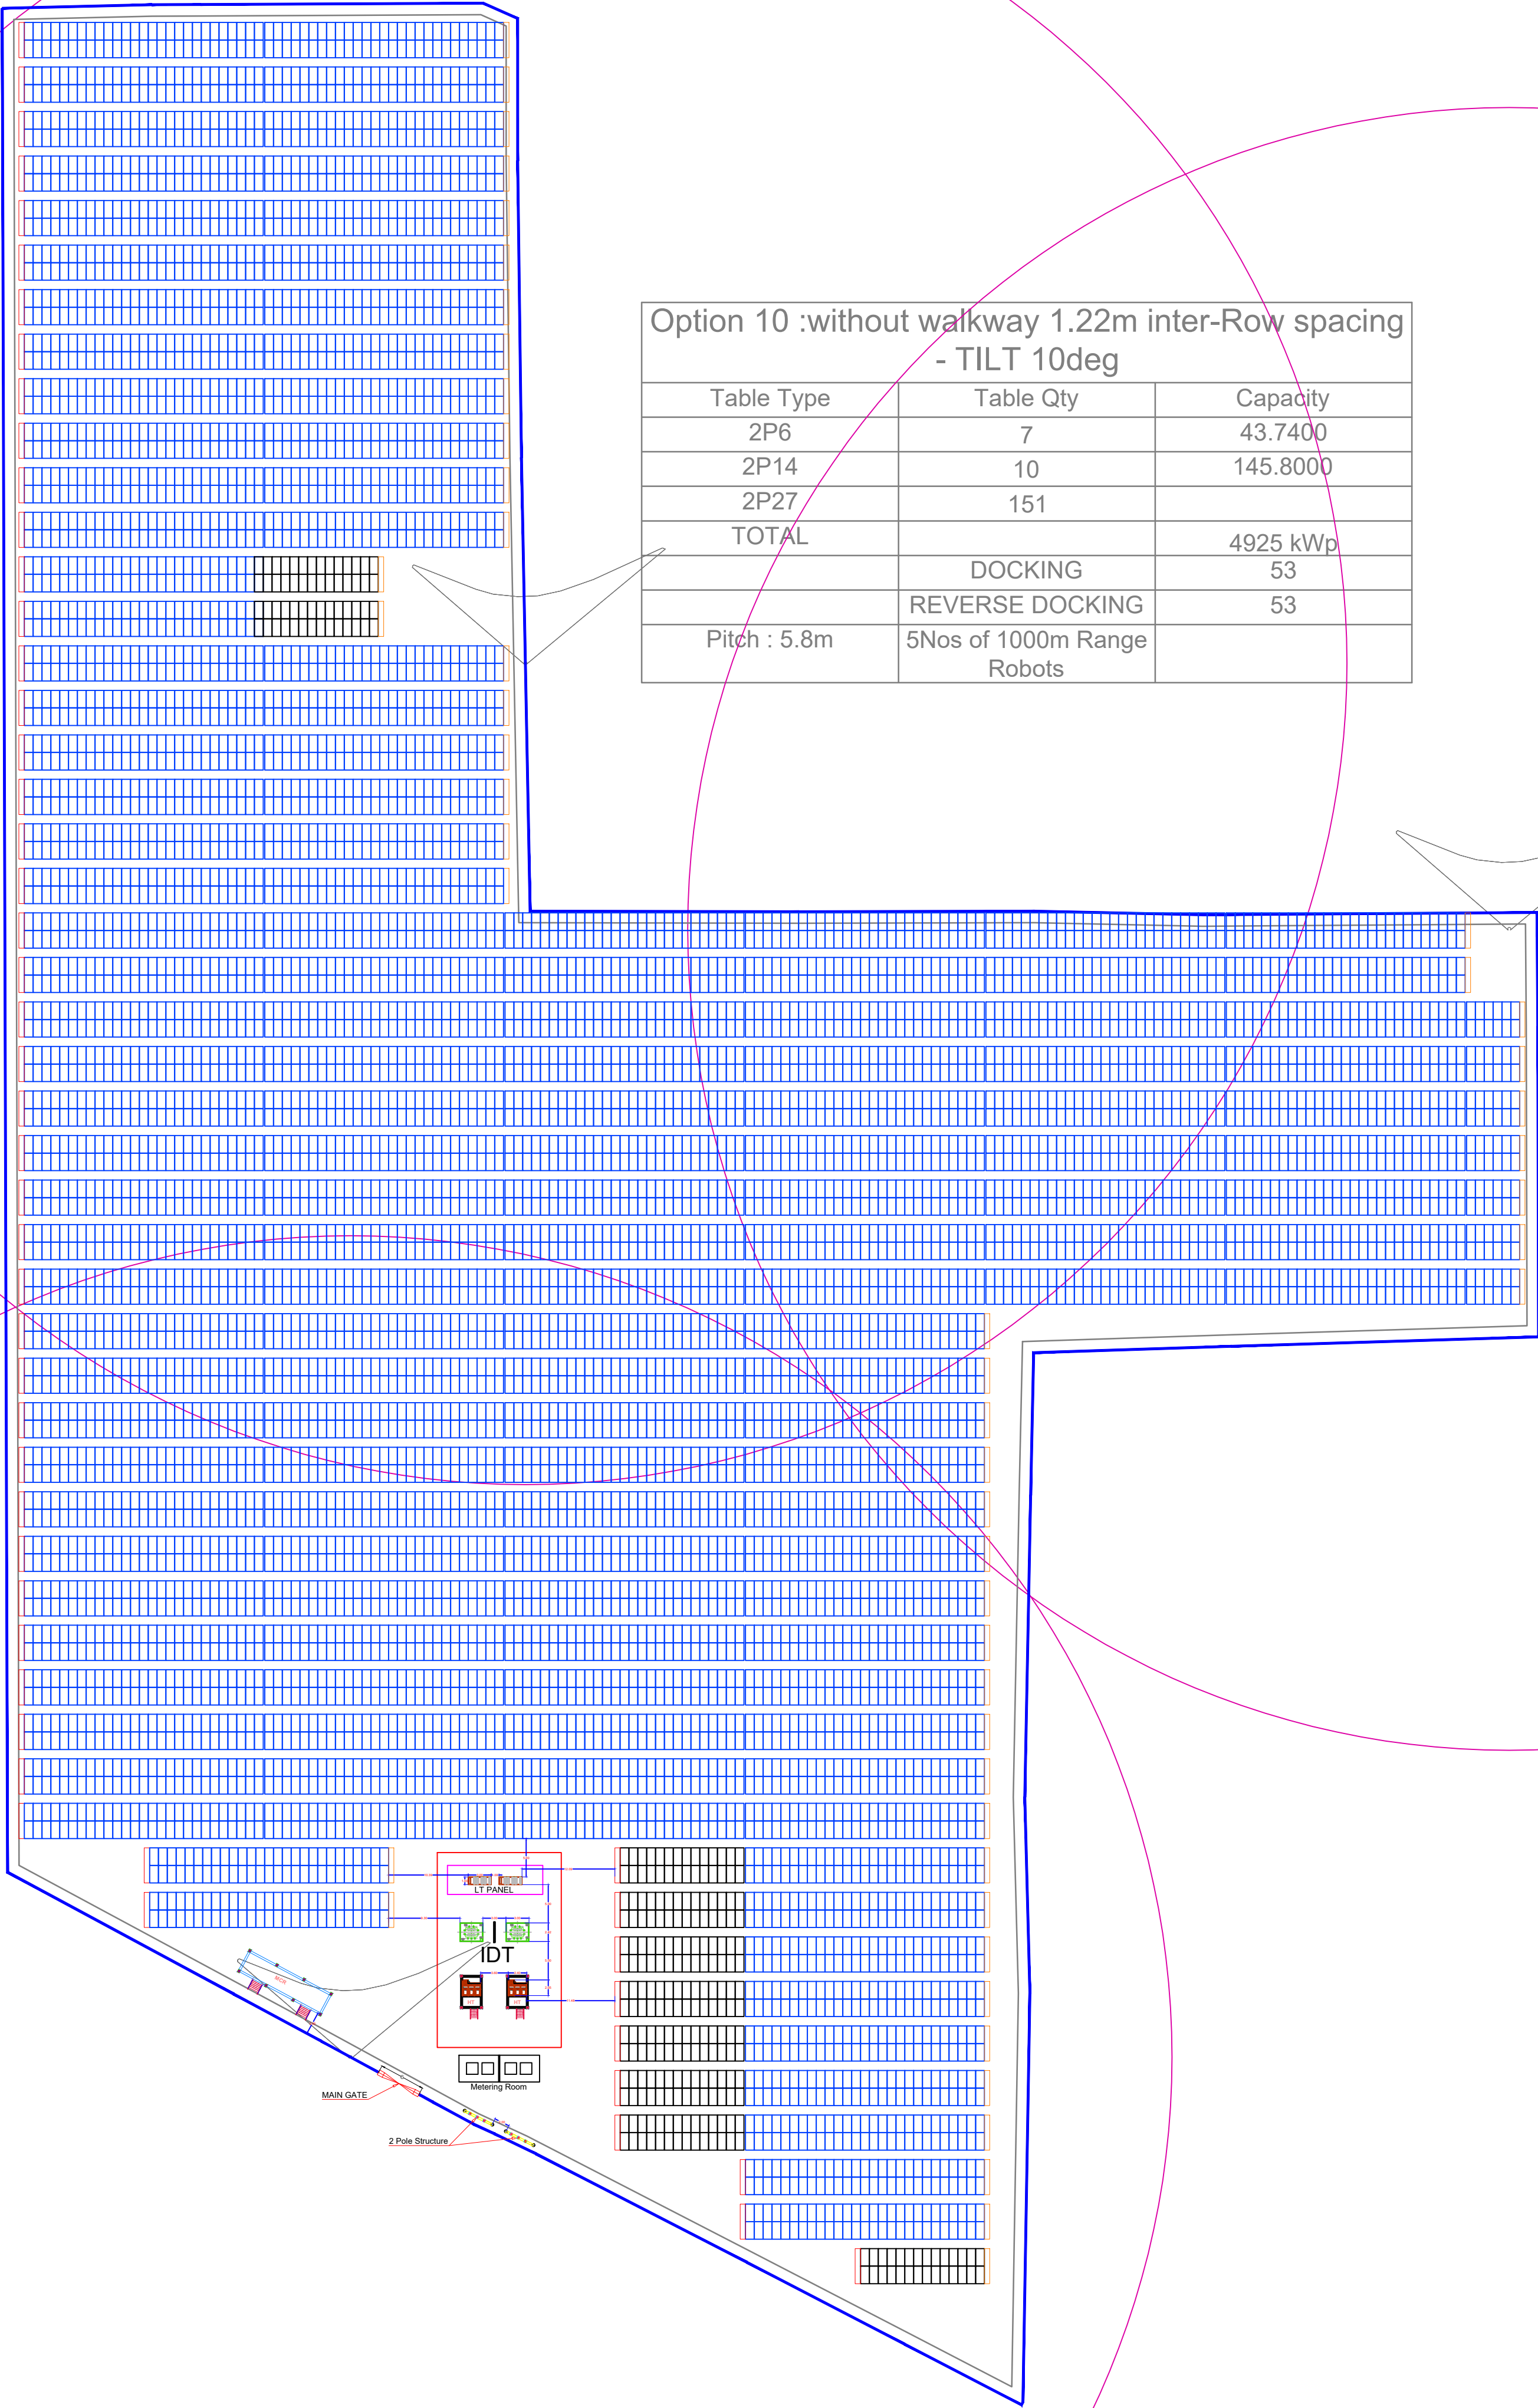


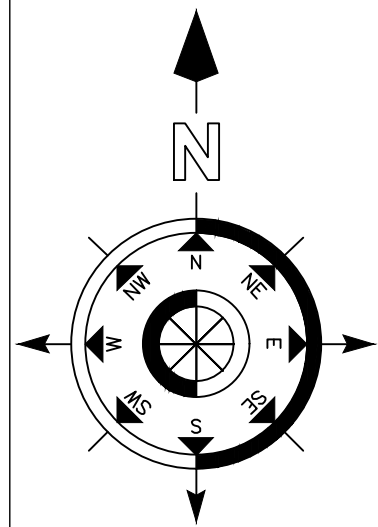

Option 10 :without walkway 1.22m inter-Row spacing - TILT 10deg		
Table Type	Table Qty	Capacity
2P6	7	43.7400
2P14	10	145.8000
2P27	151	
TOTAL		4925 kWp
	DOCKING	53
	REVERSE DOCKING	53
Pitch : 5.8m	5Nos of 1000m Range Robots	

- NOTES :-**
- 1. ALL DIMENSION ARE IN METER.
 - 2. MINOR CHANGES MAY TAKE PLACE ACCORDING TO SITE CONDITION.

PLANT DETAILS:

Sr.No.	DESCRIPTION	DETAIL
1	MODULE RATING	545 Wp
2	TOTAL DC CAPACITY	4925 kWp
3	TOTAL AC CAPACITY	3835 kW
4	PITCH	5.8 Meter
5	TILT	10°

Sr.No	LEGENDS	DISCRIPTION
1		PV MODULE
2		DOCKING STATION
3		REVERSE DOCKING STATION

REV	DATE	DESCRIPTION
-----	------	-------------

PROJECT REVISION DETAILS	
PROJECT:-	4925 kWp SOLAR POWER PLANT, DELHI
CLIENT :	TALF ENERGY INDIA PVT. LTD.

DRAWING ISSUED FOR:

AS BUILT ☐ APPROVAL ☒ INFORMATION ☐ PROPOSAL ☐

DRWG. TITLE :	PV ARRAY LAYOUT	DATE 25-Nov-22
		REVISION R00
DRWG. No. :		SCALE NTS
		SHEET NO. 01 OF 01