


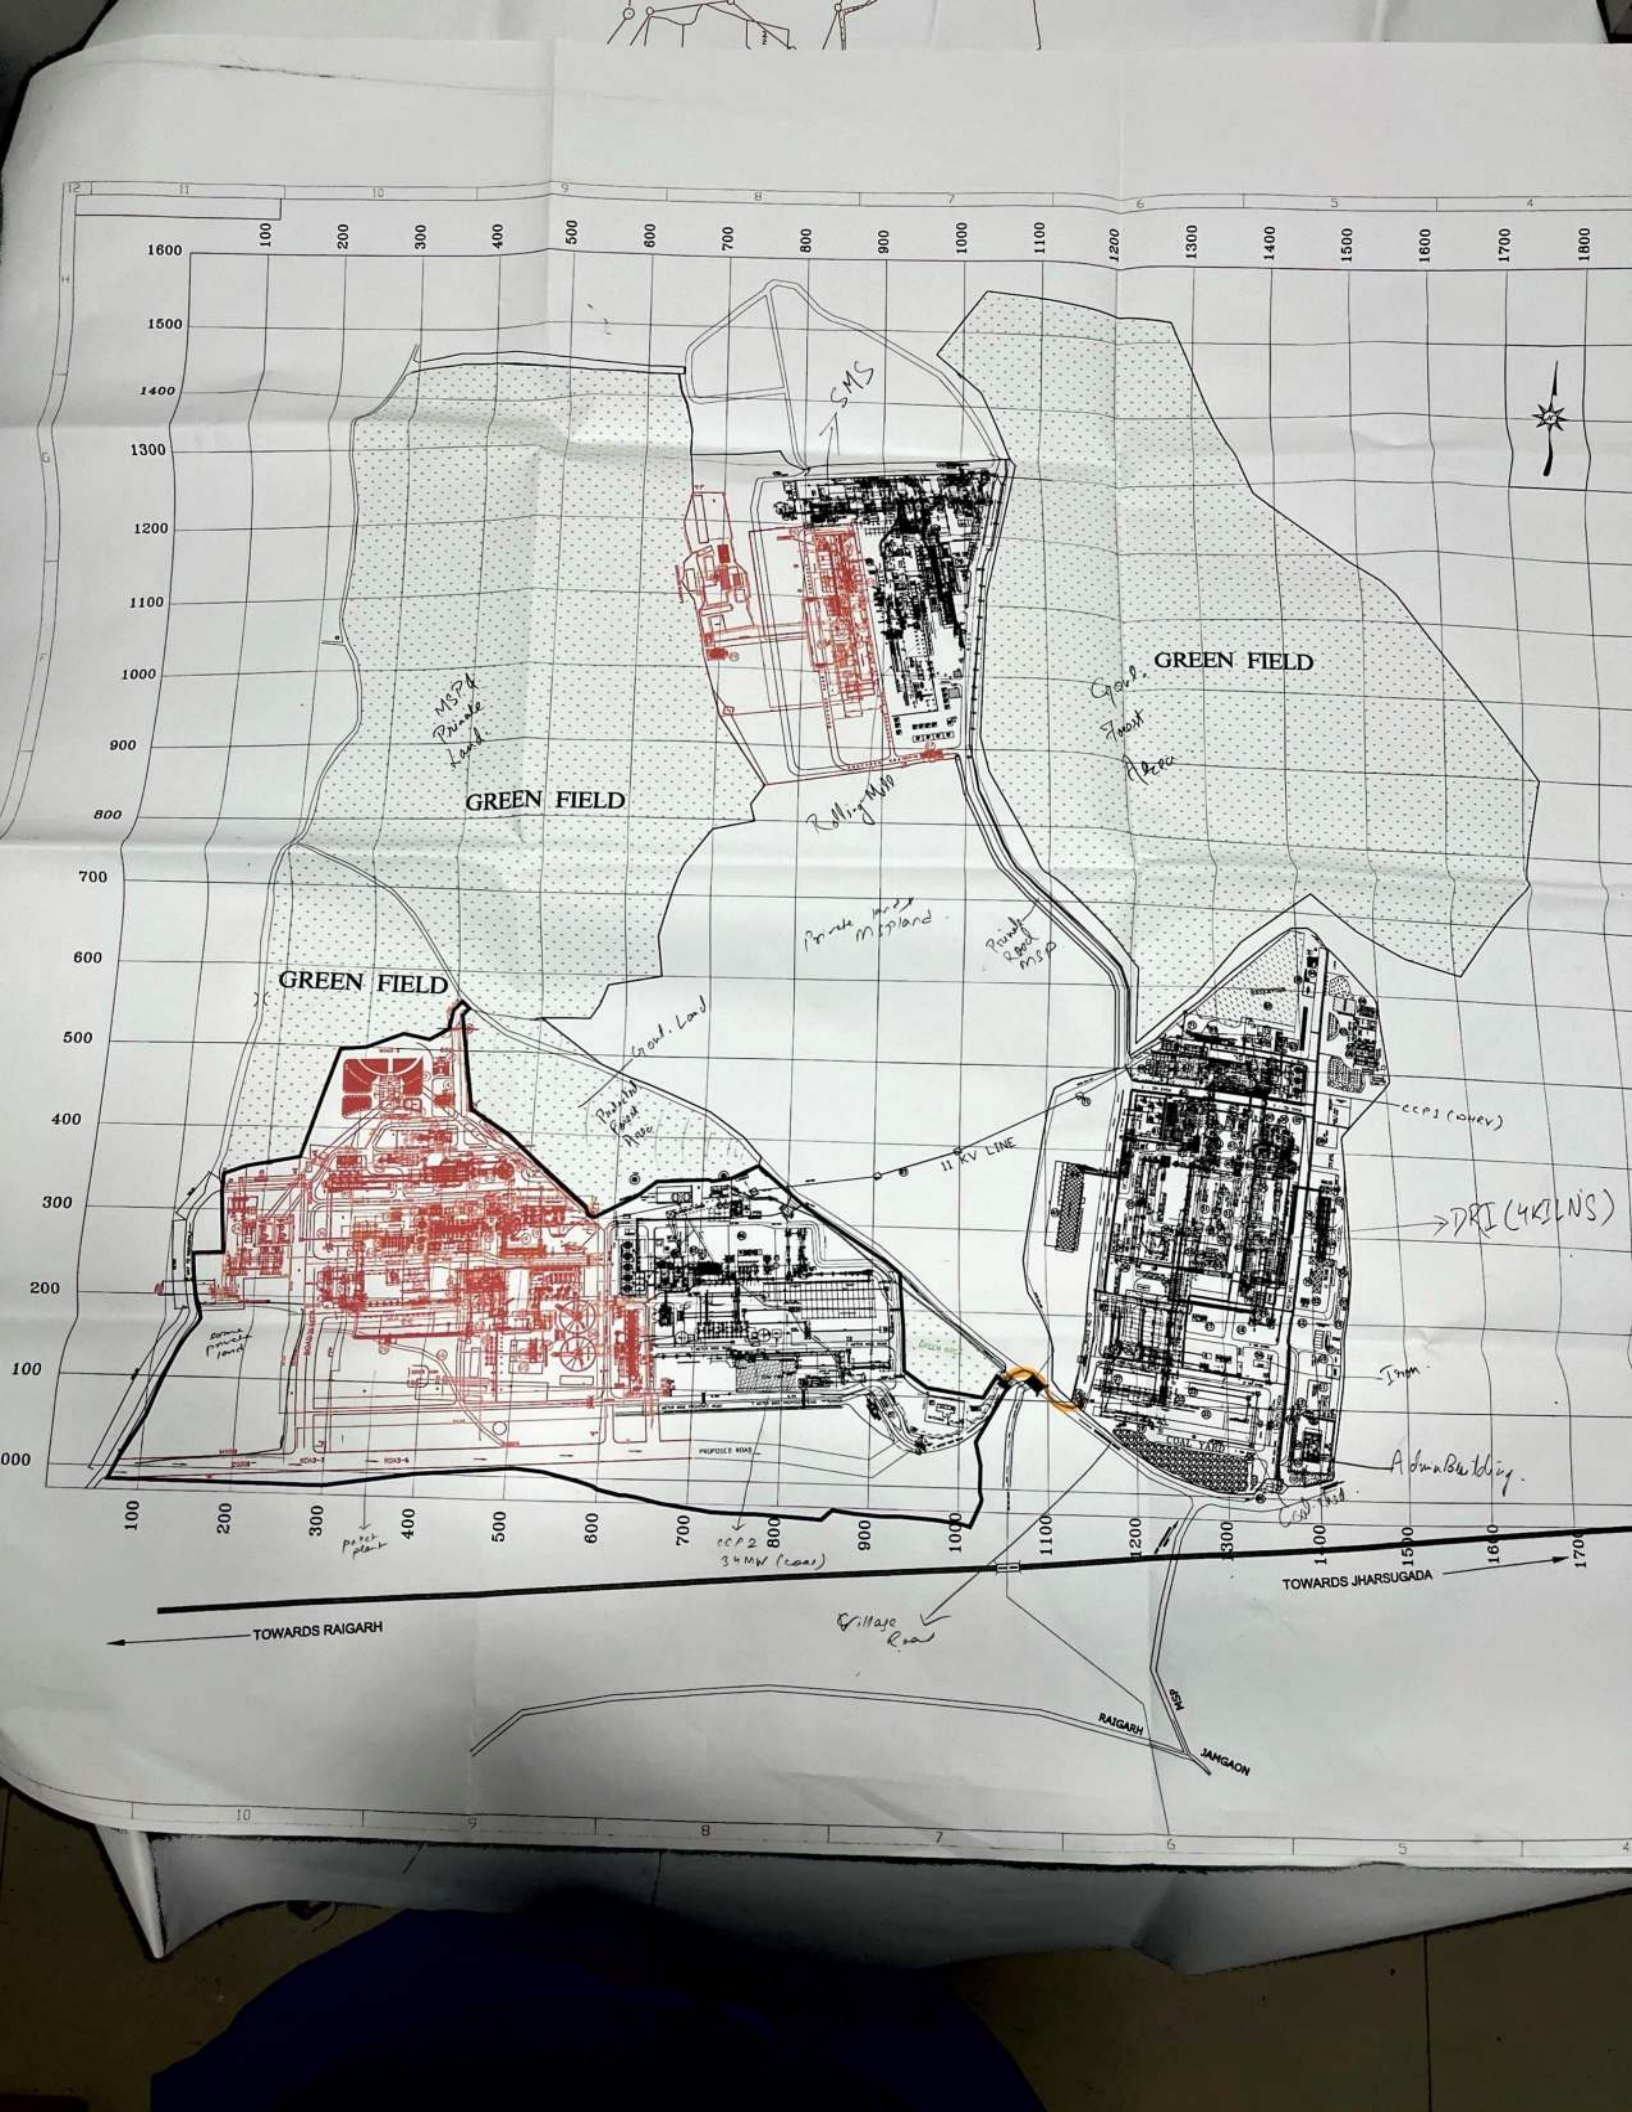

LEGEND OF MSPSPL		LEGEND OF MSPSPL UNIT -2	
S.N.	DESCRIPTION	S. N.	DESCRIPTION
1	MAIN GATE	1	MAIN GATE
2	ADM BUILDING	2	SECURITY OFFICE
3	GUEST HOUSE	3	VEHICLE STAND
4	WEIGH BRIDGE (FINISH GOODS)	4	CANTEEN
5	VEHICLE STAND	5	OFFICE
6	CANTEEN	6	CONTROL ROOM
7	AUTOMOBILE AREA	7	WEIGH BRIDGE
8	FIRST AID CENTRE	8	P1 - MAIN PELLET BUILDING
9	WORK SHOP	9	P1 - CENTRAL CONTROL ROOM
10	OPEN YARD - STORE	10	P1 - CHIMNEY
11	STORE	11	P1 - ID FAN
12	CEMENT SHED	12	P1 - TRAVELLING GRATE
13	TEMP ACCOMMODATION	13	P1 - COOLING TOWER
14	WEIGH BRIDGE (INCOMING GOODS)	14	P1 - COOLER
15	CONTROL ROOM (WB)	15	P1 - ESP
16	GATE NO- 2	16	OIL TANK
17	STORAGE YARD-1 /ORE	17	PRODUCER GAS PLANT
18	STORAGE YARD-2 /ORE	18	TAR TANK
19	STORAGE YARD-3 - COAL	19	BAG FILTER
20	STORAGE YARD-4 (COAL)	20	P1 - BENEFICATION BUILDING
21	COAL SHED	21	P1 - THICKNER
22	GROUND HOPPER -1	22	DAY BIN
23	GROUND HOPPER -2	23	PUMP HOUSE
24	SCREEN HOUSE	24	P1 - SHED HIGH ORE CONCENTRATE
25	MCC 5 (RMP)	25	P1 - SHED FILTER CAKE
26	CRUSHER HOUSE -1	26	GROUND HOPPER (TRUCK TIPPLER)
27	CRUSHER HOUSE -2	27	P2 - PRES. FILTER BUILDING
28	DAY BINS	28	P1 - PRES. FILTER BUILDING
29	TRANSFER HOUSE	29	P2 - THICKNER 1 & 2
30	CHIMNEY	30	P2 - BENEFICATION BUILDING
31	KILN 1 & 2	31	P1 - TRUSTLE HOUSE 1A
32	KILN COOLER	32	P1 - TRUSTLE HOUSE 1
33	TRANSFER HOUSE 1 & 2	33	P1 - TRUSTLE HOUSE 2
34	COOLER 1 & 2	34	11 KV/132 KV SWITCHYARD
35	INTERMEDIATE STORAGE BIN	35	P1 - KILN
36	PRODUCT SAPERATION BUILDING	36	11 KV LINE
37	PRODUCT BINS	37	P2 - FILTER CAKE BIN
38	MCC -6 (PRODUCT HANDLING)	38	P2 - MIXTURE BUILDING
39	STORAGE BIN FOR DOLOCHAR	39	P2 - DRYER
40	PRODUCT SHED	40	P2 - GRANULATION BUILDING
41	AFTER BURNING CHAMBERS 1 & 2	41	P2 - TRAVELLING GRATE
42	WHRB 1 & 2	42	P2 - KILN
43	CHIMNEY	43	P2 - COOLER
44	E S P. 1 & ESP-2	44	P2 - ESP
45	PNEUMATIC CONVEYING SYSTEM	45	ID. FAN - 1 & ID. FAN 2
46	BELT PRESS SHED	46	P2 - CHIMNEY
47	BELT PRESS	47	P2 - PUMP HOUSE
48	CONTROLL ROOM /MCC	48	PCI UNIT
49	DG ROOM	49	COAL YARD
50	WATER STORAGE TANK	50	AIR COMP. HOUSE
51	WATER PUMPS	51	PGP -2
52	COMPRESSOR HOUSE	52	MCC ROOM
53	OIL TANK	53	TAR SETTLING PIT
54	WATER STORAGE (INTECK)	54	STAFF QUATER
55	SUBMERSIBLE PUMP-1	55	PRODUCT HOPPER
56	SUBMERSIBLE PUMP-2	56	HR FAN 1 & 2
57	DOLOMITE STORAGE	57	CLARIFIED WATER TANK
58	PROPOSED AFBC BOILER	58	PULVERISER
59	ESP	59	SCREEN HOUSE
60	STACK	60	MULTICYCLONE
61	T.G. HOUSE	61	BENTONITE SHED
62	COOLING TOWER -1	62	MDR BLD
63	I.D. FAN	63	BATHROOM-TOILET BLOCK
64	MECH. WORKSHOP	64	GROUND HOPPER
65	DM PLANT	65	MIXED FINES YARD
66	RESERVOIR (PHASE-I)	66	HIGH MASS TOWER
67	R.M. HANDLING SYSTEM FOR FBC BOILER	67	WORK SHOP
68	COAL WASHER (PROPOSED)	68	ROLL STARTING AREA
69	ROLLING MILL	69	STORE
70	STEEL MELTING SHOP	70	CONTROL ROOM
71	PRODUCT HOUSE	71 A	MAIN DRIVE
72	11 KV TRANSMISSION STRUCTURE	71 B	MAIN DRIVE
73	R.M. FEEDING SYSTEM FOR FBC BOILER	71 C	MAIN DRIVE
74	MCC & CONTROL ROOM FOR BOILER	71 D	MAIN DRIVE
75	KILN 3 & 4	71 E	MAIN DRIVE
76	SMS FURNACE	72	COOLING BED
77	STRUCTURE MILL	73	MCC ROOM
78	WHRB 3 & 4	74 A	SKEW TABLE
79	DAYBIN	74 B	SKEW TABLE
80	HOPPER	75	TILTING TABLE
81	ESP	76	EJECTOR
82	AFBC BOILER	77	PUSHER
83	AFTER BURNING CHAMBERS 3 & 4	78	MCC WATER TANK
84	KILN COOLER TRANSFER HOUSE - 3 & 4	79	STARTING MACHINE
85	ID FAN	80	COOLING TOWER
86	OIL TANK	81	HOT SHAW
87	POWER PLANT	82	STACK YARD
88	11 KV LINE	83	CONTROL PANEL
89	AURTHUR T P	84	OFFICE
90	KILN-3	85	STRAIGHTENING MACHINE
91	WHRB-3	86	GASIFIER
92	ESP-3	87	WEIGH BRIDGE
93	ID FAN - 3	88	STAFF ROOM
94	TG	89	CANTEEN BUILDING
95	COOLING TOWER -3		
96	PTP		
97	EHS BUILDING		
98	HEALTH CENTRE EXPANSION		
99	CCM - 3 & 4		
100	FURNACE - 4C, 5C & 9C (20X3 MT)		
101	LRF		
102	POLLUTION CONTROL DEVICE		
103	BUCKET ELEVATOR		
104	FURNACE TRANSFORMER		
105	FURNACE COOLING TOWER		
106	FURNACE FEEDING HOPPER		
	CCM COOLING TOWER		
	TOILET		
	REST ROOM		

APPROVED MSPL

APPROVED UNIT 2

MSP

MSP STEEL & POWER LTD

VILLAGE & POST JAMGADN, DISTT. RAIGARH, (CHHATTISGARH)

DRAWN: CKP
CHECKED: ARPIT SINGH
APPROVED: B.K. SINGH
DATE: 11.12.23

TITLE: APPROVED MSPSPL & APPROVED UNIT -2



SCALE - 1 : 500

DRG. NO.

APP.MSPSPL&U2

REV
R0