


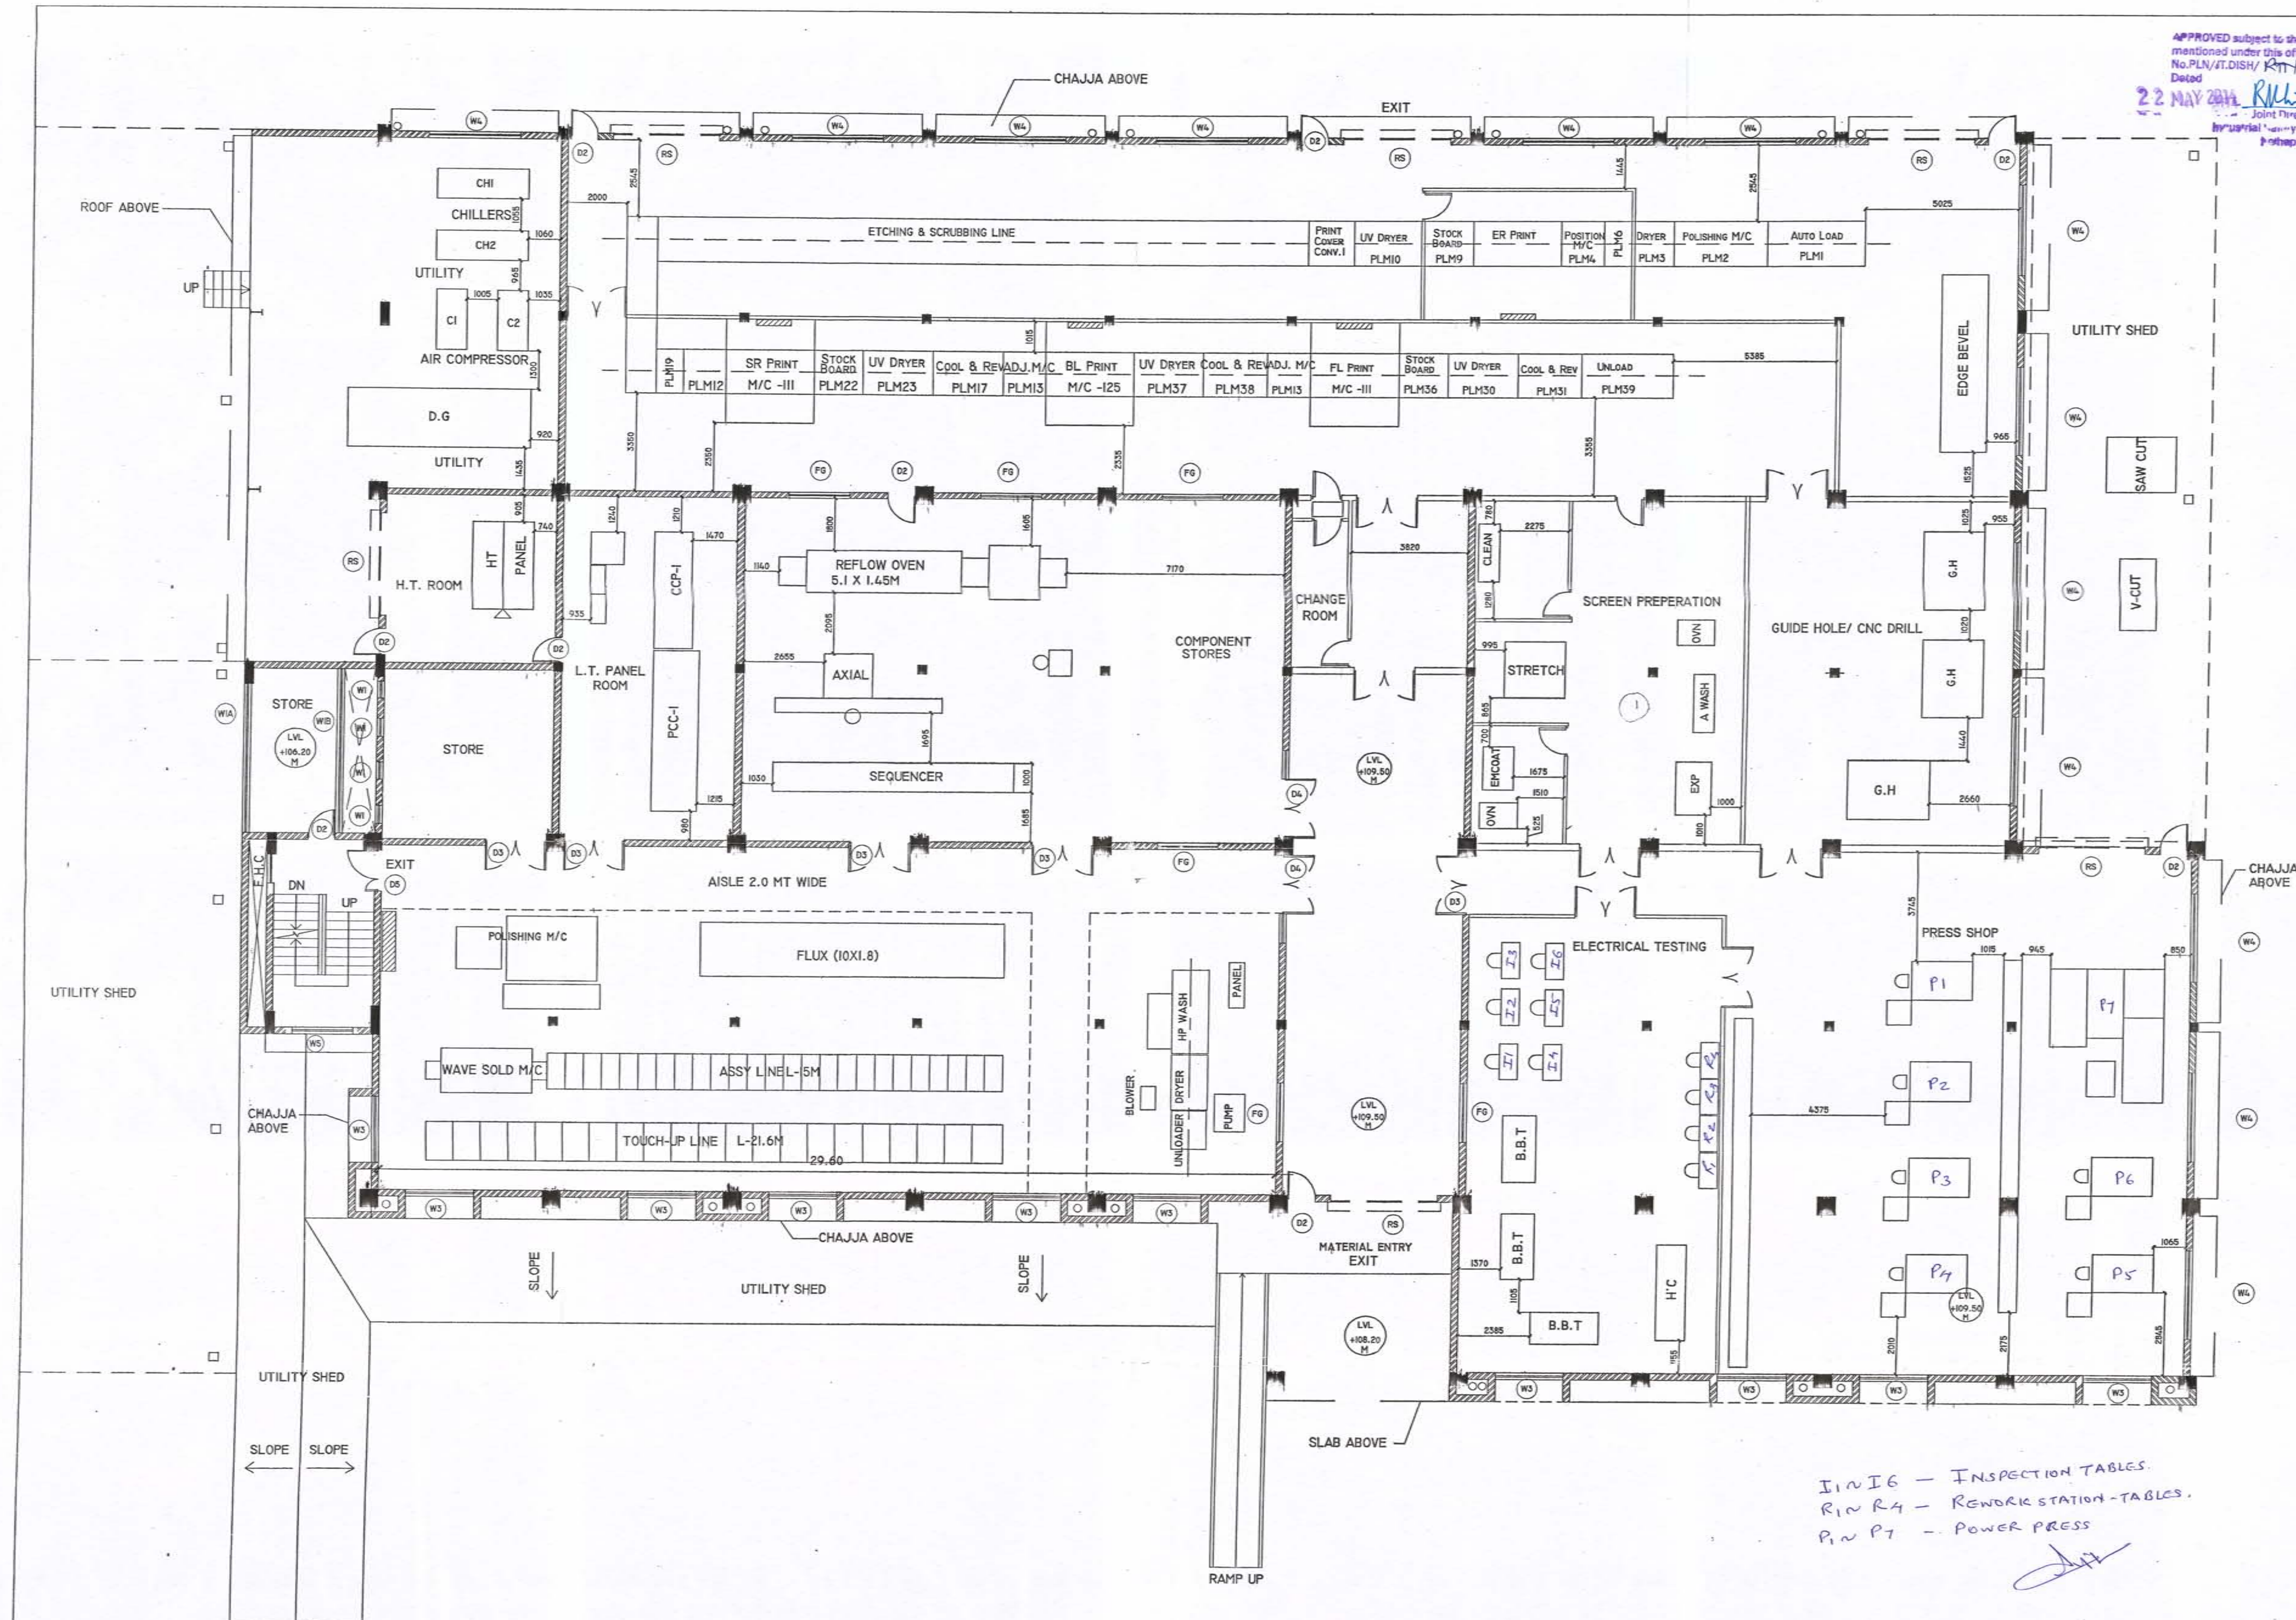

APPROVED subject to the conditions mentioned under this office letter No. PLN/IT.DISH/ RIT-22/2018/NTM/REC/1985/2014  
 Dated 22 MAY 2018  
 Joint Director  
 Industrial Safety and Health  
 Pothapur.

|                                                                                                                                                                     |          |       |          |     |
|---------------------------------------------------------------------------------------------------------------------------------------------------------------------|----------|-------|----------|-----|
| PERFORMA - B                                                                                                                                                        |          |       |          |     |
| CONTENTS OF SHEET                                                                                                                                                   |          |       |          |     |
| * GROUND FLOOR PLAN                                                                                                                                                 |          |       |          |     |
| STAMP OF DATE OF RECEIPT. OF PLAN                                                                                                                                   |          |       |          |     |
| STAMP OF DATE OF APPROVAL OF PLAN                                                                                                                                   |          |       |          |     |
| DESCRIPTION OF PROPOSAL                                                                                                                                             |          |       |          |     |
| PROPOSED SCHEME FOR FACTORY BUILDING OF AKASAKA ELECTRONICS ON PLOT BEARING NUMBER G-1, MIDC, LOTE PARSHURAM INDUSTRIAL ESTATE, TALUKA - KHED, DISTRICT - RATNAGIRI |          |       |          |     |
| JOB NO.                                                                                                                                                             | DRG. NO. | SCALE | DATE     | DRN |
|                                                                                                                                                                     | F-3      | 1:100 | 29-09-13 |     |
| NAME AND SIGN. OF OWNER                                                                                                                                             |          |       |          |     |
| M/S AKASAKA ELECTRONICS LTD.                                                                                                                                        |          |       |          |     |
| For Akasaka Electronics Ltd.<br><i>[Signature]</i><br>Authorised Signatory                                                                                          |          |       |          |     |
| NAME OF THE ARCHITECT                                                                                                                                               |          |       |          |     |
| HADRIAN LOBO<br>ARCHITECTS, INTERIOR DESIGNERS<br>A-604, MERCURY, SUNCITY COMPLEX,<br>ADI SHANKARACHARYA MARG, POWAI,<br>MUMBAI 400 076                             |          |       |          |     |
| HADRIAN LOBO<br><i>[Signature]</i><br>A-604, MERCURY<br>SUNCITY COMPLEX<br>POWAI, MUMBAI 400076                                                                     |          |       |          |     |
| NAME OF THE STRUCTURAL CONSULTANT                                                                                                                                   |          |       |          |     |
| S.W. MONE & ASSOCIATES<br>CONSULTING ENGINEERS<br>3, SHAROP COMPLEX, 2ND FLOOR,<br>KARVE ROAD, PUNE 411 004                                                         |          |       |          |     |

INIG - INSPECTION TABLES.  
 RIN R4 - REWORK STATION-TABLES.  
 PIN P7 - POWER PRESS