


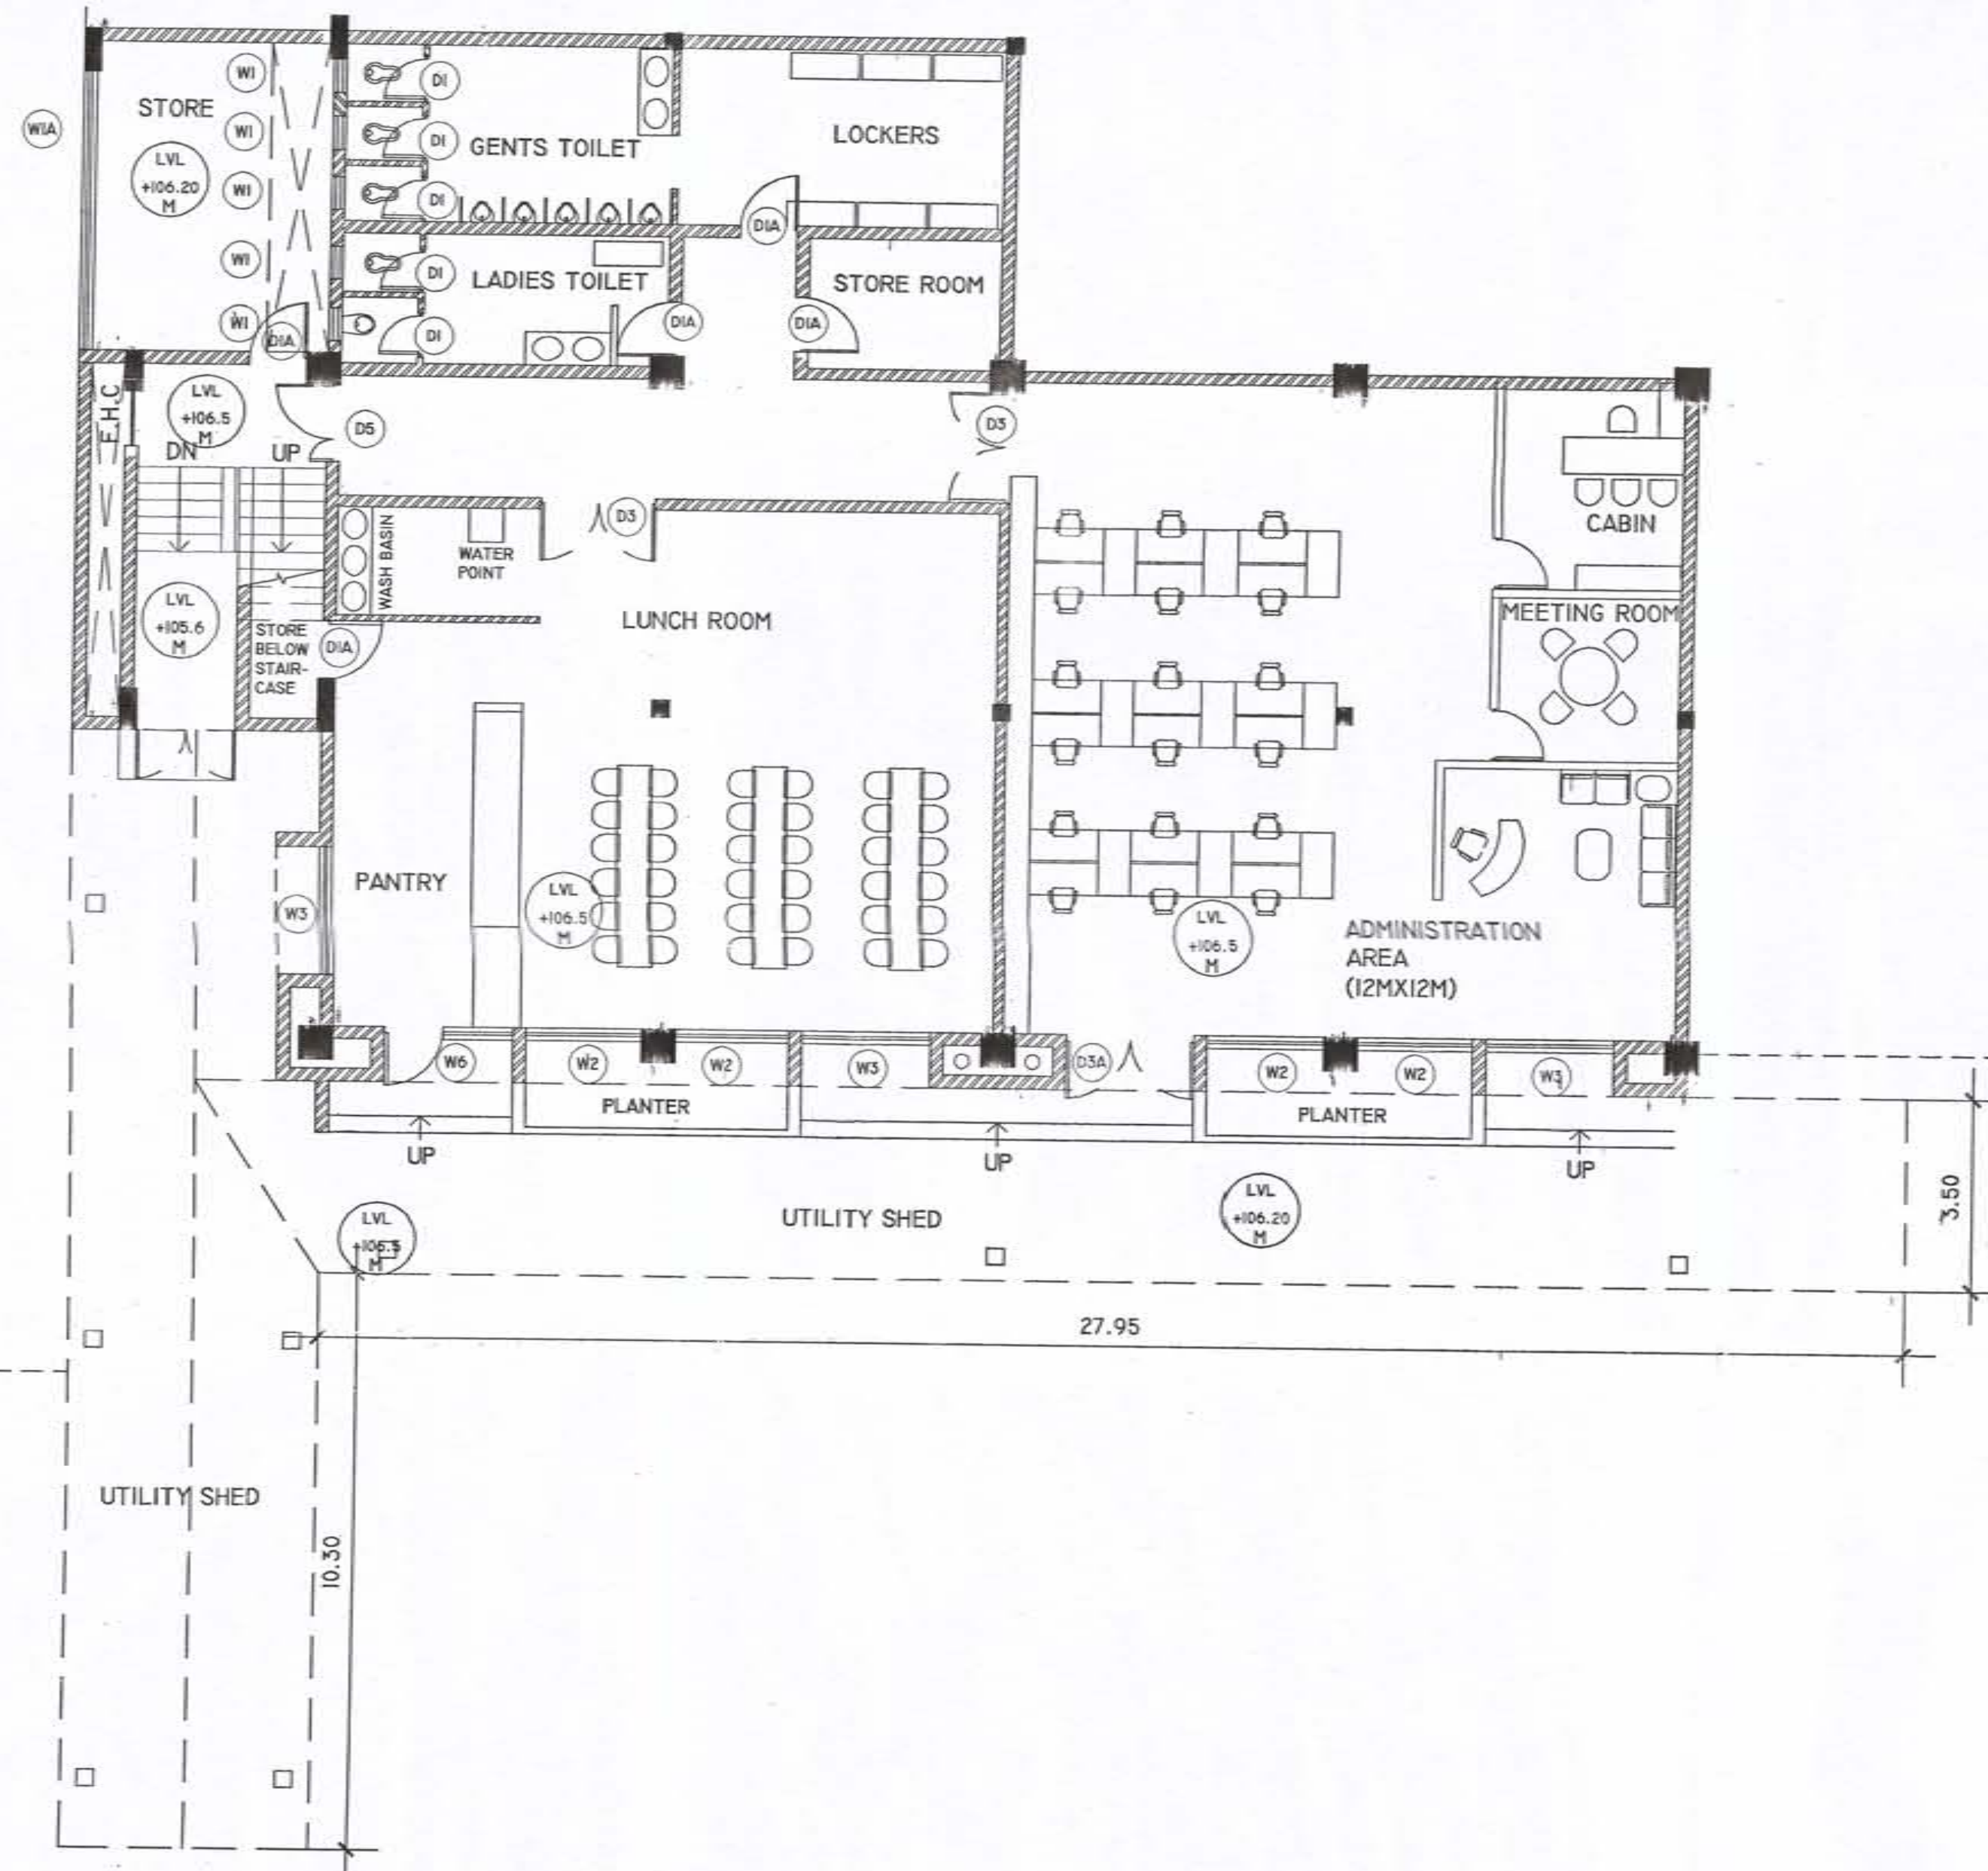

APPROVED subject to the conditions mentioned under this office letter
No. PLN/IT.DISH/RTN-22/2014/MTM/R64/1985/2014
Dated
22 MAY 2014
Joint Director
Municipal Health and Health
Inspector.

PERFORMA - B				
CONTENTS OF SHEET				
• LOWER GROUND FLOOR PLAN				
STAMP OF DATE OF RECEPT. OF PLAN				
STAMP OF DATE OF APPROVAL OF PLAN				
DESCRIPTION OF PROPOSAL				
PROPOSED SCHEME FOR FACTORY BUILDING OF AKASAKA ELECTRONICS ON PLOT BEARING NUMBER G-1, MIDC, LOTE PARSHURAM INDUSTRIAL ESTATE, TALUKA - KHED, DISTRICT - RATNAGIRI				
JOB NO.	DRG. NO.	SCALE	DATE	DRN
	F-2	1:100	29-09-13	
NAME AND SIGN. OF OWNER				
M/S AKASAKA ELECTRONICS LTD. For Akasaka Electronics Ltd. Authorised Signatory				
NAME OF THE ARCHITECT				
HADRIAN LOBO ARCHITECTS, INTERIOR DESIGNERS A-604, MERCURY, SUNCITY COMPLEX, ADI SHANKARACHARYA MARG, POWAI, MUMBAI 400 076 HADRIAN LOBO A-604, MERCURY SUNCITY COMPLEX POWAI, MUMBAI 400076				
NAME OF THE STRUCTURAL CONSULTANT				
S.W. MONE & ASSOCIATES CONSULTING ENGINEERS 3, SWAROOP COMPLEX, 2ND FLOOR, KARVE ROAD, PUNE 411 004				