


LEGENDS OF SITE PLAN	S. NO.	DESCRIPTION
1. NO. OF WORKERS	01	T.G. BUILDING
2. NO. OF WORKERS	02	SWITCH YARD
3. NO. OF WORKERS	03	ESP (ELECTRO STATIC PRECIPITATOR)
4. NO. OF WORKERS	04	CLAYERS
5. NO. OF WORKERS	05	CLAYERS
6. NO. OF WORKERS	06	CLAYERS
7. NO. OF WORKERS	07	CLAYERS
8. NO. OF WORKERS	08	CLAYERS
9. NO. OF WORKERS	09	CLAYERS
10. NO. OF WORKERS	10	CLAYERS
11. NO. OF WORKERS	11	CLAYERS
12. NO. OF WORKERS	12	CLAYERS
13. NO. OF WORKERS	13	CLAYERS
14. NO. OF WORKERS	14	CLAYERS
15. NO. OF WORKERS	15	CLAYERS
16. NO. OF WORKERS	16	CLAYERS
17. NO. OF WORKERS	17	CLAYERS
18. NO. OF WORKERS	18	CLAYERS
19. NO. OF WORKERS	19	CLAYERS
20. NO. OF WORKERS	20	CLAYERS
21. NO. OF WORKERS	21	CLAYERS
22. NO. OF WORKERS	22	CLAYERS
23. NO. OF WORKERS	23	CLAYERS
24. NO. OF WORKERS	24	CLAYERS
25. NO. OF WORKERS	25	CLAYERS
26. NO. OF WORKERS	26	CLAYERS
27. NO. OF WORKERS	27	CLAYERS
28. NO. OF WORKERS	28	CLAYERS
29. NO. OF WORKERS	29	CLAYERS
30. NO. OF WORKERS	30	CLAYERS

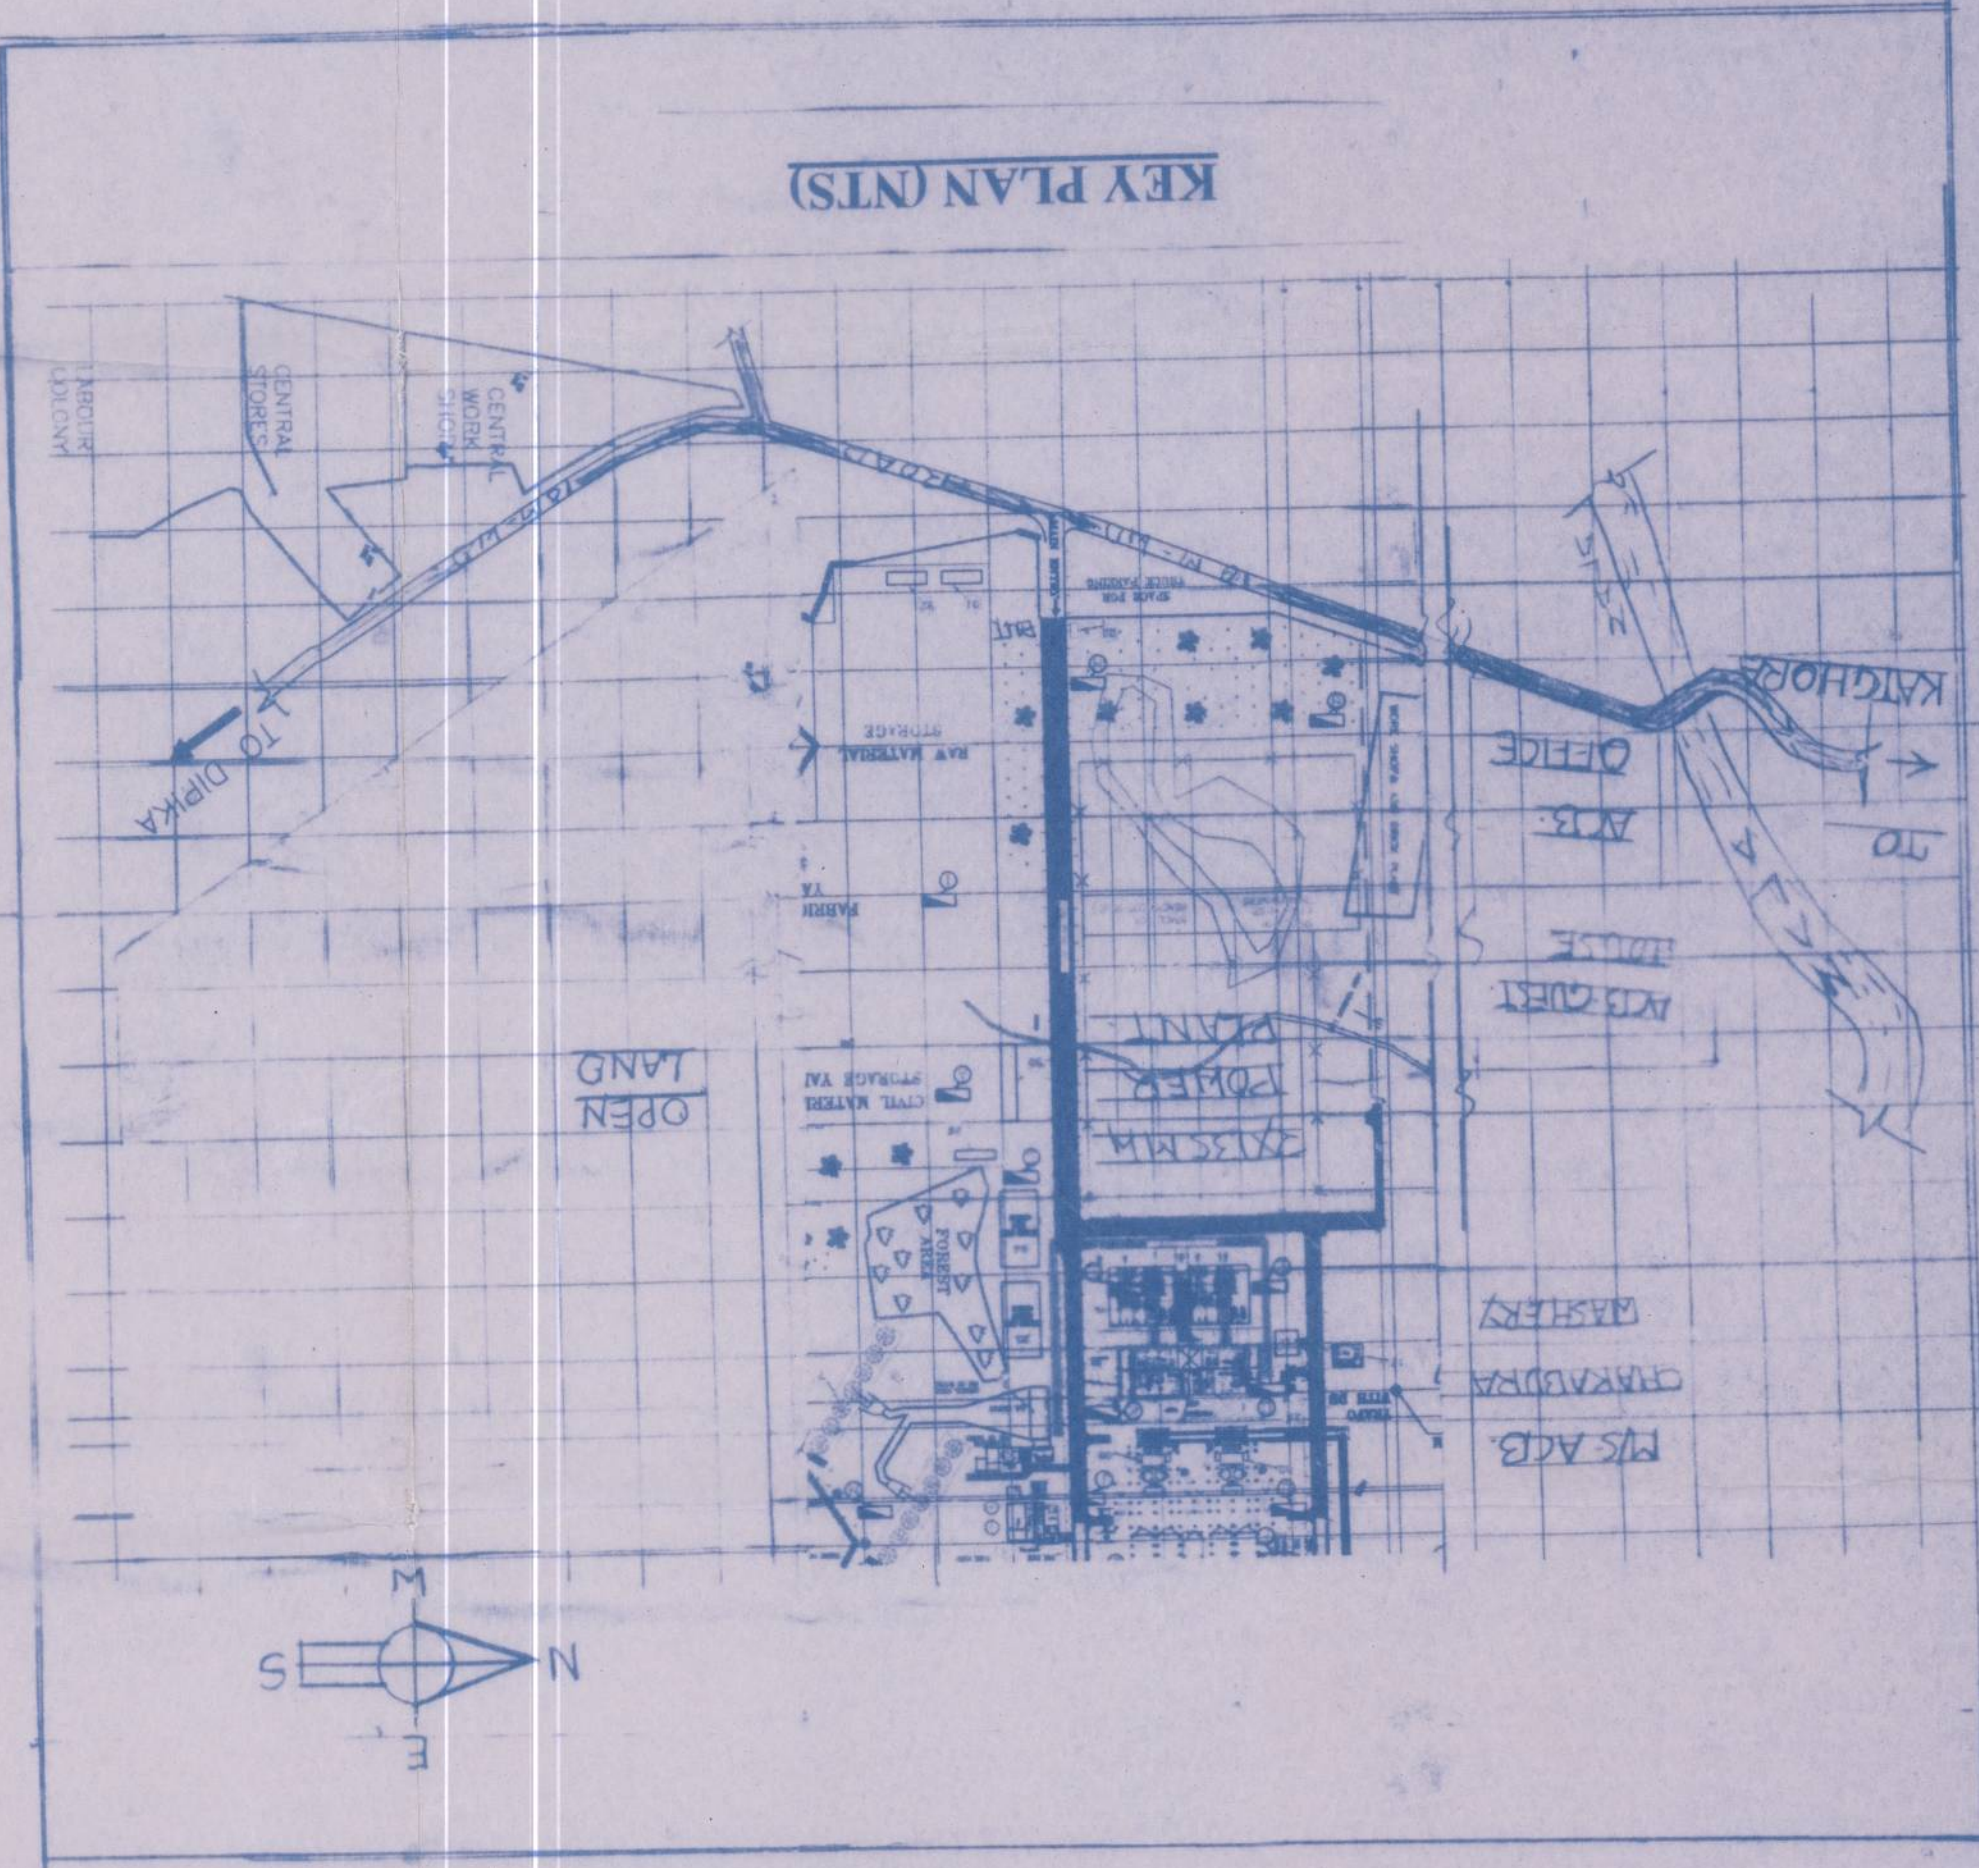

LAYOUT/SITE PLAN (SCALE: 1:500)

INDEX	DESCRIPTION
1	EMERGENCY CONTROL CENTER
2	HAZARDOUS AREA
3	HYDRANT LINE
4	FIRE EXTINGUISHER & FIRE POINT
5	ASSEMBLY POINT
6	ROUTE OF ESCAPE

TITLE - LAYOUT/SITE PLAN & KEY PLAN

DRAWING SHOWS PROPOSED 2X13 MW POWER PLANT OF KASAPATI THERMAL POWER PLANT (SITUAED IN VILL. KASAPATI, P.O. JAWALI, TAH. KATGHORA, DIST. KORBA (C.G.))

CONSULTANT - ER. PRAKASH PRAHARAY (B.E. CIVIL, MHD)

361, SUNDER NAGAR, RAIPUR (C.G.)

CHARTERED ENGINEER, DESIGNER & PLANNER

REG. NO. 12345

SCALE - 1:500

DATE - 10/10/2023

PROJECT - KASAPATI THERMAL POWER PLANT

BY - PRAKASH PRAHARAY

FOR - KASAPATI THERMAL POWER PLANT

AT - KASAPATI, P.O. JAWALI, TAH. KATGHORA, DIST. KORBA (C.G.)

NO. OF SHEETS - 01

SHEET NO. - 01

DATE - 10/10/2023

PROJECT - KASAPATI THERMAL POWER PLANT

BY - PRAKASH PRAHARAY

FOR - KASAPATI THERMAL POWER PLANT

AT - KASAPATI, P.O. JAWALI, TAH. KATGHORA, DIST. KORBA (C.G.)

NO. OF SHEETS - 01

SHEET NO. - 01

DATE - 10/10/2023

PROJECT - KASAPATI THERMAL POWER PLANT

BY - PRAKASH PRAHARAY

FOR - KASAPATI THERMAL POWER PLANT

AT - KASAPATI, P.O. JAWALI, TAH. KATGHORA, DIST. KORBA (C.G.)

NO. OF SHEETS - 01

SHEET NO. - 01

DATE - 10/10/2023

PROJECT - KASAPATI THERMAL POWER PLANT

BY - PRAKASH PRAHARAY

FOR - KASAPATI THERMAL POWER PLANT

AT - KASAPATI, P.O. JAWALI, TAH. KATGHORA, DIST. KORBA (C.G.)

NO. OF SHEETS - 01

SHEET NO. - 01

DATE - 10/10/2023

PROJECT - KASAPATI THERMAL POWER PLANT

BY - PRAKASH PRAHARAY

FOR - KASAPATI THERMAL POWER PLANT

AT - KASAPATI, P.O. JAWALI, TAH. KATGHORA, DIST. KORBA (C.G.)

NO. OF SHEETS - 01

SHEET NO. - 01

DATE - 10/10/2023

PROJECT - KASAPATI THERMAL POWER PLANT

BY - PRAKASH PRAHARAY

FOR - KASAPATI THERMAL POWER PLANT

AT - KASAPATI, P.O. JAWALI, TAH. KATGHORA, DIST. KORBA (C.G.)

NO. OF SHEETS - 01

SHEET NO. - 01

DATE - 10/10/2023

PROJECT - KASAPATI THERMAL POWER PLANT

BY - PRAKASH PRAHARAY

FOR - KASAPATI THERMAL POWER PLANT

AT - KASAPATI, P.O. JAWALI, TAH. KATGHORA, DIST. KORBA (C.G.)

NO. OF SHEETS - 01

SHEET NO. - 01

DATE - 10/10/2023

PROJECT - KASAPATI THERMAL POWER PLANT

BY - PRAKASH PRAHARAY

FOR - KASAPATI THERMAL POWER PLANT

AT - KASAPATI, P.O. JAWALI, TAH. KATGHORA, DIST. KORBA (C.G.)

NO. OF SHEETS - 01

SHEET NO. - 01

DATE - 10/10/2023

PROJECT - KASAPATI THERMAL POWER PLANT

BY - PRAKASH PRAHARAY

FOR - KASAPATI THERMAL POWER PLANT

AT - KASAPATI, P.O. JAWALI, TAH. KATGHORA, DIST. KORBA (C.G.)

NO. OF SHEETS - 01

SHEET NO. - 01

DATE - 10/10/2023

PROJECT - KASAPATI THERMAL POWER PLANT

BY - PRAKASH PRAHARAY

FOR - KASAPATI THERMAL POWER PLANT

AT - KASAPATI, P.O. JAWALI, TAH. KATGHORA, DIST. KORBA (C.G.)

NO. OF SHEETS - 01

SHEET NO. - 01

DATE - 10/10/2023

PROJECT - KASAPATI THERMAL POWER PLANT

BY - PRAKASH PRAHARAY

FOR - KASAPATI THERMAL POWER PLANT

AT - KASAPATI, P.O. JAWALI, TAH. KATGHORA, DIST. KORBA (C.G.)

NO. OF SHEETS - 01

SHEET NO. - 01

DATE - 10/10/2023

PROJECT - KASAPATI THERMAL POWER PLANT

BY - PRAKASH PRAHARAY

FOR - KASAPATI THERMAL POWER PLANT

AT - KASAPATI, P.O. JAWALI, TAH. KATGHORA, DIST. KORBA (C.G.)

NO. OF SHEETS - 01

SHEET NO. - 01

DATE - 10/10/2023

PROJECT - KASAPATI THERMAL POWER PLANT

BY - PRAKASH PRAHARAY

FOR - KASAPATI THERMAL POWER PLANT

AT - KASAPATI, P.O. JAWALI, TAH. KATGHORA, DIST. KORBA (C.G.)

NO. OF SHEETS - 01

SHEET NO. - 01

DATE - 10/10/2023

PROJECT - KASAPATI THERMAL POWER PLANT

BY - PRAKASH PRAHARAY

FOR - KASAPATI THERMAL POWER PLANT

AT - KASAPATI, P.O. JAWALI, TAH. KATGHORA, DIST. KORBA (C.G.)

NO. OF SHEETS - 01

SHEET NO. - 01

DATE - 10/10/2023

PROJECT - KASAPATI THERMAL POWER PLANT

BY - PRAKASH PRAHARAY

FOR - KASAPATI THERMAL POWER PLANT

AT - KASAPATI, P.O. JAWALI, TAH. KATGHORA, DIST. KORBA (C.G.)

NO. OF SHEETS - 01

SHEET NO. - 01

DATE - 10/10/2023

PROJECT - KASAPATI THERMAL POWER PLANT

BY - PRAKASH PRAHARAY

FOR - KASAPATI THERMAL POWER PLANT

AT - KASAPATI, P.O. JAWALI, TAH. KATGHORA, DIST. KORBA (C.G.)

NO. OF SHEETS - 01

SHEET NO. - 01

DATE - 10/10/2023

PROJECT - KASAPATI THERMAL POWER PLANT

BY - PRAKASH PRAHARAY

FOR - KASAPATI THERMAL POWER PLANT

AT - KASAPATI, P.O. JAWALI, TAH. KATGHORA, DIST. KORBA (C.G.)

NO. OF SHEETS - 01

SHEET NO. - 01

DATE - 10/10/2023

PROJECT - KASAPATI THERMAL POWER PLANT

BY - PRAKASH PRAHARAY

FOR - KASAPATI THERMAL POWER PLANT

AT - KASAPATI, P.O. JAWALI, TAH. KATGHORA, DIST. KORBA (C.G.)

NO. OF SHEETS - 01

SHEET NO. - 01

DATE - 10/10/2023

PROJECT - KASAPATI THERMAL POWER PLANT

BY - PRAKASH PRAHARAY

FOR - KASAPATI THERMAL POWER PLANT

AT - KASAPATI, P.O. JAWALI, TAH. KATGHORA, DIST. KORBA (C.G.)

NO. OF SHEETS - 01

SHEET NO. - 01

DATE - 10/10/2023

PROJECT - KASAPATI THERMAL POWER PLANT

BY - PRAKASH PRAHARAY

FOR - KASAPATI THERMAL POWER PLANT

AT - KASAPATI, P.O. JAWALI, TAH. KATGHORA, DIST. KORBA (C.G.)

NO. OF SHEETS - 01

SHEET NO. - 01

DATE - 10/10/2023

PROJECT - KASAPATI THERMAL POWER PLANT

BY - PRAKASH PRAHARAY

FOR - KASAPATI THERMAL POWER PLANT

AT - KASAPATI, P.O. JAWALI, TAH. KATGHORA, DIST. KORBA (C.G.)

NO. OF SHEETS - 01

SHEET NO. - 01

DATE - 10/10/2023

PROJECT - KASAPATI THERMAL POWER PLANT

BY - PRAKASH PRAHARAY

FOR - KASAPATI THERMAL POWER PLANT

AT - KASAPATI, P.O. JAWALI, TAH. KATGHORA, DIST. KORBA (C.G.)

NO. OF SHEETS - 01

SHEET NO. - 01

DATE - 10/10/2023

PROJECT - KASAPATI THERMAL POWER PLANT

BY - PRAKASH PRAHARAY

FOR - KASAPATI THERMAL POWER PLANT

AT - KASAPATI, P.O. JAWALI, TAH. KATGHORA, DIST. KORBA (C.G.)

NO. OF SHEETS - 01

SHEET NO. - 01

DATE - 10/10/2023

PROJECT - KASAPATI THERMAL POWER PLANT

BY - PRAKASH PRAHARAY

FOR - KASAPATI THERMAL POWER PLANT

AT - KASAPATI, P.O. JAWALI, TAH. KATGHORA, DIST. KORBA (C.G.)

NO. OF SHEETS - 01

SHEET NO. - 01