



BUILT UP AREA DIAGRAM - MUMITY, MACHINE ROOM AND WATER TANKS			
S.No.	Nos.	LENGTH (M)	AREA (SQ.M)
ADDITION			
1	1	7.30	4.30
2	1	7.70	4.70
3	1	3.15	4.70
4	1	12.90	19.70
5	1	6.00	2.85
6	1	6.90	3.70
7	1	8.70	6.20
8	1	5.05	3.18
TOTAL NON FAR			449.18



SL.NO.	TAG.	Rough Opening Width	Height	REMARKS
1.00	FD1	1.80	2.45	STAIRCASE-01,02,03 & 04
2.00	FD2	2.10	2.45	LIFT LOBBY
3.00	FD3	1.60	2.45	STAIRCASE-01,02,03 & 04
SERVICE DOOR SCHEDULE				
1.00	TD3	1.25	2.45	HVAC

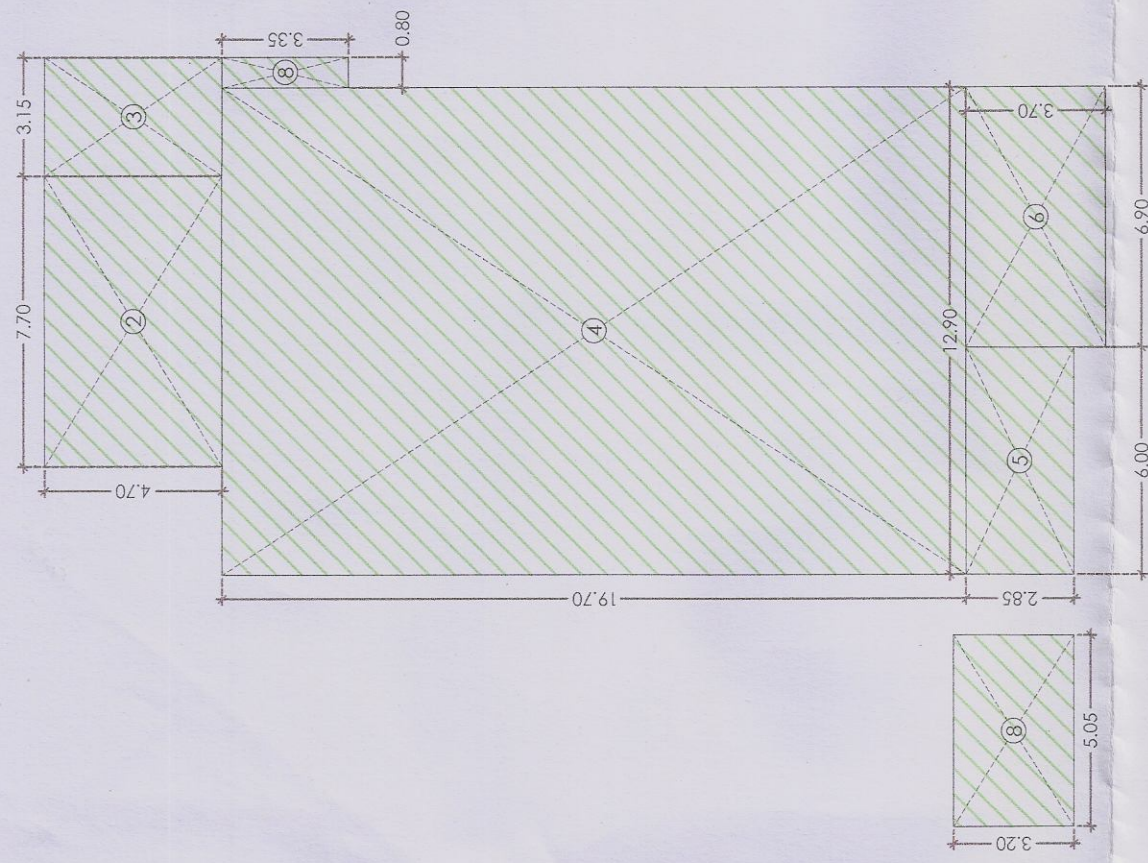

RF TERRACE LAYOUT (AREA DIAGRAM) REF: SCALE 1:200

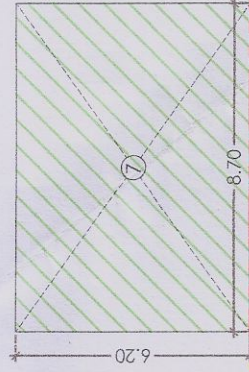

RF ROOF LEVEL LAYOUT REF: SCALE 1:150

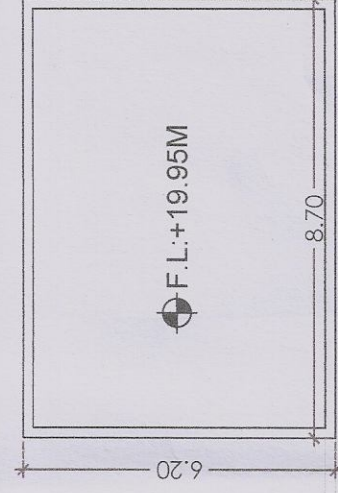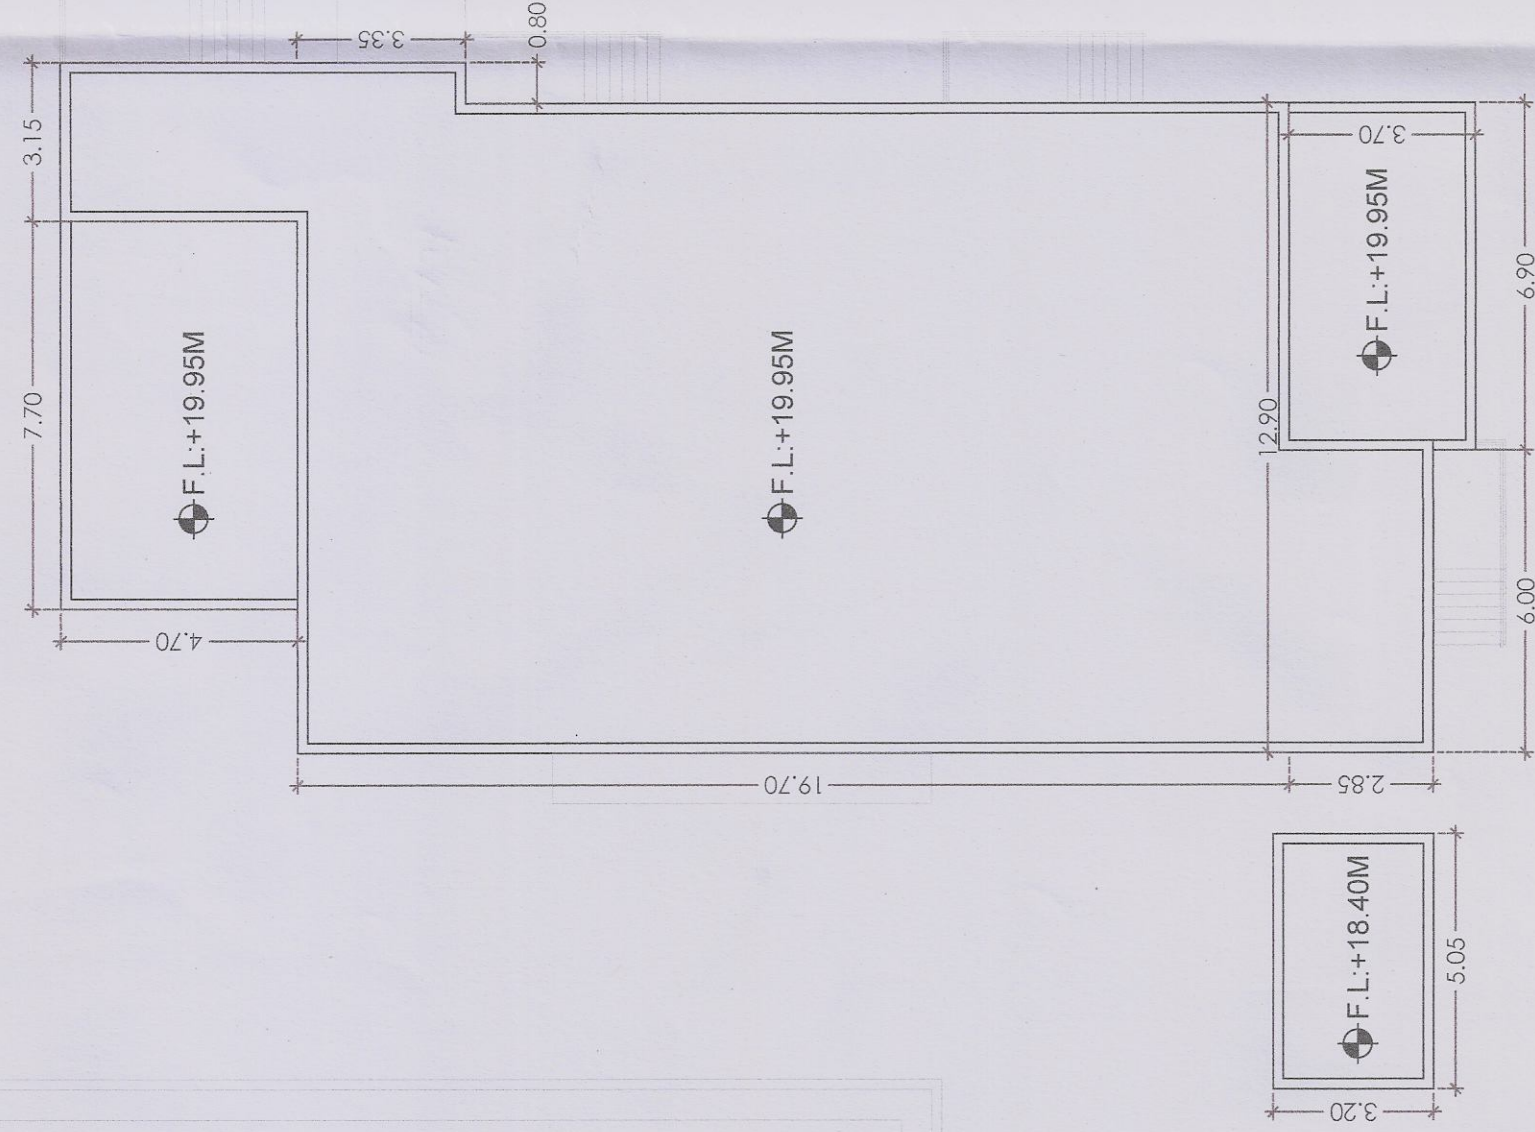

TO BE READ WITH THIS OFFICE
MEMO NO.:
DATED :

This is a PROVISIONAL BUILDING PLAN
approved only for the purpose of indicating
objections from the general public

DTP (HQ)
S.T.P. (HQ)
Member Secretary
B.P.A.C.

DTP (HQ)
S.T.P. (HQ)
Member Secretary
B.P.A.C.

DTP (HQ)
S.T.P. (HQ)
Member Secretary
B.P.A.C.

DTP (HQ)
S.T.P. (HQ)
Member Secretary
B.P.A.C.

DTP (HQ)
S.T.P. (HQ)
Member Secretary
B.P.A.C.

OWNER SIGN
ARCHITECT SIGN
Devashish Bhardwaj, Architect
Council of Architecture
Registration No.: CA/2016/7841

Architects:	ARCOP	ARCOP A-15, Parkside Estate, G-1, 1 New Delhi, Delhi 110048, India Ph: +91-11-26440001, 26440002 Email: info@arcop.co.in
Structure:	VINTECH CONSULTANTS	VINTECH CONSULTANTS CONSULTING ENGINEERS AND PROJECT MANAGERS C-53, JAMUNDA ENCLAVE CREATOR GATEWAY, NEW DELHI - 110048 TEL: 011-26440001, 26440002 FAX: 011-26440003 Email: info@vintech.co.in
MEP:	SANAEAC CONSULTANTS PVT. LTD.	SANAEAC CONSULTANTS PVT. LTD. 44, OKRA VIKAS, NEW DELHI - 110020 TEL: 011-26440001, 26440002 FAX: 011-26440003 Email: info@sanaeac.co.in
Landscaping:	Design Accord Consultants Pvt. Ltd.	Design Accord Consultants Pvt. Ltd. 30, Wazirpur Road, Opp. Apollo Hospital, New Delhi - 110029 Ph: +91-11-4538459
Transportation:	UNITARIS MOBILITY SOLUTIONS	UNITARIS MOBILITY SOLUTIONS 30, Wazirpur Road, Opp. Apollo Hospital, New Delhi - 110029 Ph: +91-11-4538459
Vertical Transportation:	MATRIX	MATRIX Vertical Transportation 30, Wazirpur Road, Opp. Apollo Hospital, New Delhi - 110029 Ph: +91-11-4538459

General Notes:	1. ALL DIMENSIONS ARE IN METERS UNLESS SPECIFIED. 2. GATE AND BOUNDARY WALL SHALL BE AS PER STANDARD DESIGN. 3. SPRINKLERS WILL BE PROVIDED IN ENTIRE BUILDING INCLUDING BASEMENTS AS PER N.B.C. 4. RAINWATER HARVESTING SYSTEM WILL BE PROVIDED AS PER APPLICABLE NORMS. 5. DISABLED RAMP @ 1:12 SLOPE WITH 900MM HIGH RAILING. 6. ALL BUILDINGS ARE MECHANICALLY VENTILATED AND FULLY AIR CONDITIONED WITH 100% POWER BACK UP PROVIDED FOR LIFTS & ESSENTIAL SERVICE AREAS.
----------------	--

Authority Signatory:	Architect Sign	Devashish Bhardwaj, Architect Council of Architecture Registration No.: CA/2016/7841
Client:	ACREAGE BUILDERS PVT. LTD.	ACREAGE BUILDERS PVT. LTD.
Project Title:	REVISED BUILDING PLAN OF COMMERCIAL COLONY FOR AN AREA MEASURING 7.15 ACRES (LICENSE NO. 15 OF 2008 DATED 04.02.2008) IN SECTOR-65, GURUGRAM, HARYANA URBAN COMPLEX BEING DEVELOPED BY ACREAGE BUILDERS PVT. LTD.	Project Title: REVISED BUILDING PLAN OF COMMERCIAL COLONY FOR AN AREA MEASURING 7.15 ACRES (LICENSE NO. 15 OF 2008 DATED 04.02.2008) IN SECTOR-65, GURUGRAM, HARYANA URBAN COMPLEX BEING DEVELOPED BY ACREAGE BUILDERS PVT. LTD.
Scale:	1:200	Scale: 1:200
Date:	DEC-2023	Date: DEC-2023
Drawn By:	D.B.	Drawn By: D.B.
Checked By:	A.A.	Checked By: A.A.
Sheet Size:	A1	Sheet Size: A1