

BASEMENT SITE - PLAN

SCALE : 1"=18'-0"


INDEX:-
MAX. CAPACITY OF THE ROOMS
INT. WORKERS ANTICIPATED TO BE EMPLOYED

DETAIL OF POWER:-

511.00 H.P. ELECTRIC
1140.00 H.P. D.G.SETS (STAND BY)

1. FACTORY	PREMISES	SHOWN	AS
2. DRINKING	WATER	SHOWN	AS
3. WASHING	PLACE	SHOWN	AS
4. DRAINAGE	LINE	SHOWN	AS

--- (D.W.)
--- x (W.P.)

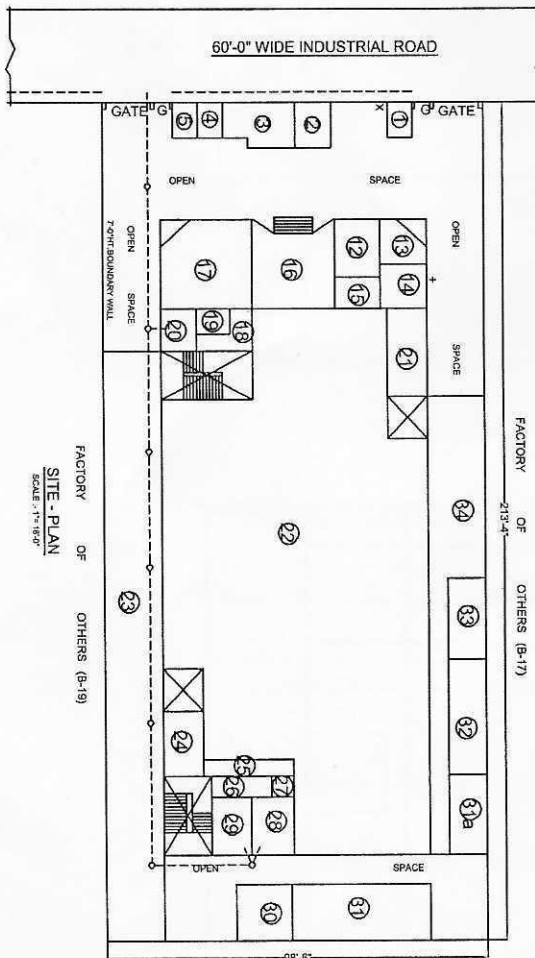FACTORY OF OTHERS (B-17)
FACTORY OF OTHERS (B-19)
FACTORY OF OTHERS (B-20)

SCALE : 1"=18'-0"

1. HOSPITAL	=1.50 K.M.
2. POLICE STATION	=0.50 K.M.
3. FIRE STATION	=0.50 K.M.
4. SCHOOL	=0.50 K.M.
5. PETROL PUMP	=0.50 K.M.
6. POPULATION (A/RD)	=0.50 K.M.

FACTORY BUILDING PLAN:-

M/S REXXAM DIXON ELECTRONICS PVT. LTD.

PLOT NO. - B - 18, PHASE - 2, NOIDA

DISTT. :- G. B. NAGAR (U.P.) 201305

SIGN OF MANAGER	SIGN OF OCCUPIER
DRG. NO.: 307/2022	

PREPARED BY:

D.B. PLANNERS


N.H. 50, OPP. VARDHAN PURM
POLICE CHOKI DEHLI MERRUT ROAD
MORTA GHAZIABAD (U.P.)
E-MAIL: d.b.planners12@gmail.com
M. 91-981020754, 9810205553

SIGN OF COMPETENT PERSON


Factory Manager

Occupier

Kuldeep Singh (B. Tech Civil)
(Structural Engineer)
(RAJ PLANNERS & ELECTRICALS)
(APPROVED COMPETENT PERSON)

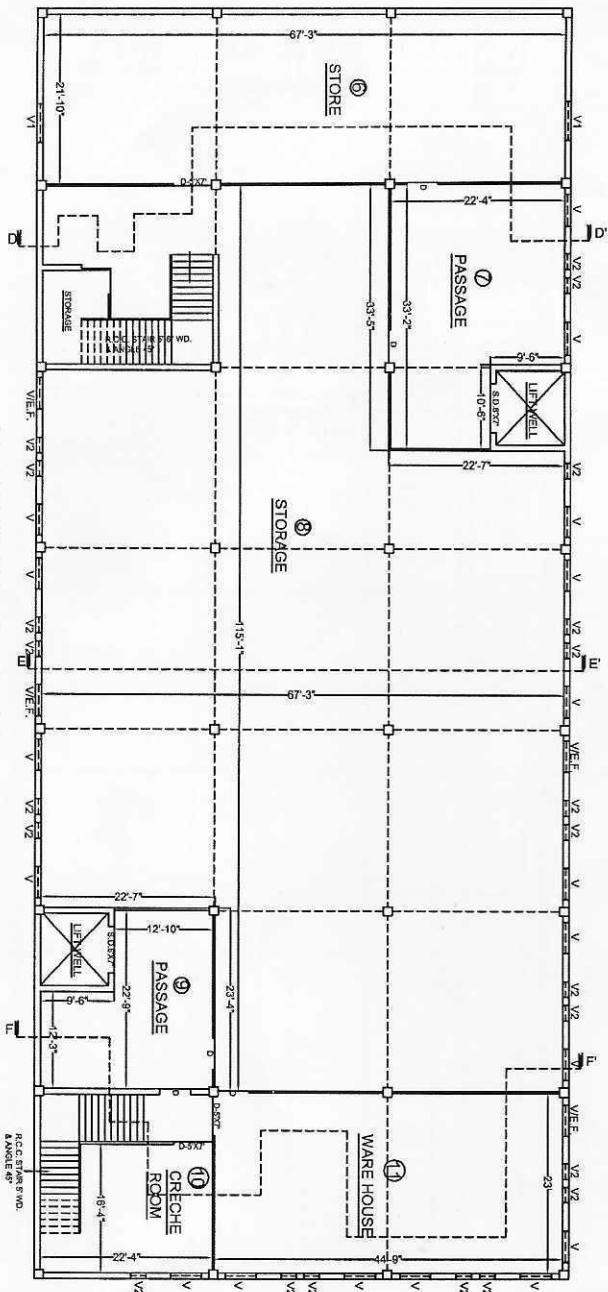

BASEMENT FLOOR PLAN

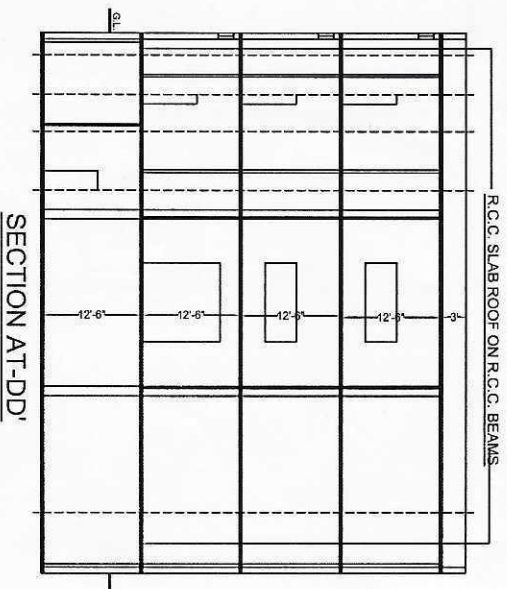

SECTION AT-DD'

FACTORY BUILDING PLAN :-

M/S REXXAM DIXON ELECTRONICS PVT. LTD.

PLOT NO - B - 18, PHASE - 2, NOIDA.

DISTT. :- G. B. NAGAR (U.P.) 201305

SIGN OF MANAGER

SCALE :- 1"=8'-0"

PREPARED BY

D.B. PLANNERS

N.H.50 OPP. VARDHMAN PURM

POLICE CHOKI DELHI MEERUT ROAD

MORTA GHAZIABAD (U.P.)

EMAIL: dbplanners123@gmail.com

M.PH: 9819263594, 9818263593

SIGN OF OCCUPIER

DRG. NO:- 307/2022

SIGN OF COMPETENT PERSON

M/S REXXAM DIXON ELECTRONICS Private Limited

M/S REXXAM DIXON ELECTRONICS Private Limited

Manager
Manager

Occupier
Occupier


Kuldeep Singh
Kuldeep Singh (B. Tech Civil)
(Structural Engineer)
(RAJ PLANNERS & ELECTRICALS)
(APPROVED COMPETENT PERSON)

(APPROVED COMPETENT PERSON)
(APPROVED COMPETENT PERSON)
(APPROVED COMPETENT PERSON)

SIZE OF DOORS AND WINDOWS

D 4X7 DOORS
D1 3X7 DOORS
W 4X5 WINDOW
W1 2X3 WINDOW
W2 3X5 WINDOW
W3 5X5 WINDOW
V 4X2 VENTILATION
V1 5X2 VENTILATION
V2 2X1 VENTILATION
E.F. 18Ø EXHAUST FAN

GROUND FLOOR PLAN

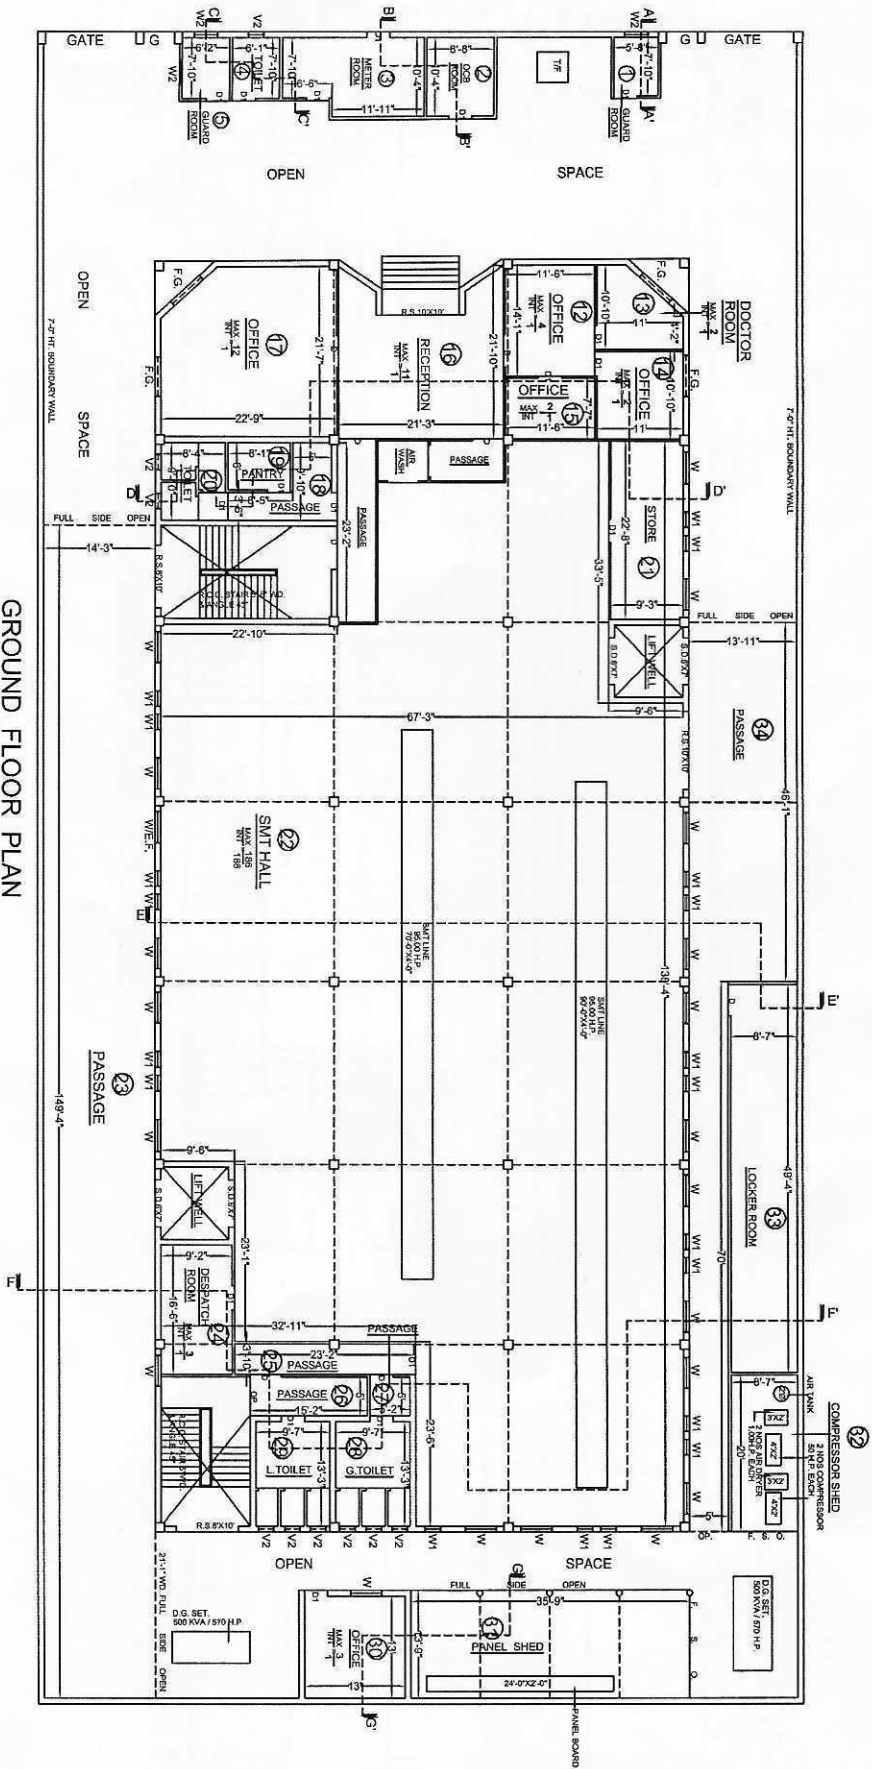


FACTORY BUILDING PLAN :-	
M/S REXXAM DIXON ELECTRONICS PVT. LTD.	
PLOT NO. - B - 18, PHASE - 2, NOIDA.	
DISTT. :- G. B. NAGAR (U.P.) 201305	
SIGN OF MANAGER	SIGN OF OCCUPIER
SCALE :- 1"=8'-0"	DRG. NO:- 307/2022
PREPARED BY	
D.B. PLANNERS	
N-1306P, VANDANAN RURA	
DO, NORTH CHAZI, ASIA (U.P.) ROAD	
EMAIL: d.b.planners123@gmail.com	
M.PH. 981 9263754, 9818365553	
SIGN OF COMPETENT PERSON	


SHEET NO-3

Drift
Factory Manager

Kuldeep Singh (B. Tech Civil)
(Structural Engineer)
(RAU PLANNERS & ELECTRICALS)
/APPROVED/COMPETENT PERSON

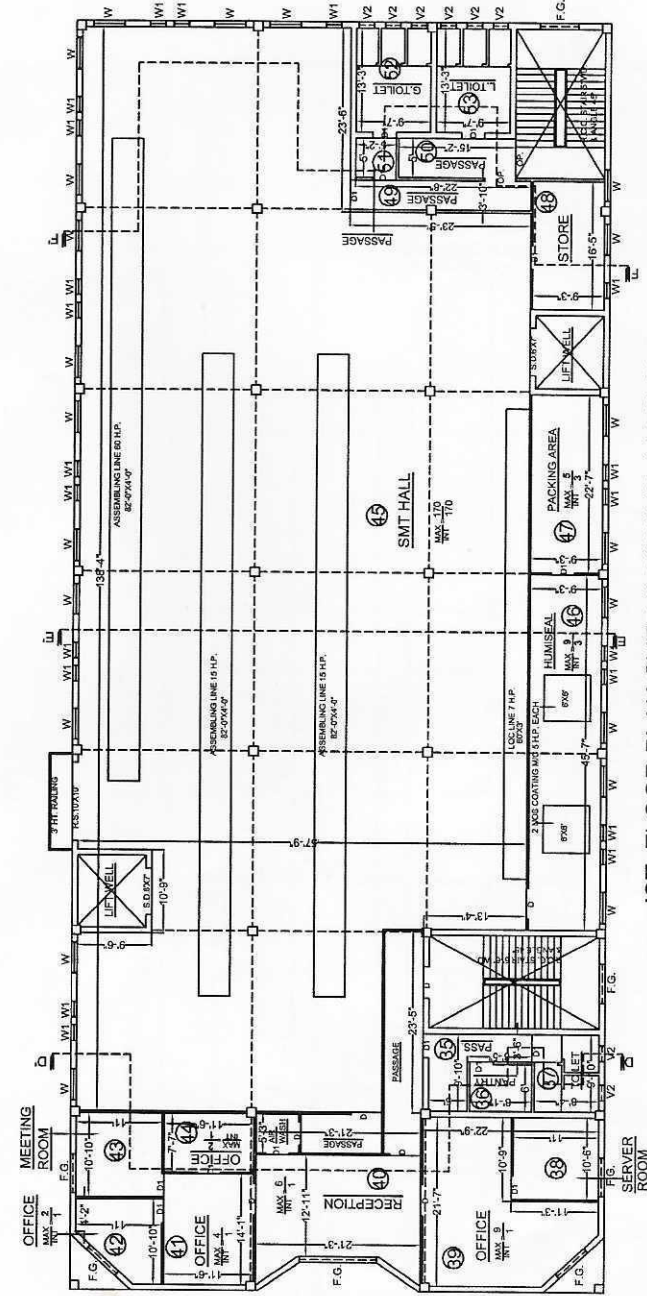

1ST. FLOOR PLAN OVER ROOM NO-12 TO 22,24 TO 29

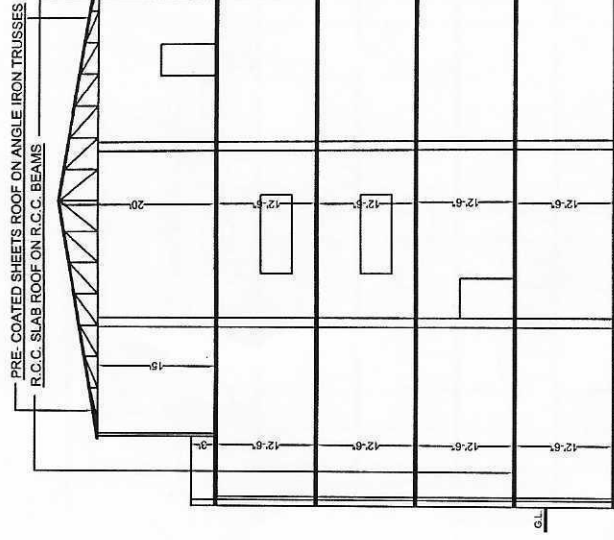

SECTION AT-EE'

FACTORY BUILDING PLAN :-

M/S REXXAM DIXON ELECTRONICS PVT. LTD.

PLOT NO - B - 18, PHASE - 2, NOIDA,
DISTT. :- G. B. NAGAR (U.P.) 201305

SIGN OF MANAGER
SCALE :- 1"=8'-0"

SIGN OF OCCUPIER
DRG. NO:- 307/2022

PREPARED BY:
D.B. PLANNERS

N.H.58 OPP VARDHMAN PURM
POLICE CHOKI DELHI MEERUT ROAD
MORTA GHAZIABAD (U.P.)
EMAIL - d.b.planners123@gmail.com
M PH - 9816263754, 88 6363553


SIGN OF COMPETENT PERSON

For Rexam Dixon Electronics Private Limited


Occupier

Occupier

Kuldeep Singh (B. Tech Civil)
(Structural Engineer)
(RAJ PLANNER'S & ELECTRICALS)
(APPROVED COMPETENT PERSON)

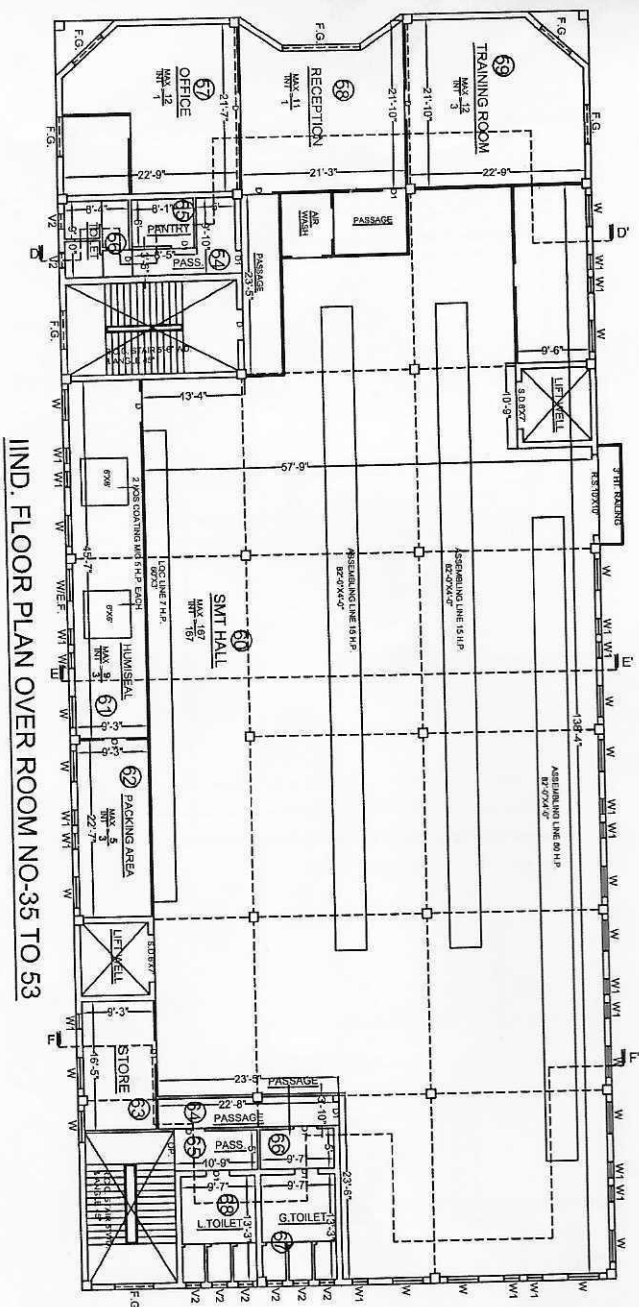

IIND. FLOOR PLAN OVER ROOM NO-35 TO 53

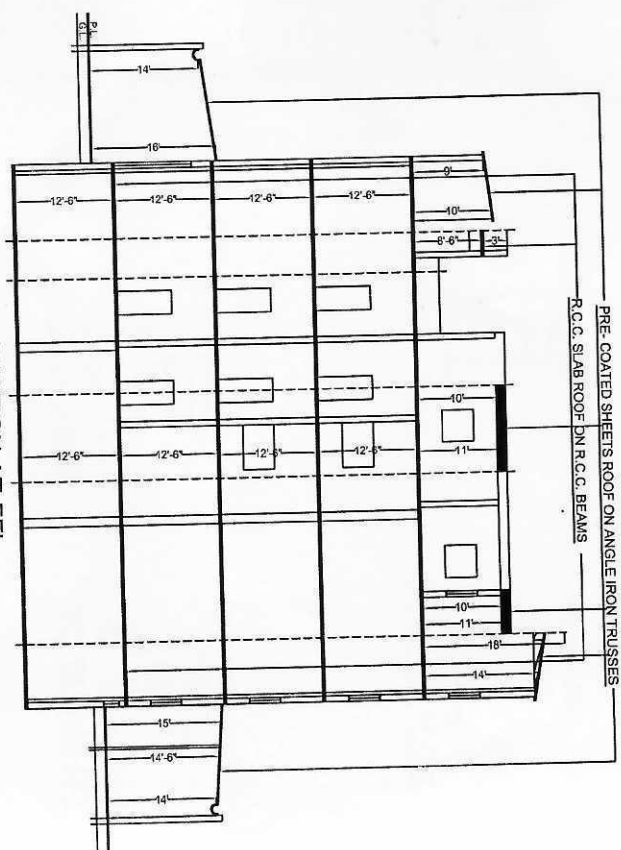

SECTION AT 'F-F'

FACTORY BUILDING PLAN:-

M/S REXXAM DIXON ELECTRONICS PVT. LTD.

PLOT NO - B - 18, PHASE - 2, NODA,

DISTT. :- G. B. NAGAR (U.P.) 201305

SIGN OF MANAGER

SCALE :- 1"=8'-0"

PREPARED BY

D.B. PLANNERS

N.H. 58 OPP. VARDHMAN PURVA
POLICE CHOKI DELHI MEEHUT ROAD
MORTIAGHIAZIABAD (U.P.)E-MAIL: dbplanners123@gmail.com
M.PH: 9891625374, 9810353555

SIGN OF OCCUPIER

DRG. NO:- 307/2022

SIGN OF COMPETENT PERSON


For REXXAM DIXON Electronics Private Limited

For REXXAM DIXON Electronics Private Limited





D.B. Planners
Factory Manager

Occupier

Kuldeep Singh (B. Tech Civil)
(Structural Engineer)
(RAU PLANNERS & ELECTRICALS)
'APPROVED COMPETENT PERSON'

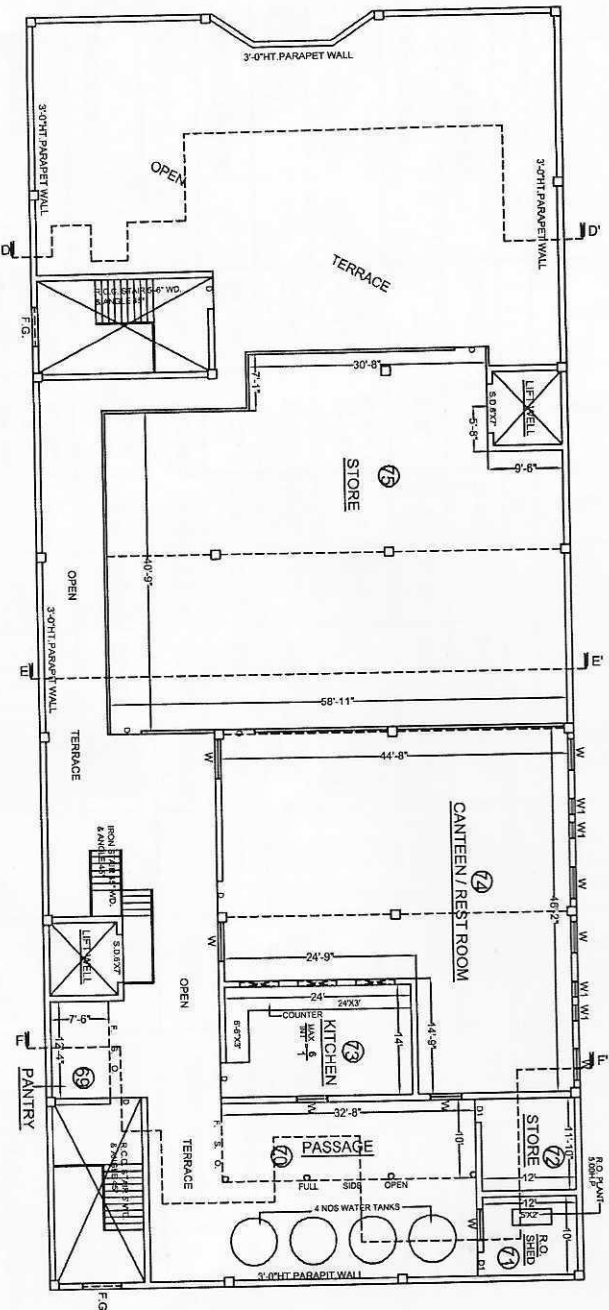

IIIIRD. FLOOR PLAN OVER ROOM NO-60, 63, 64, 66, 67

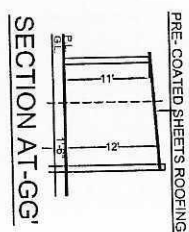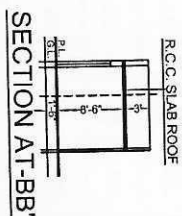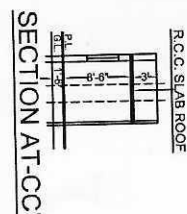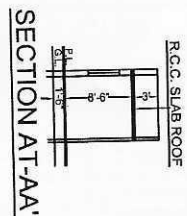

FACTORY BUILDING PLAN :-

M/S REXXAM DIXON ELECTRONICS PVT. LTD.

PLOT NO. - B - 18, PHASE - 2, NOIDA,

DISTT. :- G. B. NAGAR (U.P.) 201305

SIGN OF MANAGER

SCALE :- 1"=8'-0"

PREPARED BY

D.B. PLANNERS

N.H. 80/PT. VAROHAN ROAD
PO BOX 122000, GATEWAY
INDIA - 400 002 (MUMBAI)
E-MAIL: d.b.planners@dbplanners.com
M.P.H. 4818263754.9818353553

SIGN OF OCCUPIER

DRG. NO:- 307/2022

SIGN OF COMPETENT PERSON

For Reexam Dixon Electronics Private Limited

Factory Manager

For Reexam Dixon Electronics Private Limited

Occupier

Kuldeep Singh (B. Tech Civil)
(Structural Engineer)
(RAJ PLANNERS & ELECTRICALS)
(APPROVED COMPETENT PERSON)