

NOTE:- PREVIOUS PLAN HAS BEEN ALREADY APPROVED BY D.D.F. HALDWANI VIDE LITTEr NO. 2154 F / REKHA / HWR / DATED 23.12.09

PLAN NO. JS / 01 / 06 / 13

REVISED & ADDITION  
PLAN OF THE FACTORY MAP  
M/S MIRC ELECTRONICS  
LIMITED (UNIT-II) AT KHASRA  
NO. 399 TO 401&405 TO 410, 158 Km  
MILESTONE, DELHI ROORKEE  
HIGHWAY, VILLAGE-  
MUNDIYAKI, PARGANA-  
MANGLAUR, DISTT. HARIDWAR  
(UTTARAKHAND)

SCALE

SITE PLAN SCALE = 1" = 32'.0"

DRAWING SHEET 4 / 4

POWER DETAIL-  
ELECTRIC POWER = 753.0 HP (INSTALLED)  
GENERATOR POWER = 2144.0 HP (STAND BY)


COLOUR REFERENCES

|                                 |         |
|---------------------------------|---------|
| ADDITION WORKS SHOWN AS         |         |
| FACTORY PERMISES SHOWN AS       |         |
| EXISTING WORKS SHOWN AS         |         |
| DRINKING WATER SHOWN AS         |         |
| DRAINAGE SHOWN AS               |         |
| UNDER GROUND WATER RESERVE TANK |         |
| FIRE STATION                    | 10.0 KM |
| POLICE STATION                  | 3.0 KM  |
| EDUCATION POINT                 | 3.0 KM  |
| HOSPITAL POINT                  | 7.0 KM  |
| POPULATED AREA                  | 1.0 KM  |
| PETROL PUMP                     | 5.0 KM  |

SIGN. OF MANAGER  
SIGN. OF OCCUPIER

ARCHITECT & PLANNERS

SANJAY MANI SHARMA  
JAI ASSOCIATES  
NEW SHARDA NAGAR  
SAHARANPUR  
MOB. - 9412574678

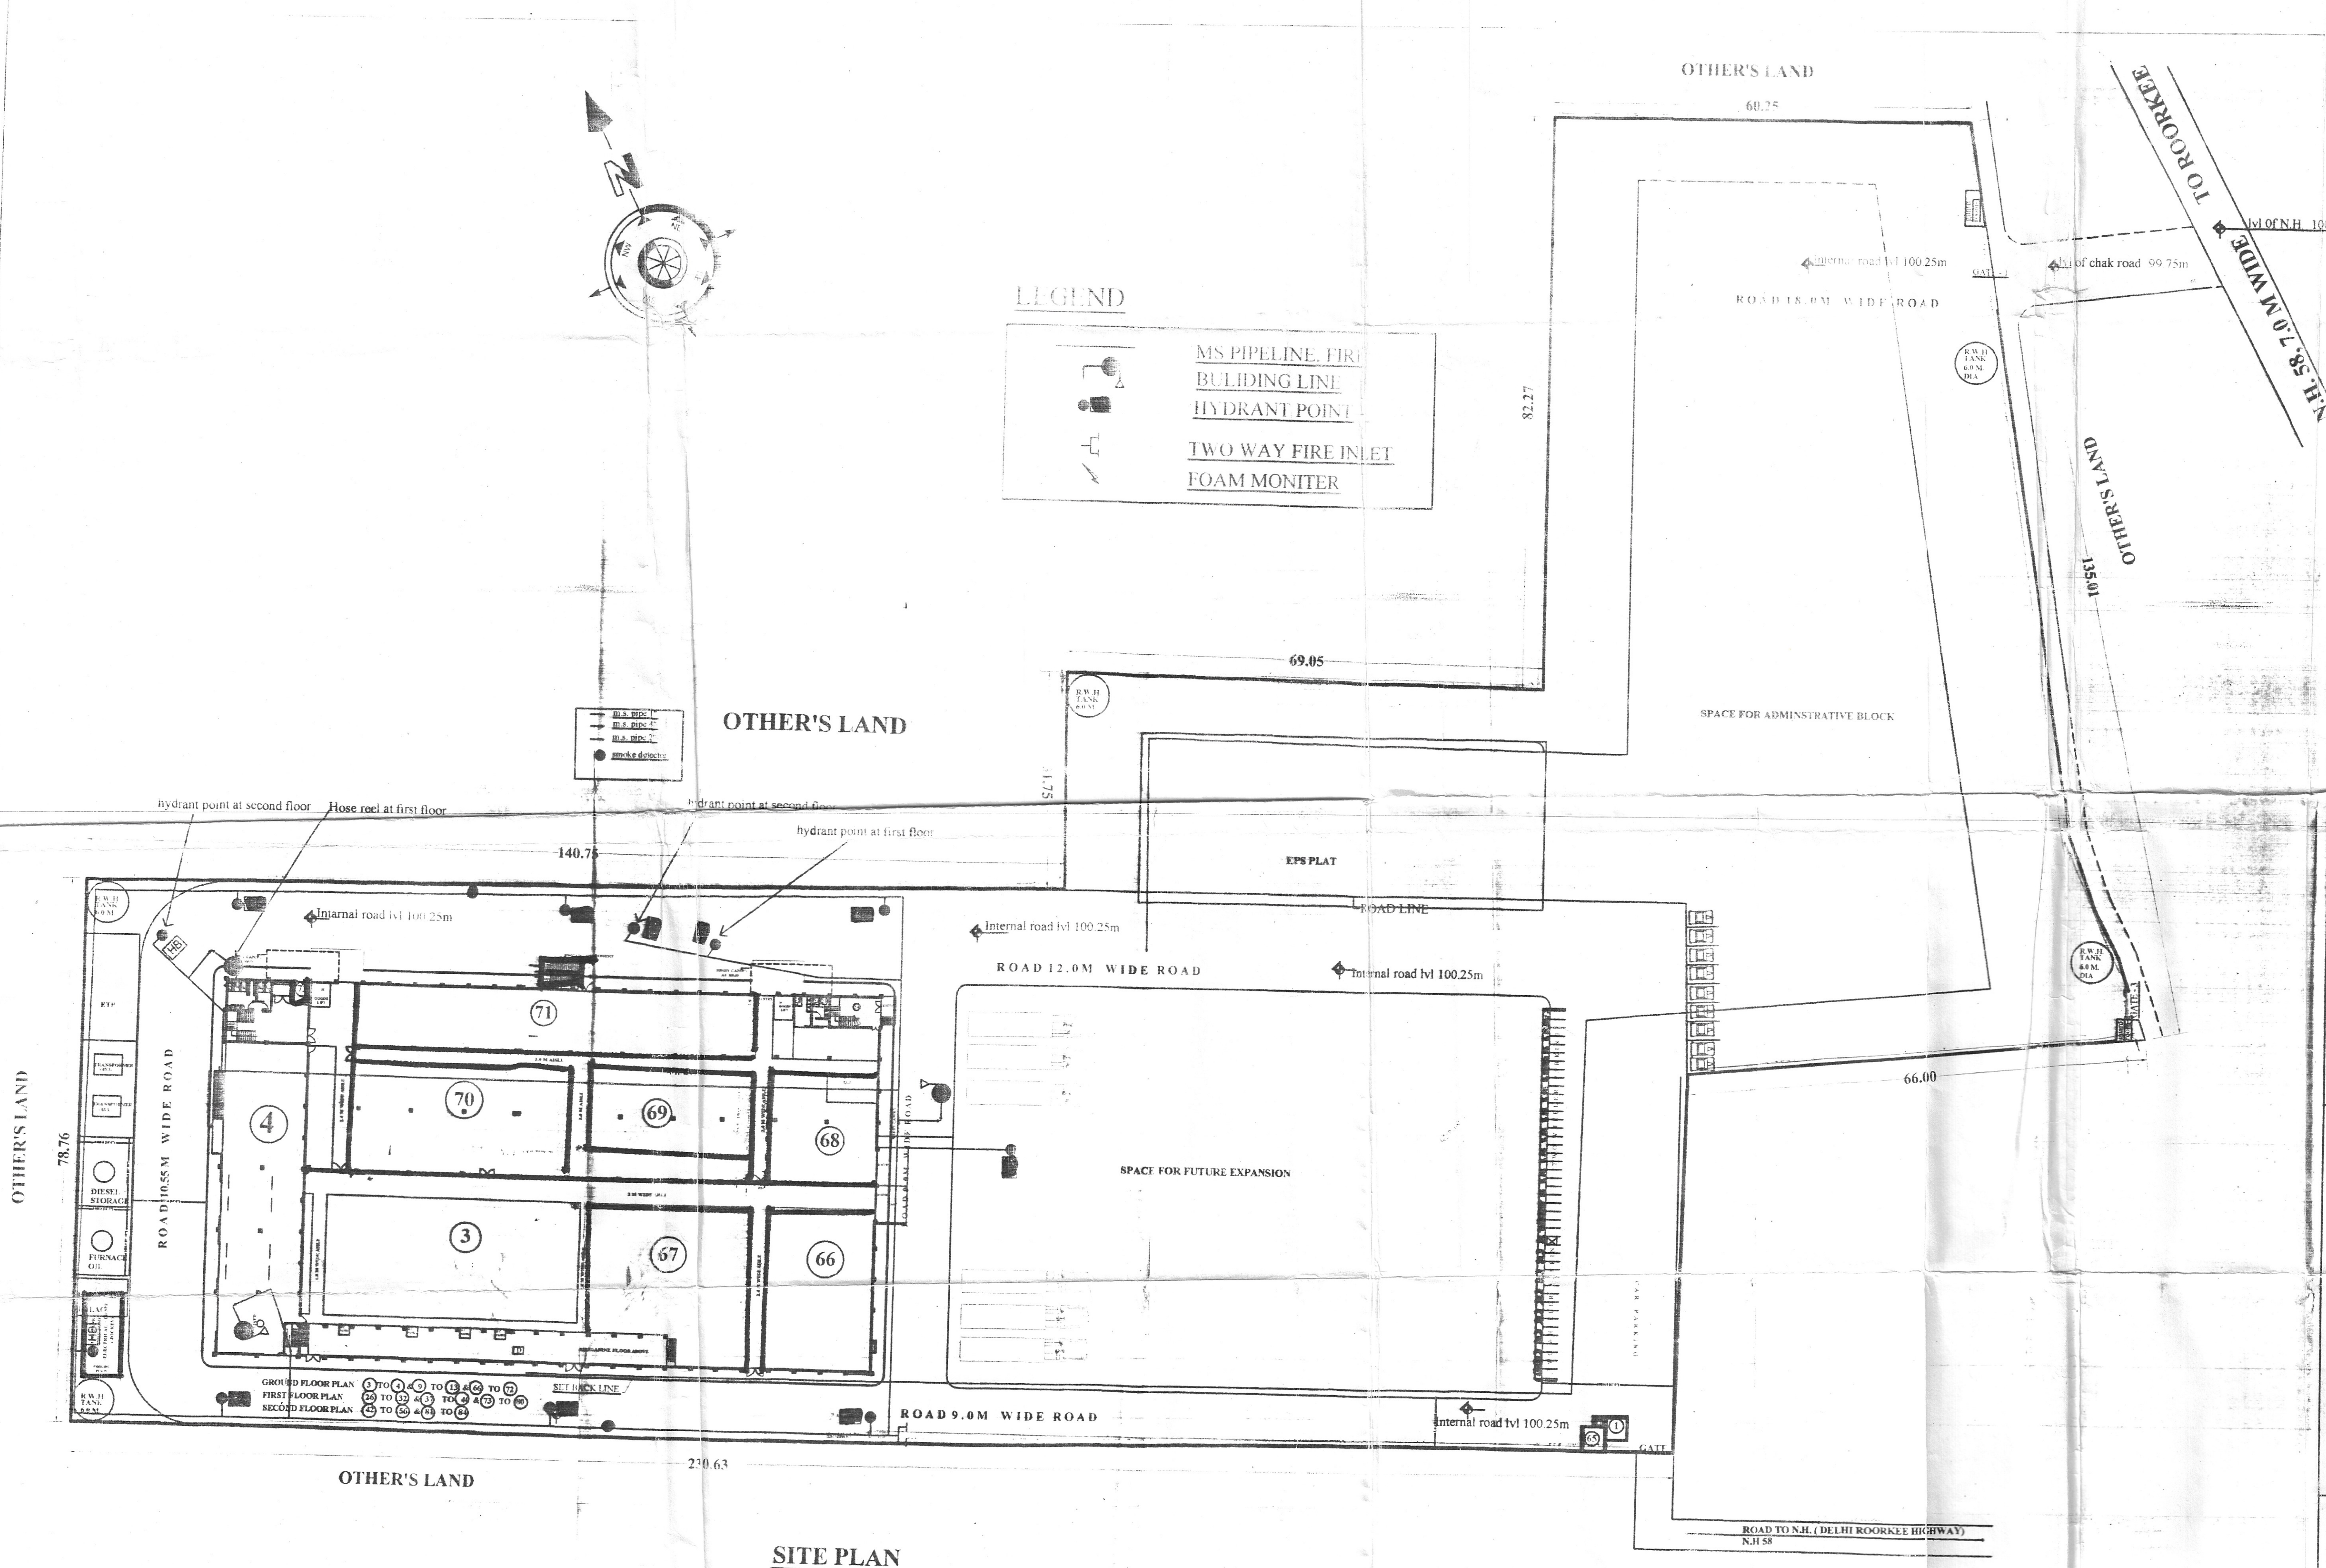

SITE PLAN