


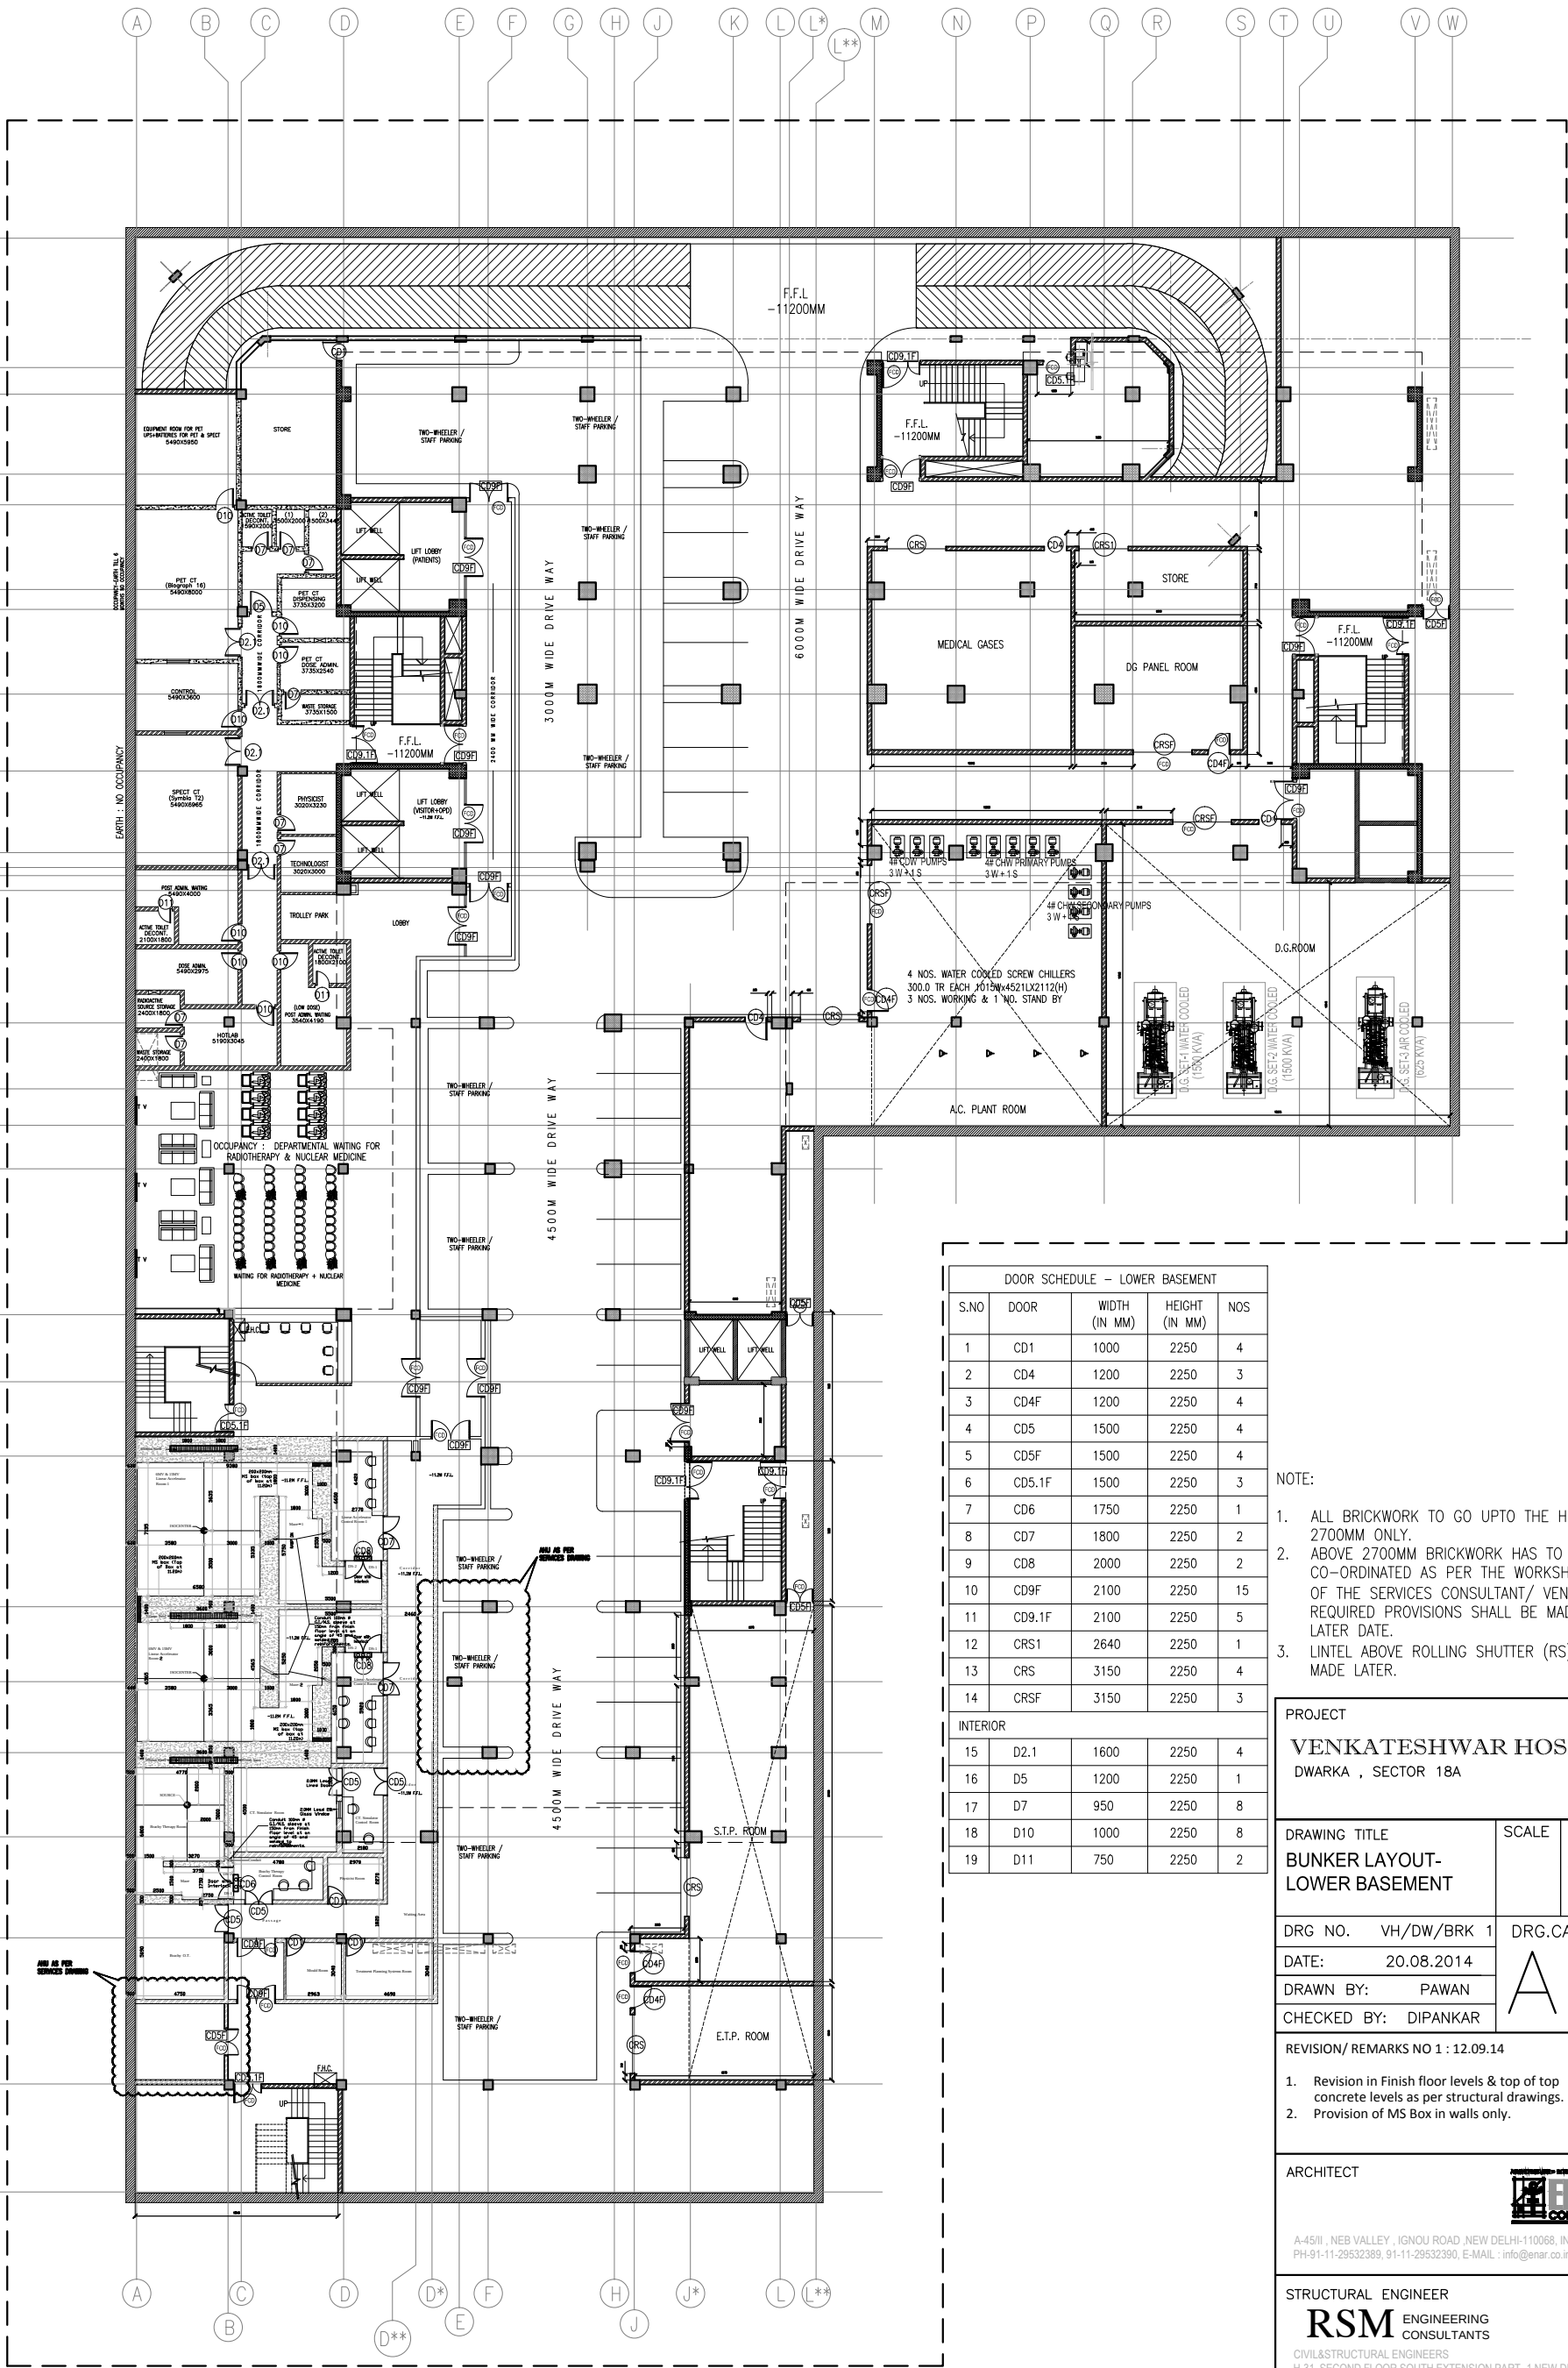

LEGEND	
	CONCRETE OF 2.35 GM/CC DENSITY
	RETAINING WALL OF BASEMENT
	BRICK WORK

DOOR SCHEDULE - LOWER BASEMENT				
S.NO	DOOR	WIDTH (IN MM)	HEIGHT (IN MM)	NOS
1	CD1	1000	2250	4
2	CD4	1200	2250	3
3	CD4F	1200	2250	4
4	CD5	1500	2250	4
5	CD5F	1500	2250	4
6	CD5.1F	1500	2250	3
7	CD6	1750	2250	1
8	CD7	1800	2250	2
9	CD8	2000	2250	2
10	CD9F	2100	2250	15
11	CD9.1F	2100	2250	5
12	CRS1	2640	2250	1
13	CRS	3150	2250	4
14	CRSF	3150	2250	3
INTERIOR				
15	D2.1	1600	2250	4
16	D5	1200	2250	1
17	D7	950	2250	8
18	D10	1000	2250	8
19	D11	750	2250	2

- NOTE:
- ALL BRICKWORK TO GO UPTO THE HEIGHT OF 2700MM ONLY.
 - ABOVE 2700MM BRICKWORK HAS TO BE CO-ORDINATED AS PER THE WORKSHOP DRAWINGS OF THE SERVICES CONSULTANT/ VENDORS. HENCE REQUIRED PROVISIONS SHALL BE MADE AT A LATER DATE.
 - INTEL ABOVE ROLLING SHUTTER (RS) SHALL BE MADE LATER.

PROJECT

VENKATESHWAR HOSPITAL

DWARKA , SECTOR 18A

DRAWING TITLE

BUNKER LAYOUT- LOWER BASEMENT

SCALE

DRG. NO.

VH/DW/BRK 1

DRG.CAT.:

AR

DATE:

20.08.2014

DRAWN BY:

PAWAN

CHECKED BY:

DIPANKAR

REVISION/ REMARKS NO 1 : 12.09.14

1. Revision in Finish floor levels & top of top concrete levels as per structural drawings.

2. Provision of MS Box in walls only.

ARCHITECT

A-45/II, NEB VALLEY , IGNOU ROAD ,NEW DELHI-110068, INDIA
PH-91-11-29532389, 91-11-29532390, E-MAIL : info@enar.co.in

STRUCTURAL ENGINEER

RSM ENGINEERING CONSULTANTS

CIVIL&STRUCTURAL ENGINEERS
H-31, SECOND FLOOR SOUTH EXTENSION PART -1,NEW DELHI-49, INDIA
PH-91-11-46056465, 91-11-41646124, E-MAIL : rsmengr@gmail.com


NOTES


1. The validity of this drawing is subject to approval from competent Municipal Authorities

2. All dimensions are in MM.

3. Do not scale the drawing. in case of discrepancy, please cross check with the Architect/s (ENAR CONSULTANTS).

4. In case of any doubt seek clarifications from the Architect/s.

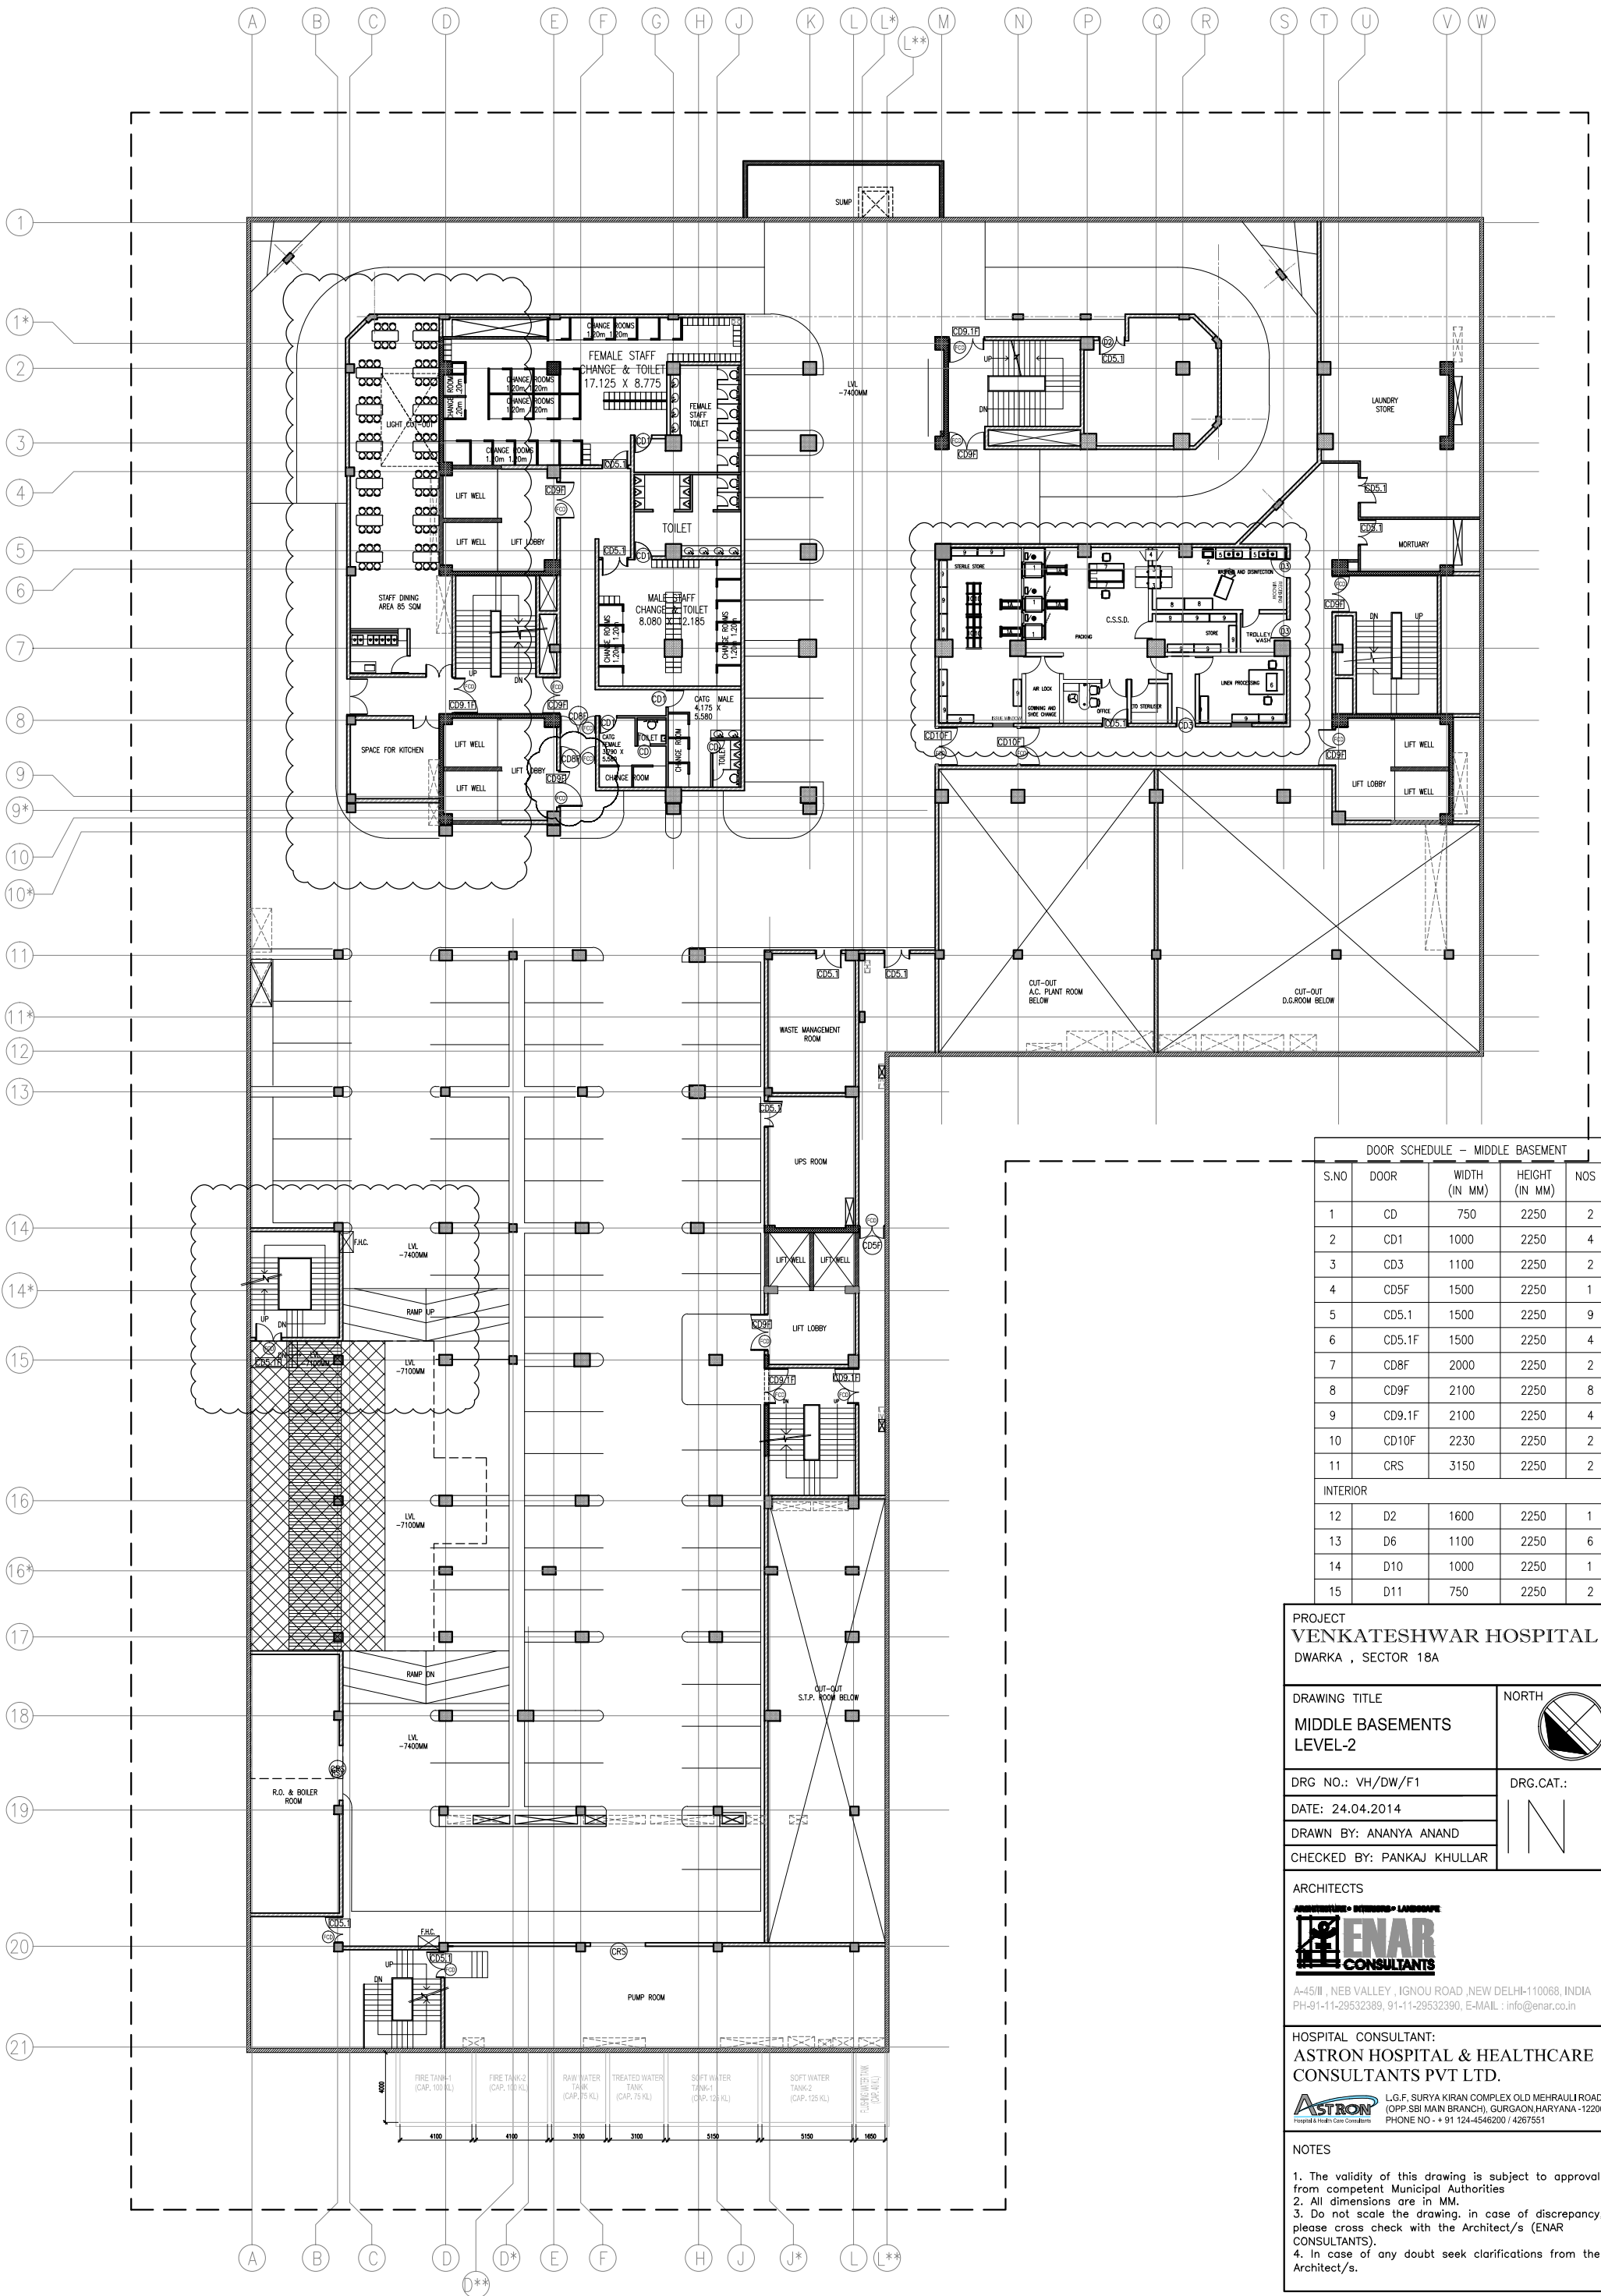

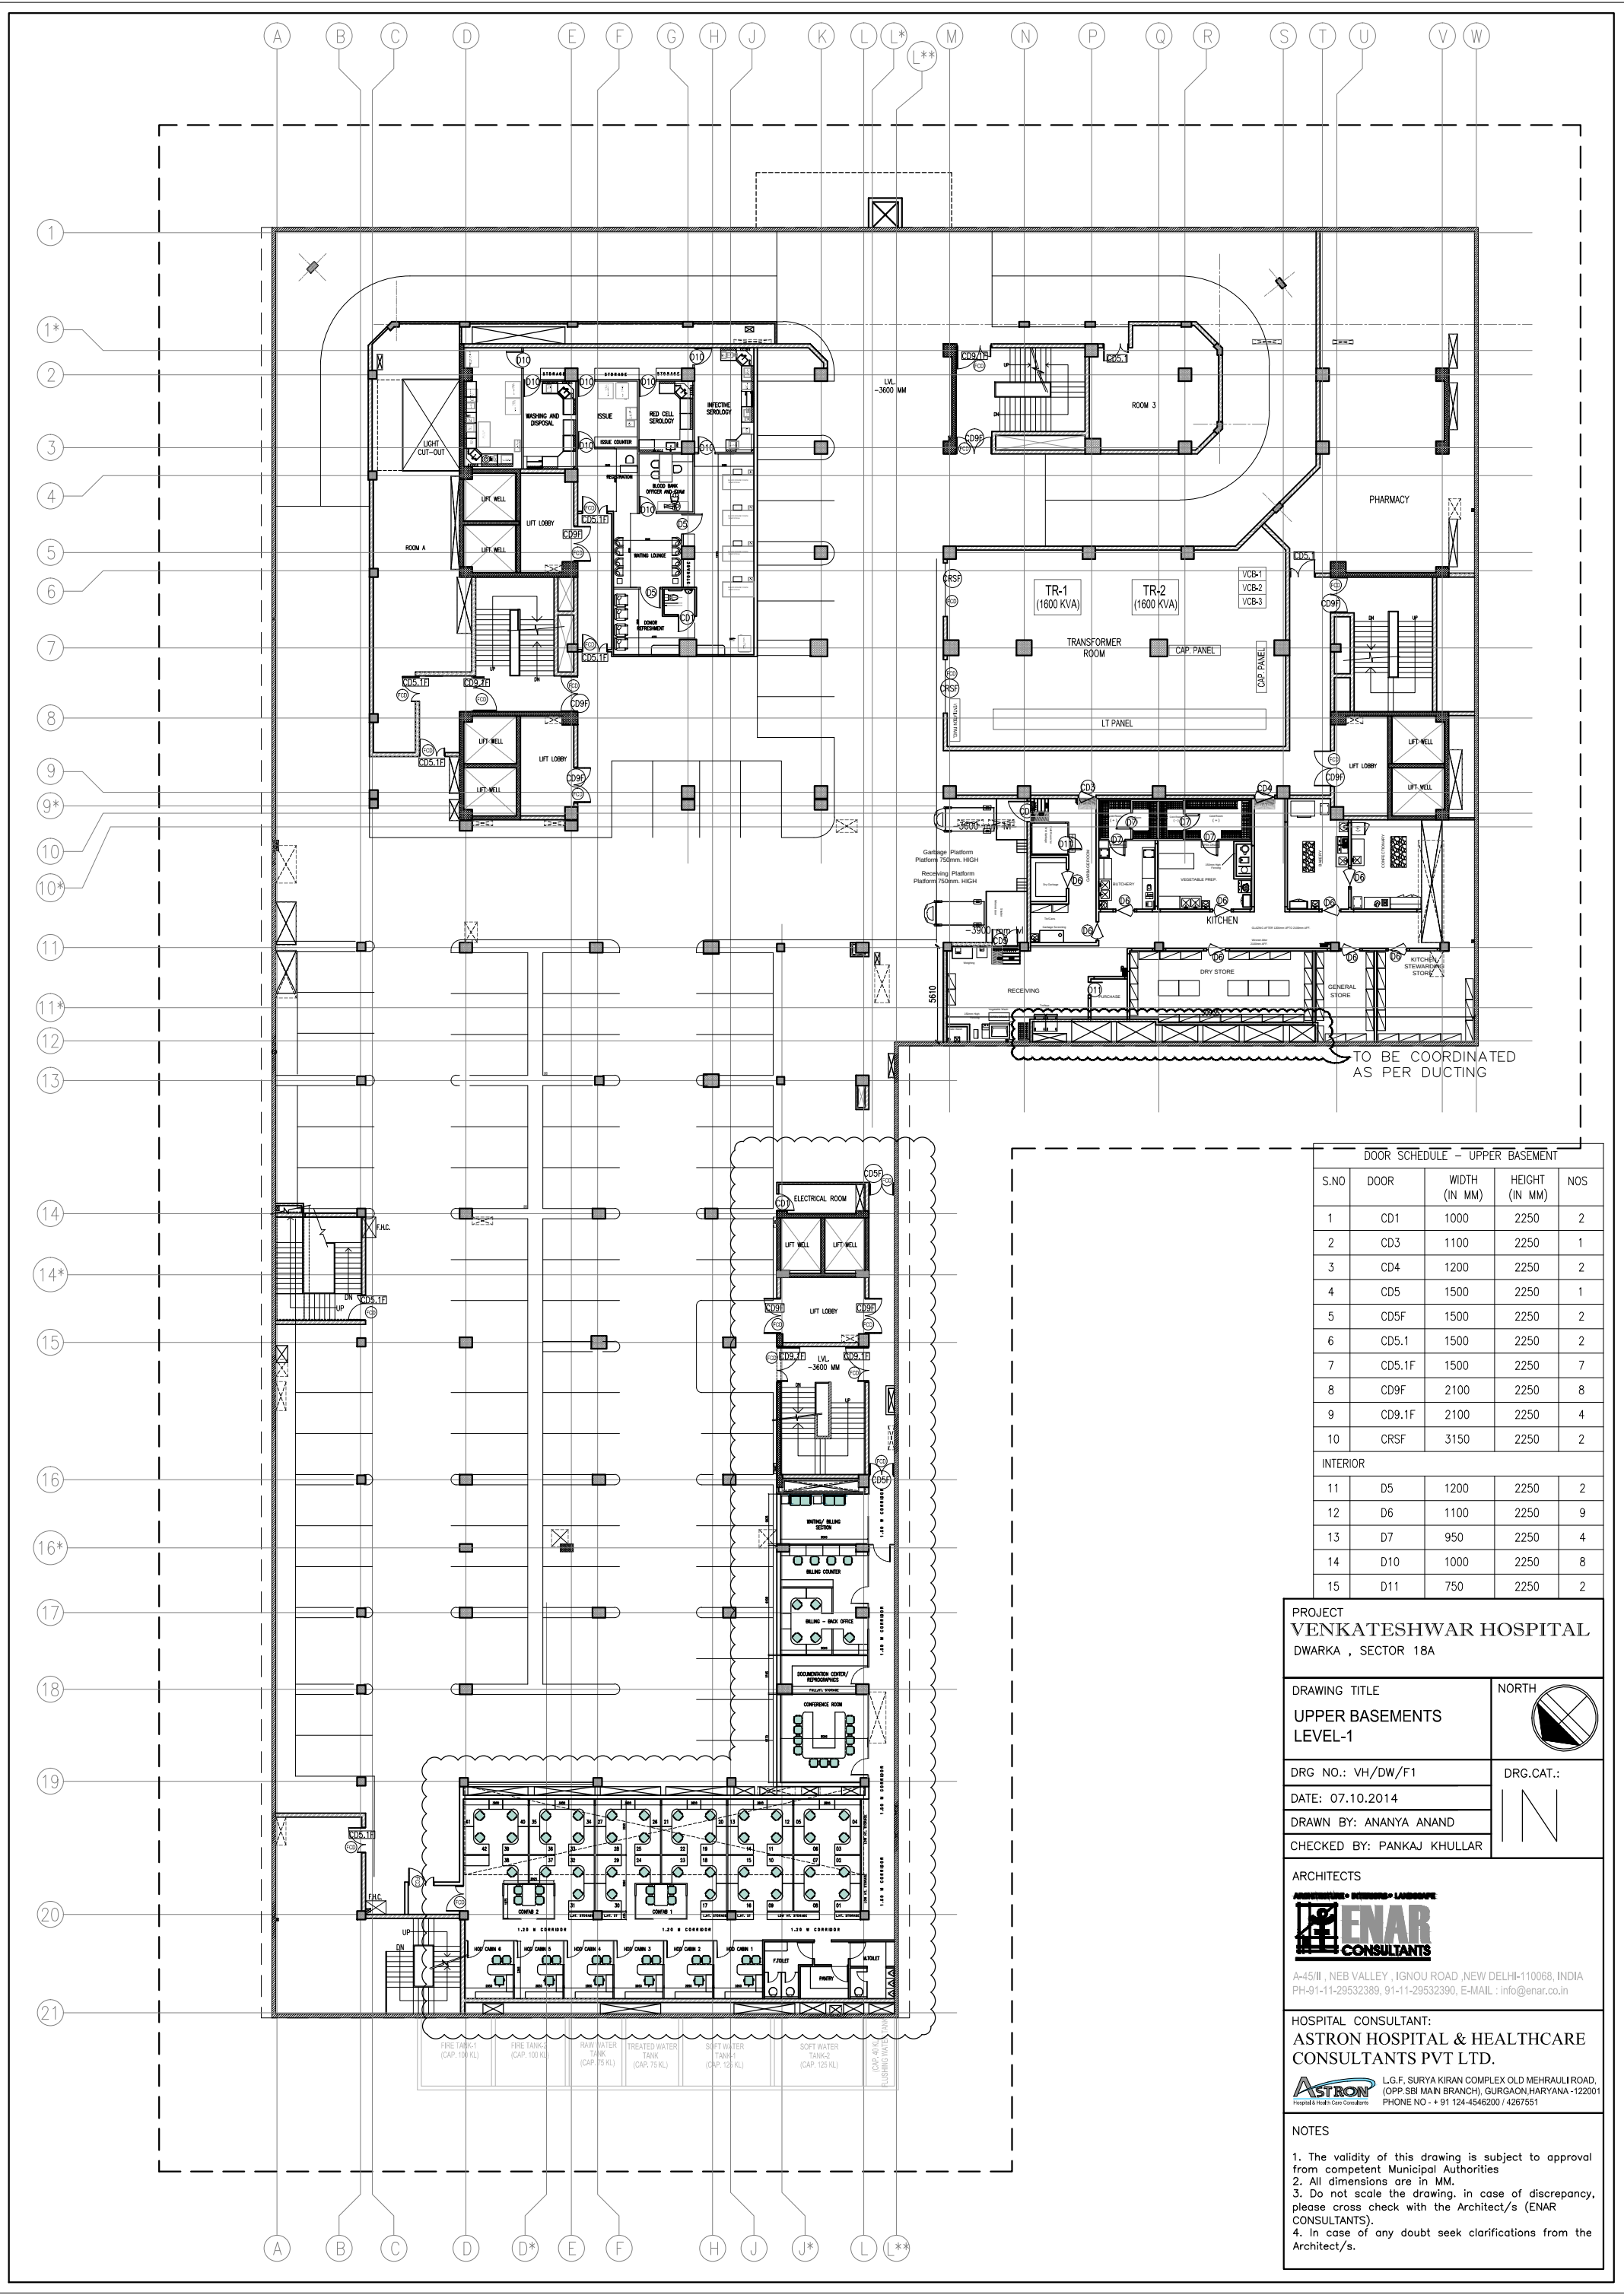

DOOR SCHEDULE - UPPER BASEMENT				
S.NO	DOOR	WIDTH (IN MM)	HEIGHT (IN MM)	NOS
1	CD1	1000	2250	2
2	CD3	1100	2250	1
3	CD4	1200	2250	2
4	CD5	1500	2250	1
5	CD5F	1500	2250	2
6	CD5.1	1500	2250	2
7	CD5.1F	1500	2250	7
8	CD9F	2100	2250	8
9	CD9.1F	2100	2250	4
10	CRSF	3150	2250	2
INTERIOR				
11	D5	1200	2250	2
12	D6	1100	2250	9
13	D7	950	2250	4
14	D10	1000	2250	8
15	D11	750	2250	2

PROJECT
VENKATESHWAR HOSPITAL
DWARKA , SECTOR 18A

DRAWING TITLE UPPER BASEMENTS LEVEL-1	NORTH
DRG NO.: VH/DW/F1	
DATE: 07.10.2014	DRG.CAT.: IN
DRAWN BY: ANANYA ANAND	
CHECKED BY: PANKAJ KHULLAR	

ARCHITECTS


ENAR CONSULTANTS

A-45/III, NEB VALLEY, IGNOU ROAD, NEW DELHI-110068, INDIA
PH-91-11-29532389, 91-11-29532390, E-MAIL : info@enar.co.in


HOSPITAL CONSULTANT:
ASTRON HOSPITAL & HEALTHCARE CONSULTANTS PVT LTD.

ASTRON L.G.F. SURYA KIRAN COMPLEX OLD MEHRAULI ROAD,
(OPP.SBI MAIN BRANCH), GURGAON HARYANA -122001
PHONE NO - + 91 124-4546200 / 4267551

- NOTES
1. The validity of this drawing is subject to approval from competent Municipal Authorities
 2. All dimensions are in MM.
 3. Do not scale the drawing, in case of discrepancy, please cross check with the Architect/s (ENAR CONSULTANTS).
 4. In case of any doubt seek clarifications from the Architect/s.

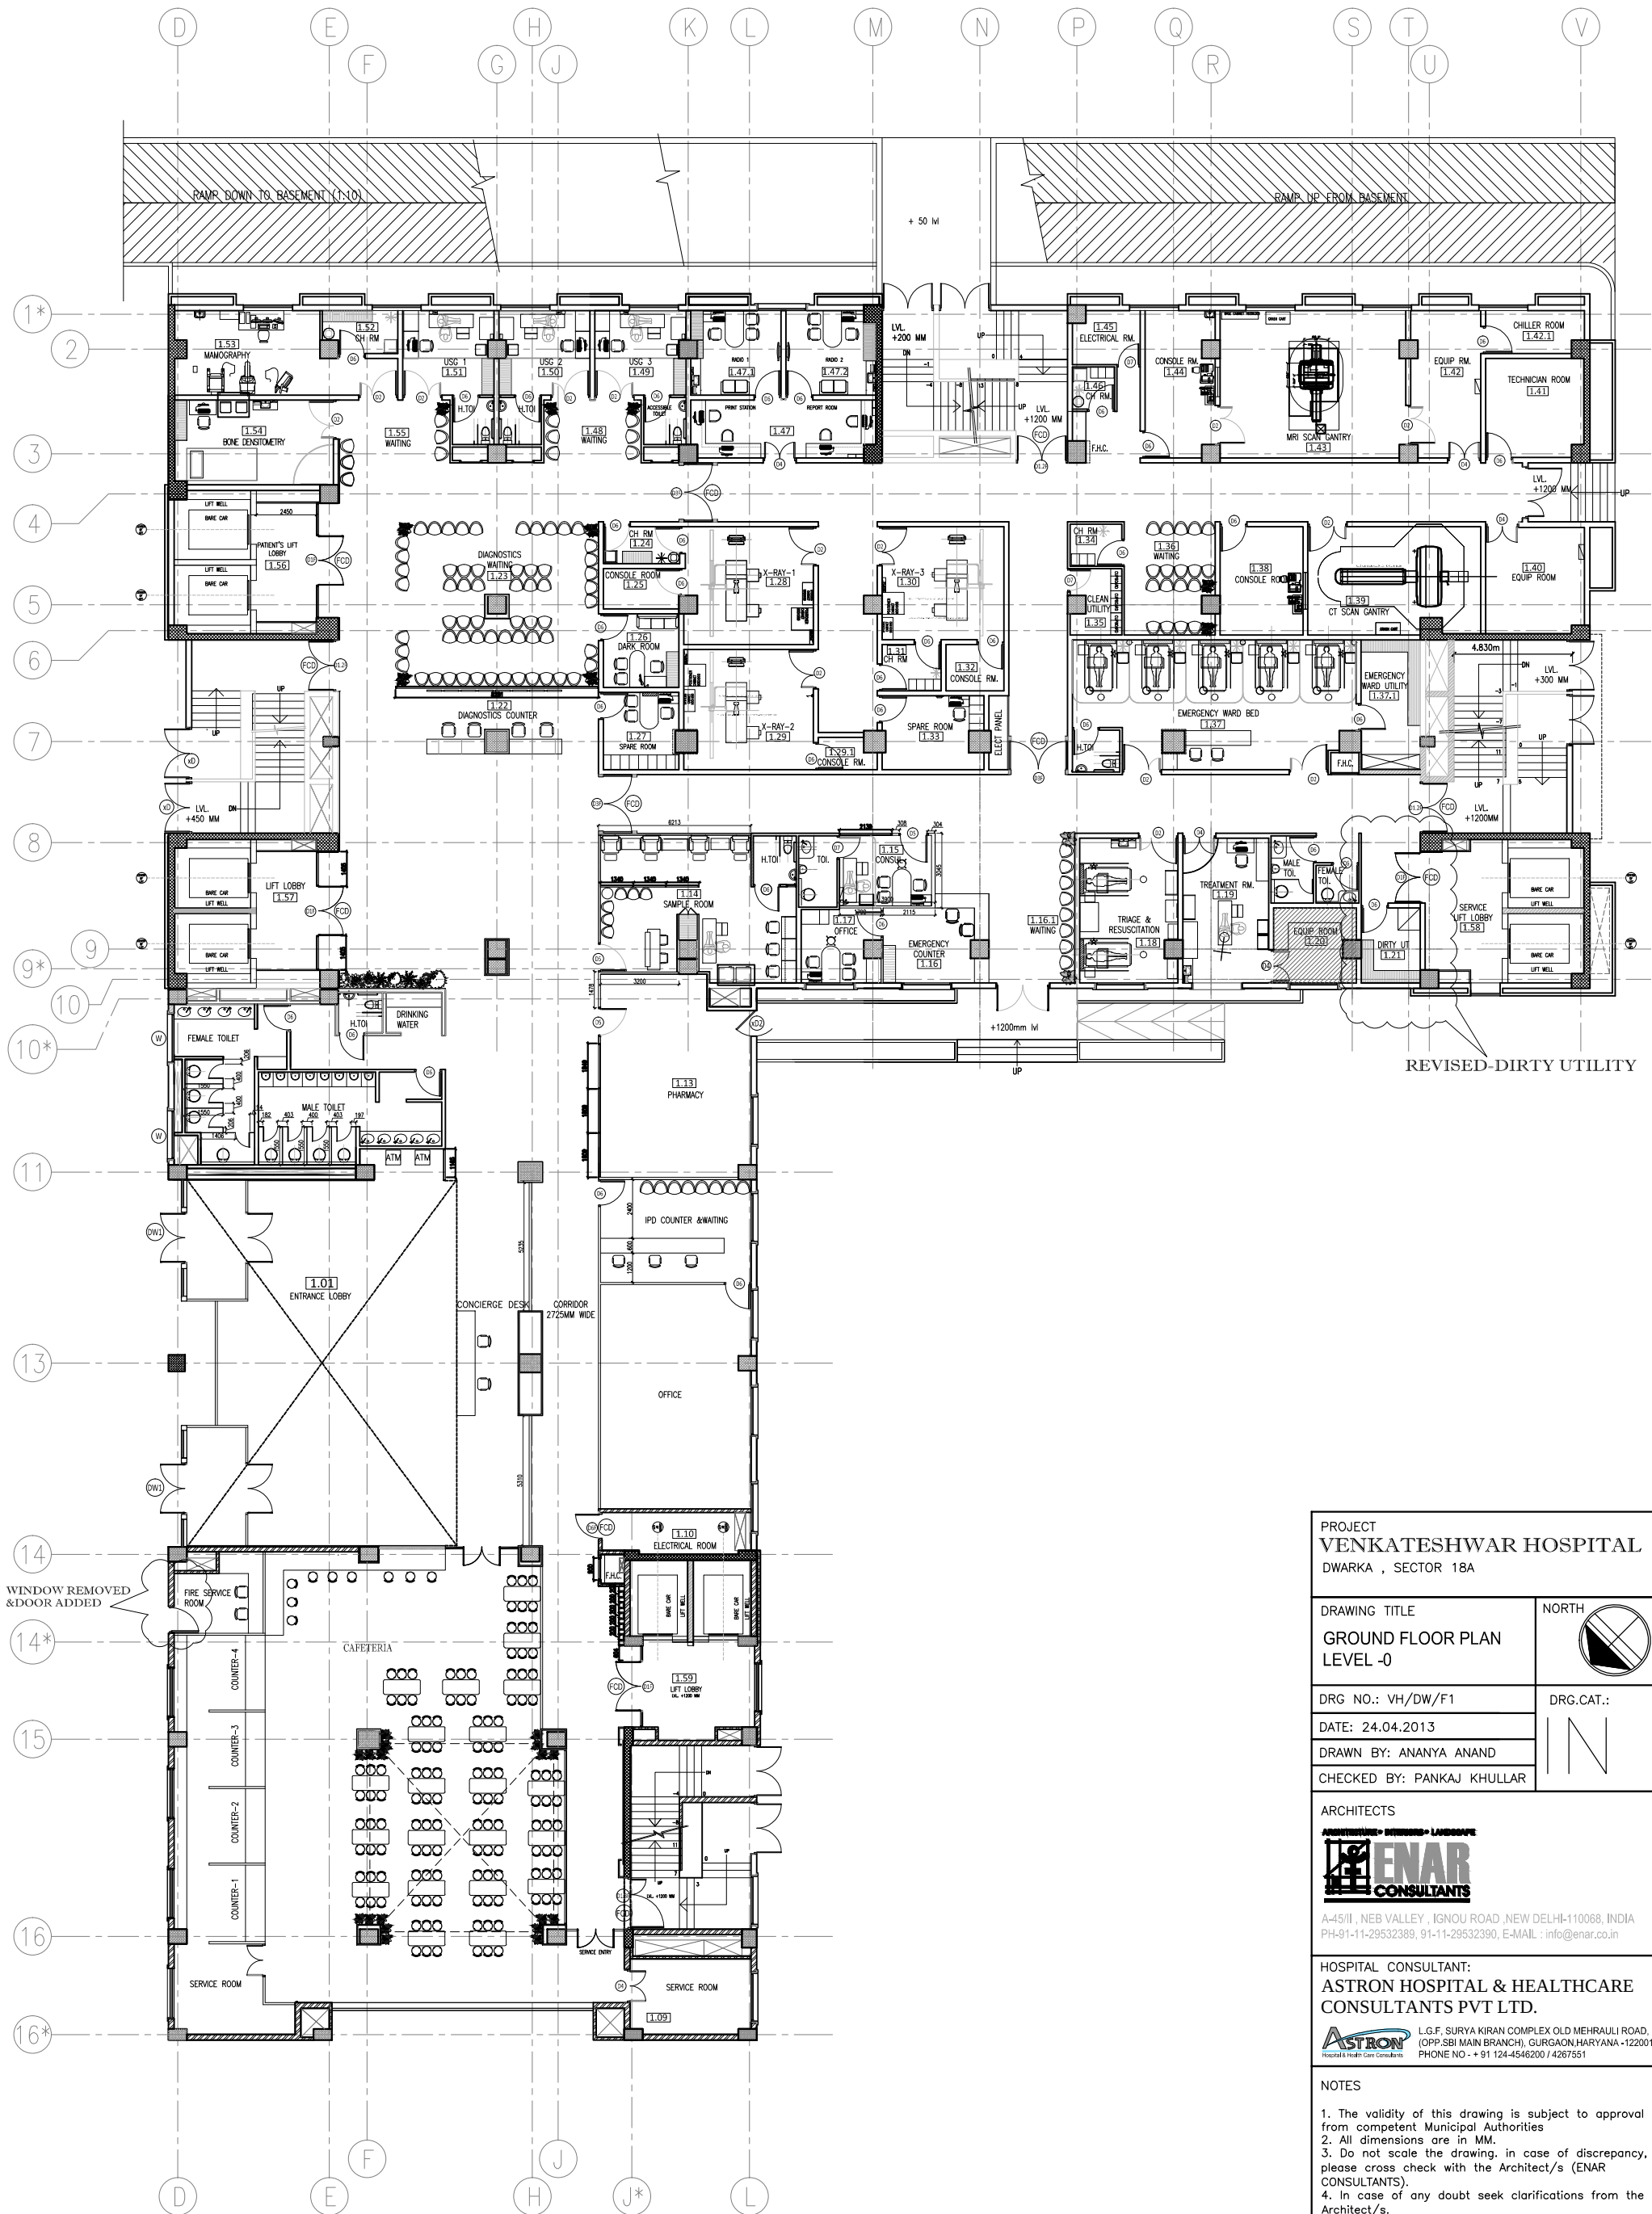


PROJECT VENKATESHWAR HOSPITAL DWARKA , SECTOR 18A	
DRAWING TITLE GROUND FLOOR PLAN LEVEL -0	NORTH
DRG NO.: VH/DW/F1	DRG.CAT.:
DATE: 24.04.2013	
DRAWN BY: ANANYA ANAND	
CHECKED BY: PANKAJ KHULLAR	
ARCHITECTS ENAR CONSULTANTS A-45/II, NEB VALLEY, IGNOU ROAD, NEW DELHI-110068, INDIA PH-91-11-29532389, 91-11-29532390, E-MAIL : info@enar.co.in	
HOSPITAL CONSULTANT: ASTRON HOSPITAL & HEALTHCARE CONSULTANTS PVT LTD. L.G.F, SURYA KIRAN COMPLEX OLD MEHRAULI ROAD, (OPP.SBI MAIN BRANCH), GURGAON,HARYANA -122001 PHONE NO - + 91 124-4546200 / 4267551	
NOTES 1. The validity of this drawing is subject to approval from competent Municipal Authorities 2. All dimensions are in MM. 3. Do not scale the drawing. in case of discrepancy, please cross check with the Architect/s (ENAR CONSULTANTS). 4. In case of any doubt seek clarifications from the Architect/s.	

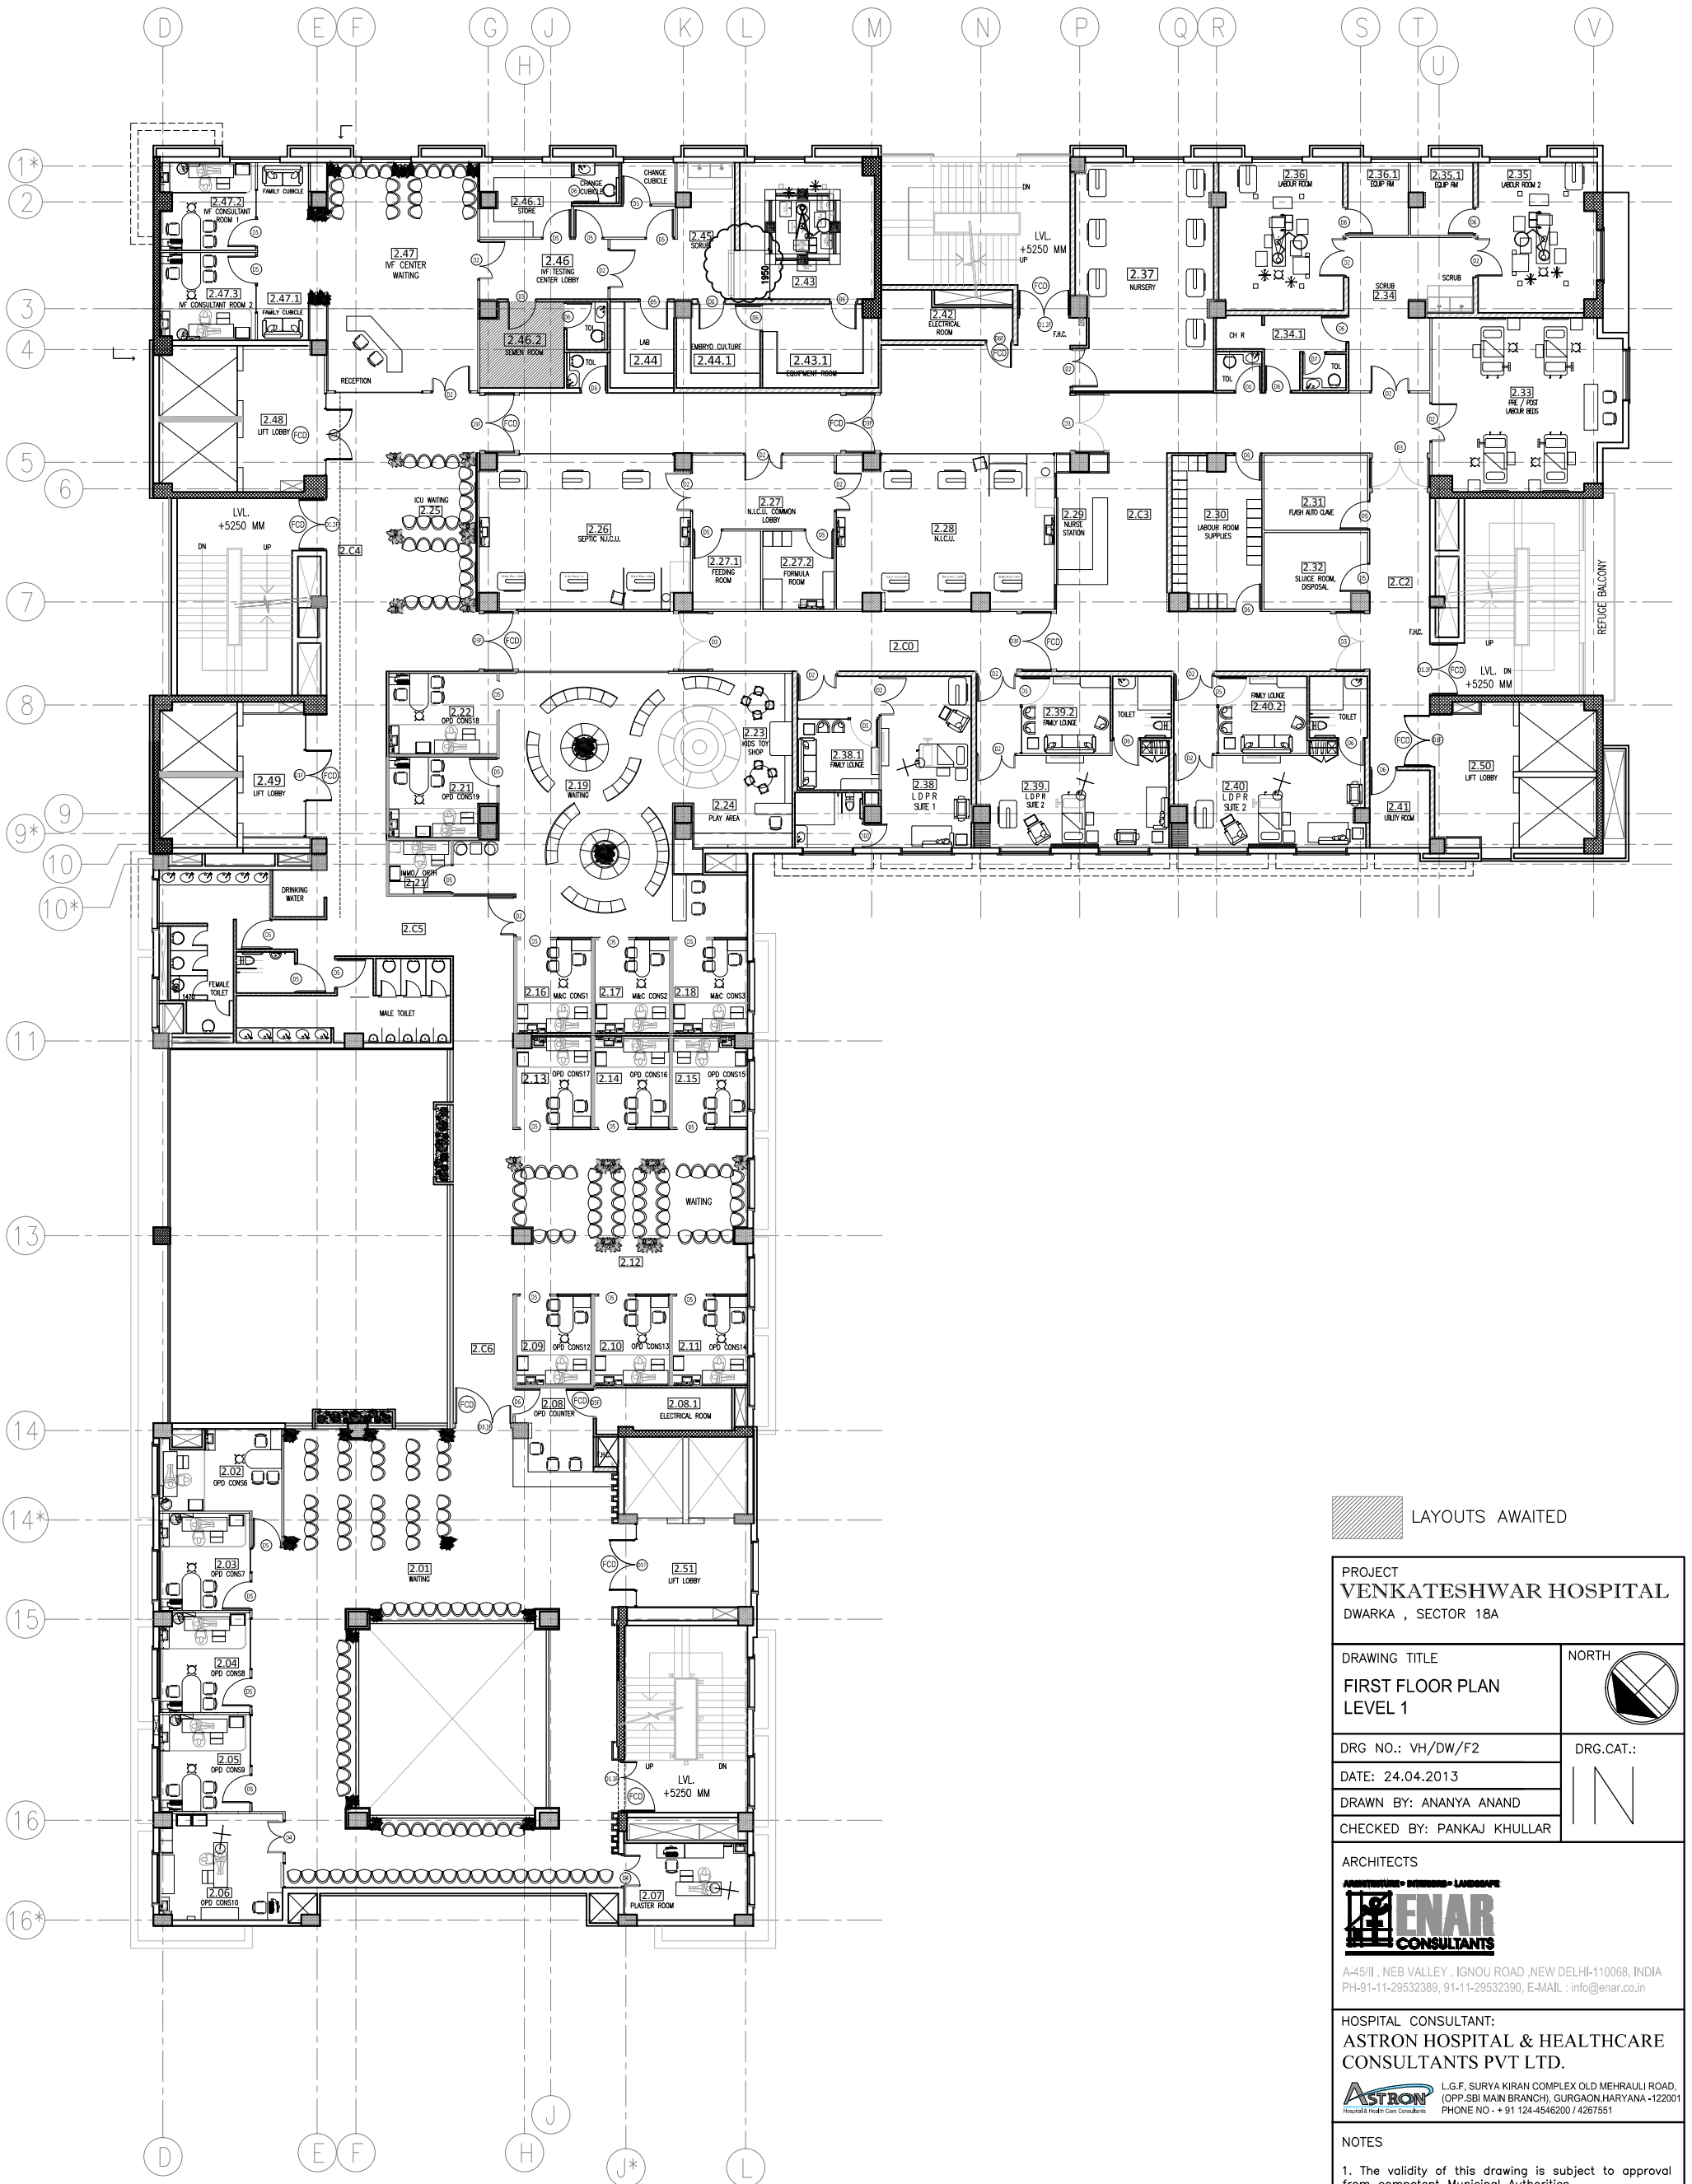

LAYOUTS AWAITED

PROJECT VENKATESHWAR HOSPITAL DWARKA , SECTOR 18A	
DRAWING TITLE FIRST FLOOR PLAN LEVEL 1	NORTH
DRG NO.: VH/DW/F2	DRG.CAT.:
DATE: 24.04.2013	IN
DRAWN BY: ANANYA ANAND	
CHECKED BY: PANKAJ KHULLAR	
ARCHITECTS ENAR CONSULTANTS A-45/II, NEB VALLEY , IGNOU ROAD , NEW DELHI-110068, INDIA PH-91-11-29532389, 91-11-29532390, E-MAIL : info@enar.co.in	
HOSPITAL CONSULTANT: ASTRON HOSPITAL & HEALTHCARE CONSULTANTS PVT LTD. L.G.F, SURYA KIRAN COMPLEX OLD MEHRAULI ROAD, (OPP.SBI MAIN BRANCH), GURGAON,HARYANA -122001 PHONE NO - + 91 124-4546200 / 4267551	
NOTES 1. The validity of this drawing is subject to approval from competent Municipal Authorities 2. All dimensions are in MM. 3. Do not scale the drawing. in case of discrepancy, please cross check with the Architect/s (ENAR CONSULTANTS). 4. In case of any doubt seek clarifications from the Architect/s.	

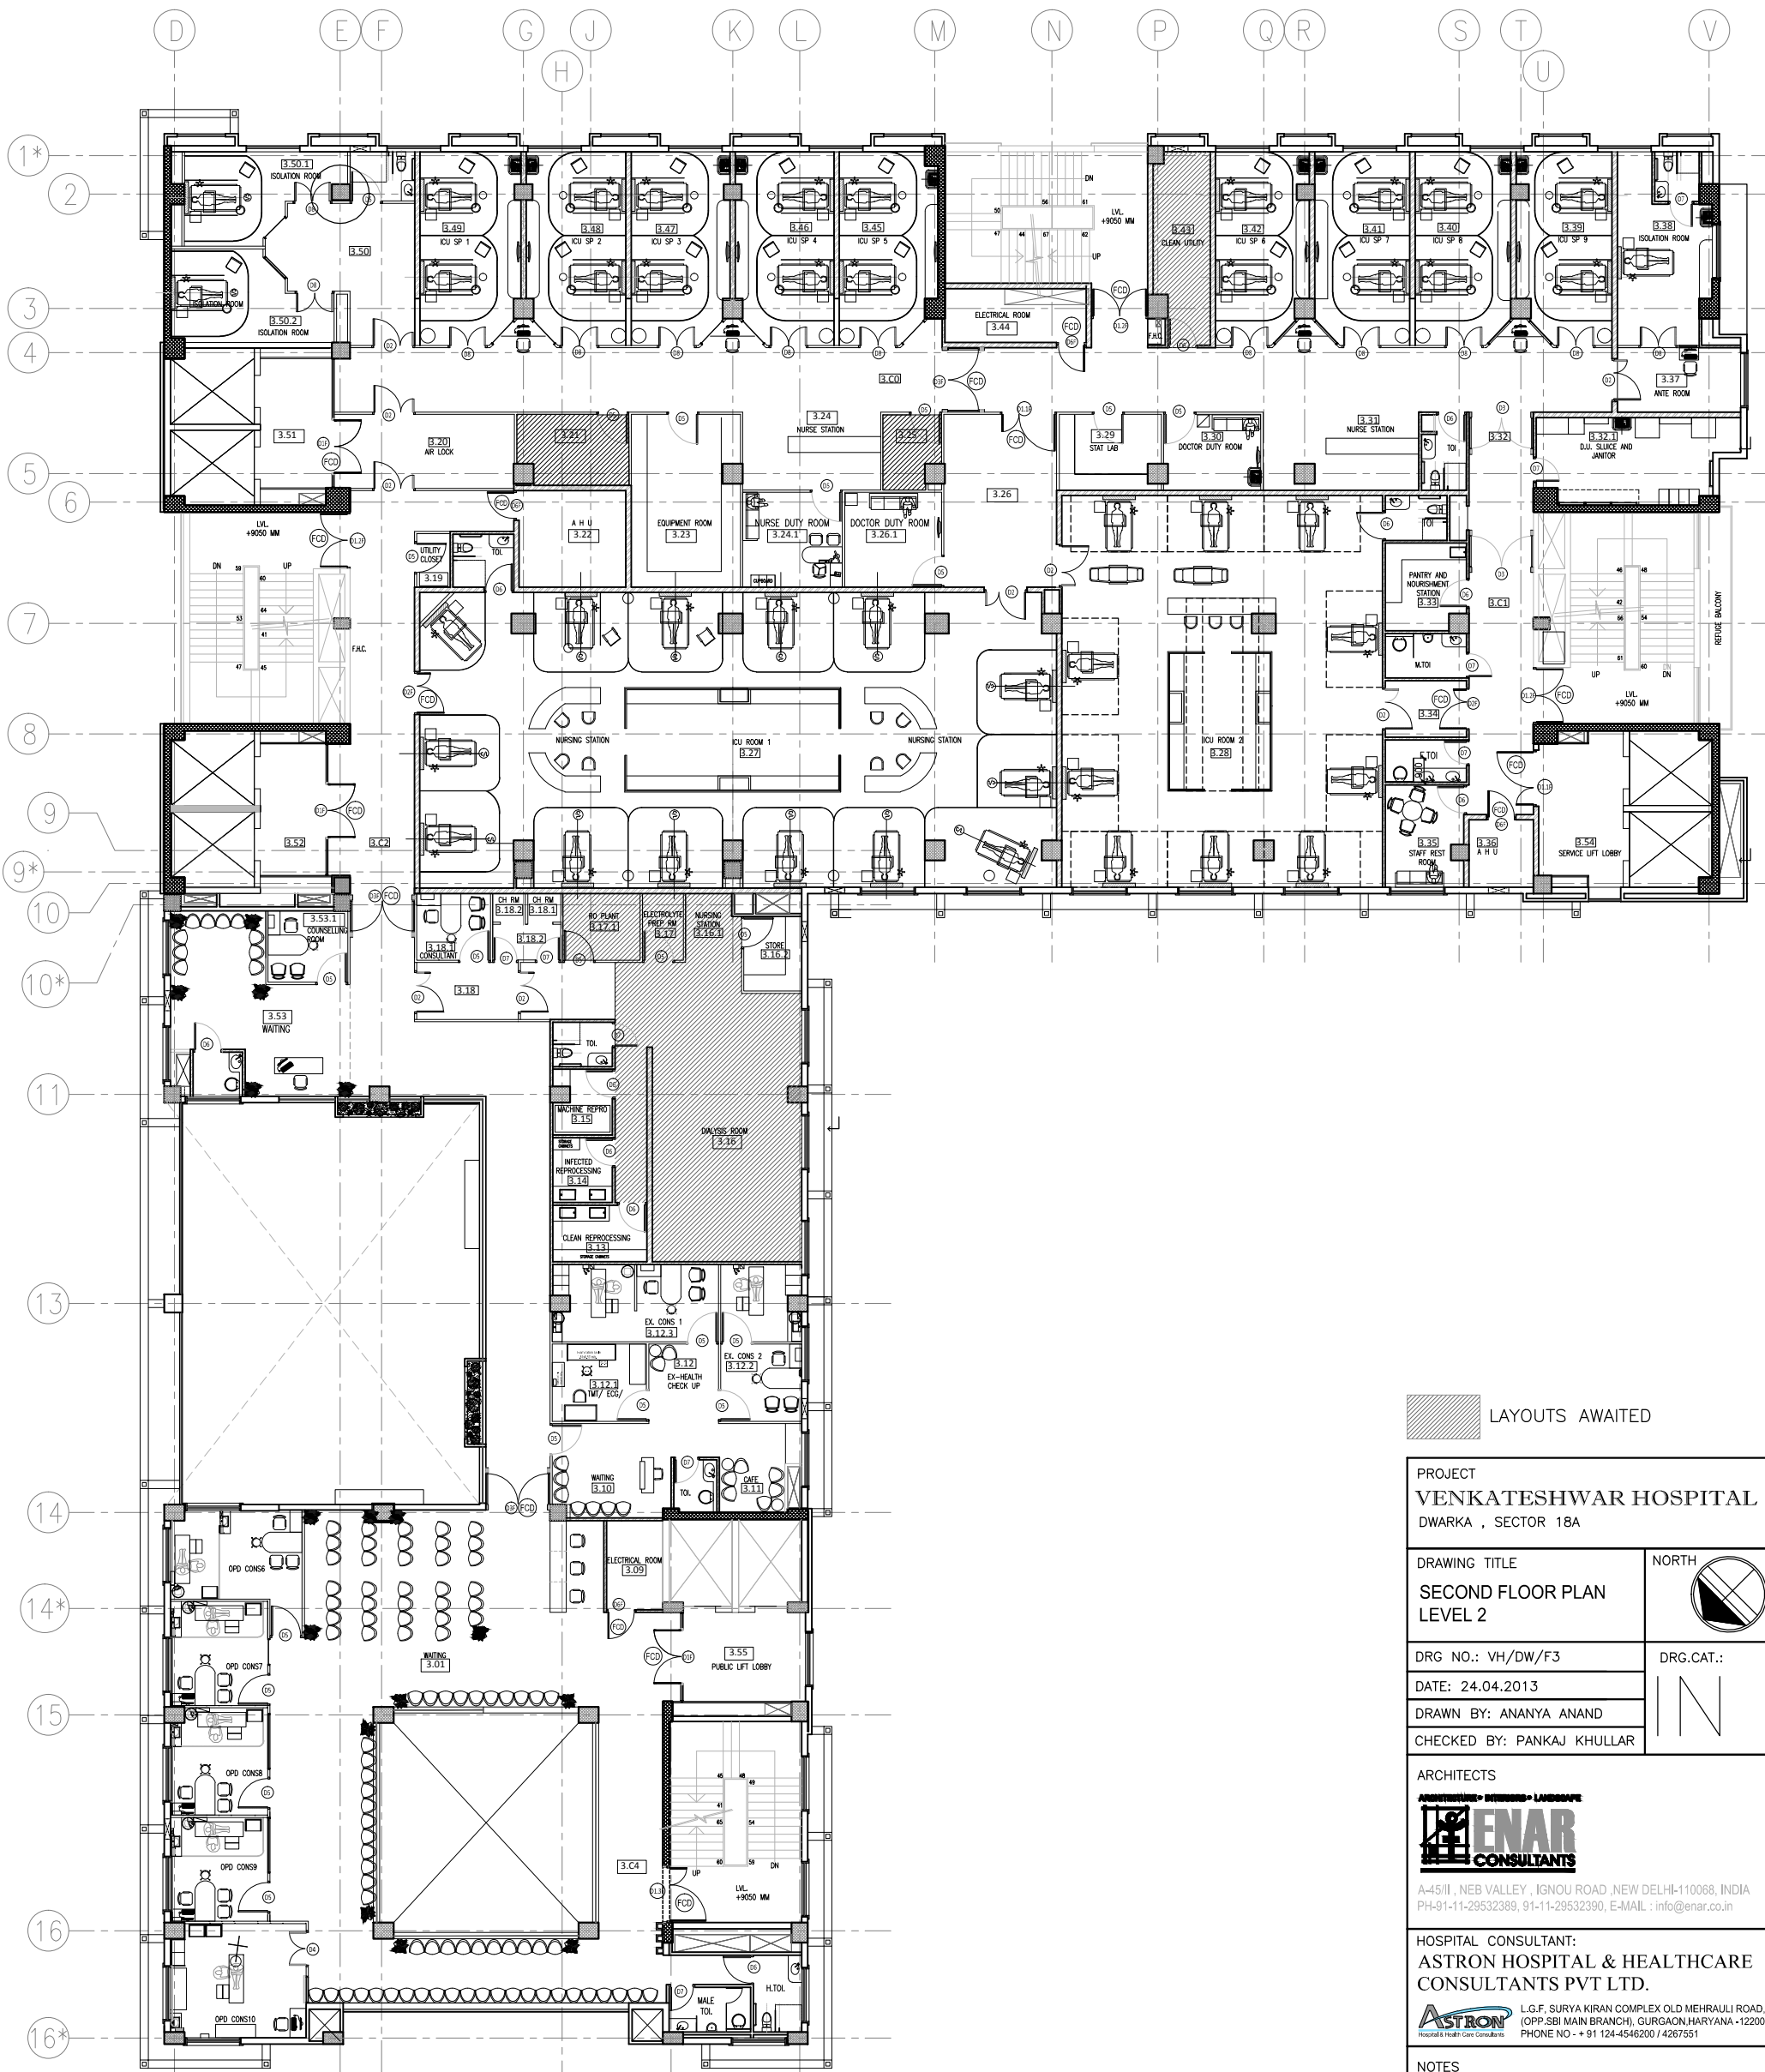

LAYOUTS AWAITED

PROJECT
VENKATESHWAR HOSPITAL
DWARKA , SECTOR 18A

DRAWING TITLE
**SECOND FLOOR PLAN
LEVEL 2**



DRG NO.: VH/DW/F3

DRG.CAT.:

DATE: 24.04.2013

DRAWN BY: ANANYA ANAND

CHECKED BY: PANKAJ KHULLAR

ARCHITECTS




A-45/II, NEB VALLEY , IGNOU ROAD , NEW DELHI-110068, INDIA
PH-91-11-29532389, 91-11-29532390, E-MAIL : info@enar.co.in

HOSPITAL CONSULTANT:
**ASTRON HOSPITAL & HEALTHCARE
CONSULTANTS PVT LTD.**


ASTRON L.G.F, SURYA KIRAN COMPLEX OLD MEHRAULI ROAD,
HOSPITAL & Health Care Consultants (OPP.SBI MAIN BRANCH), GURGAON,HARYANA -122001
PHONE NO - + 91 124-4546200 / 4267551

NOTES

1. The validity of this drawing is subject to approval from competent Municipal Authorities
2. All dimensions are in MM.
3. Do not scale the drawing. in case of discrepancy, please cross check with the Architect/s (ENAR CONSULTANTS).
4. In case of any doubt seek clarifications from the Architect/s.

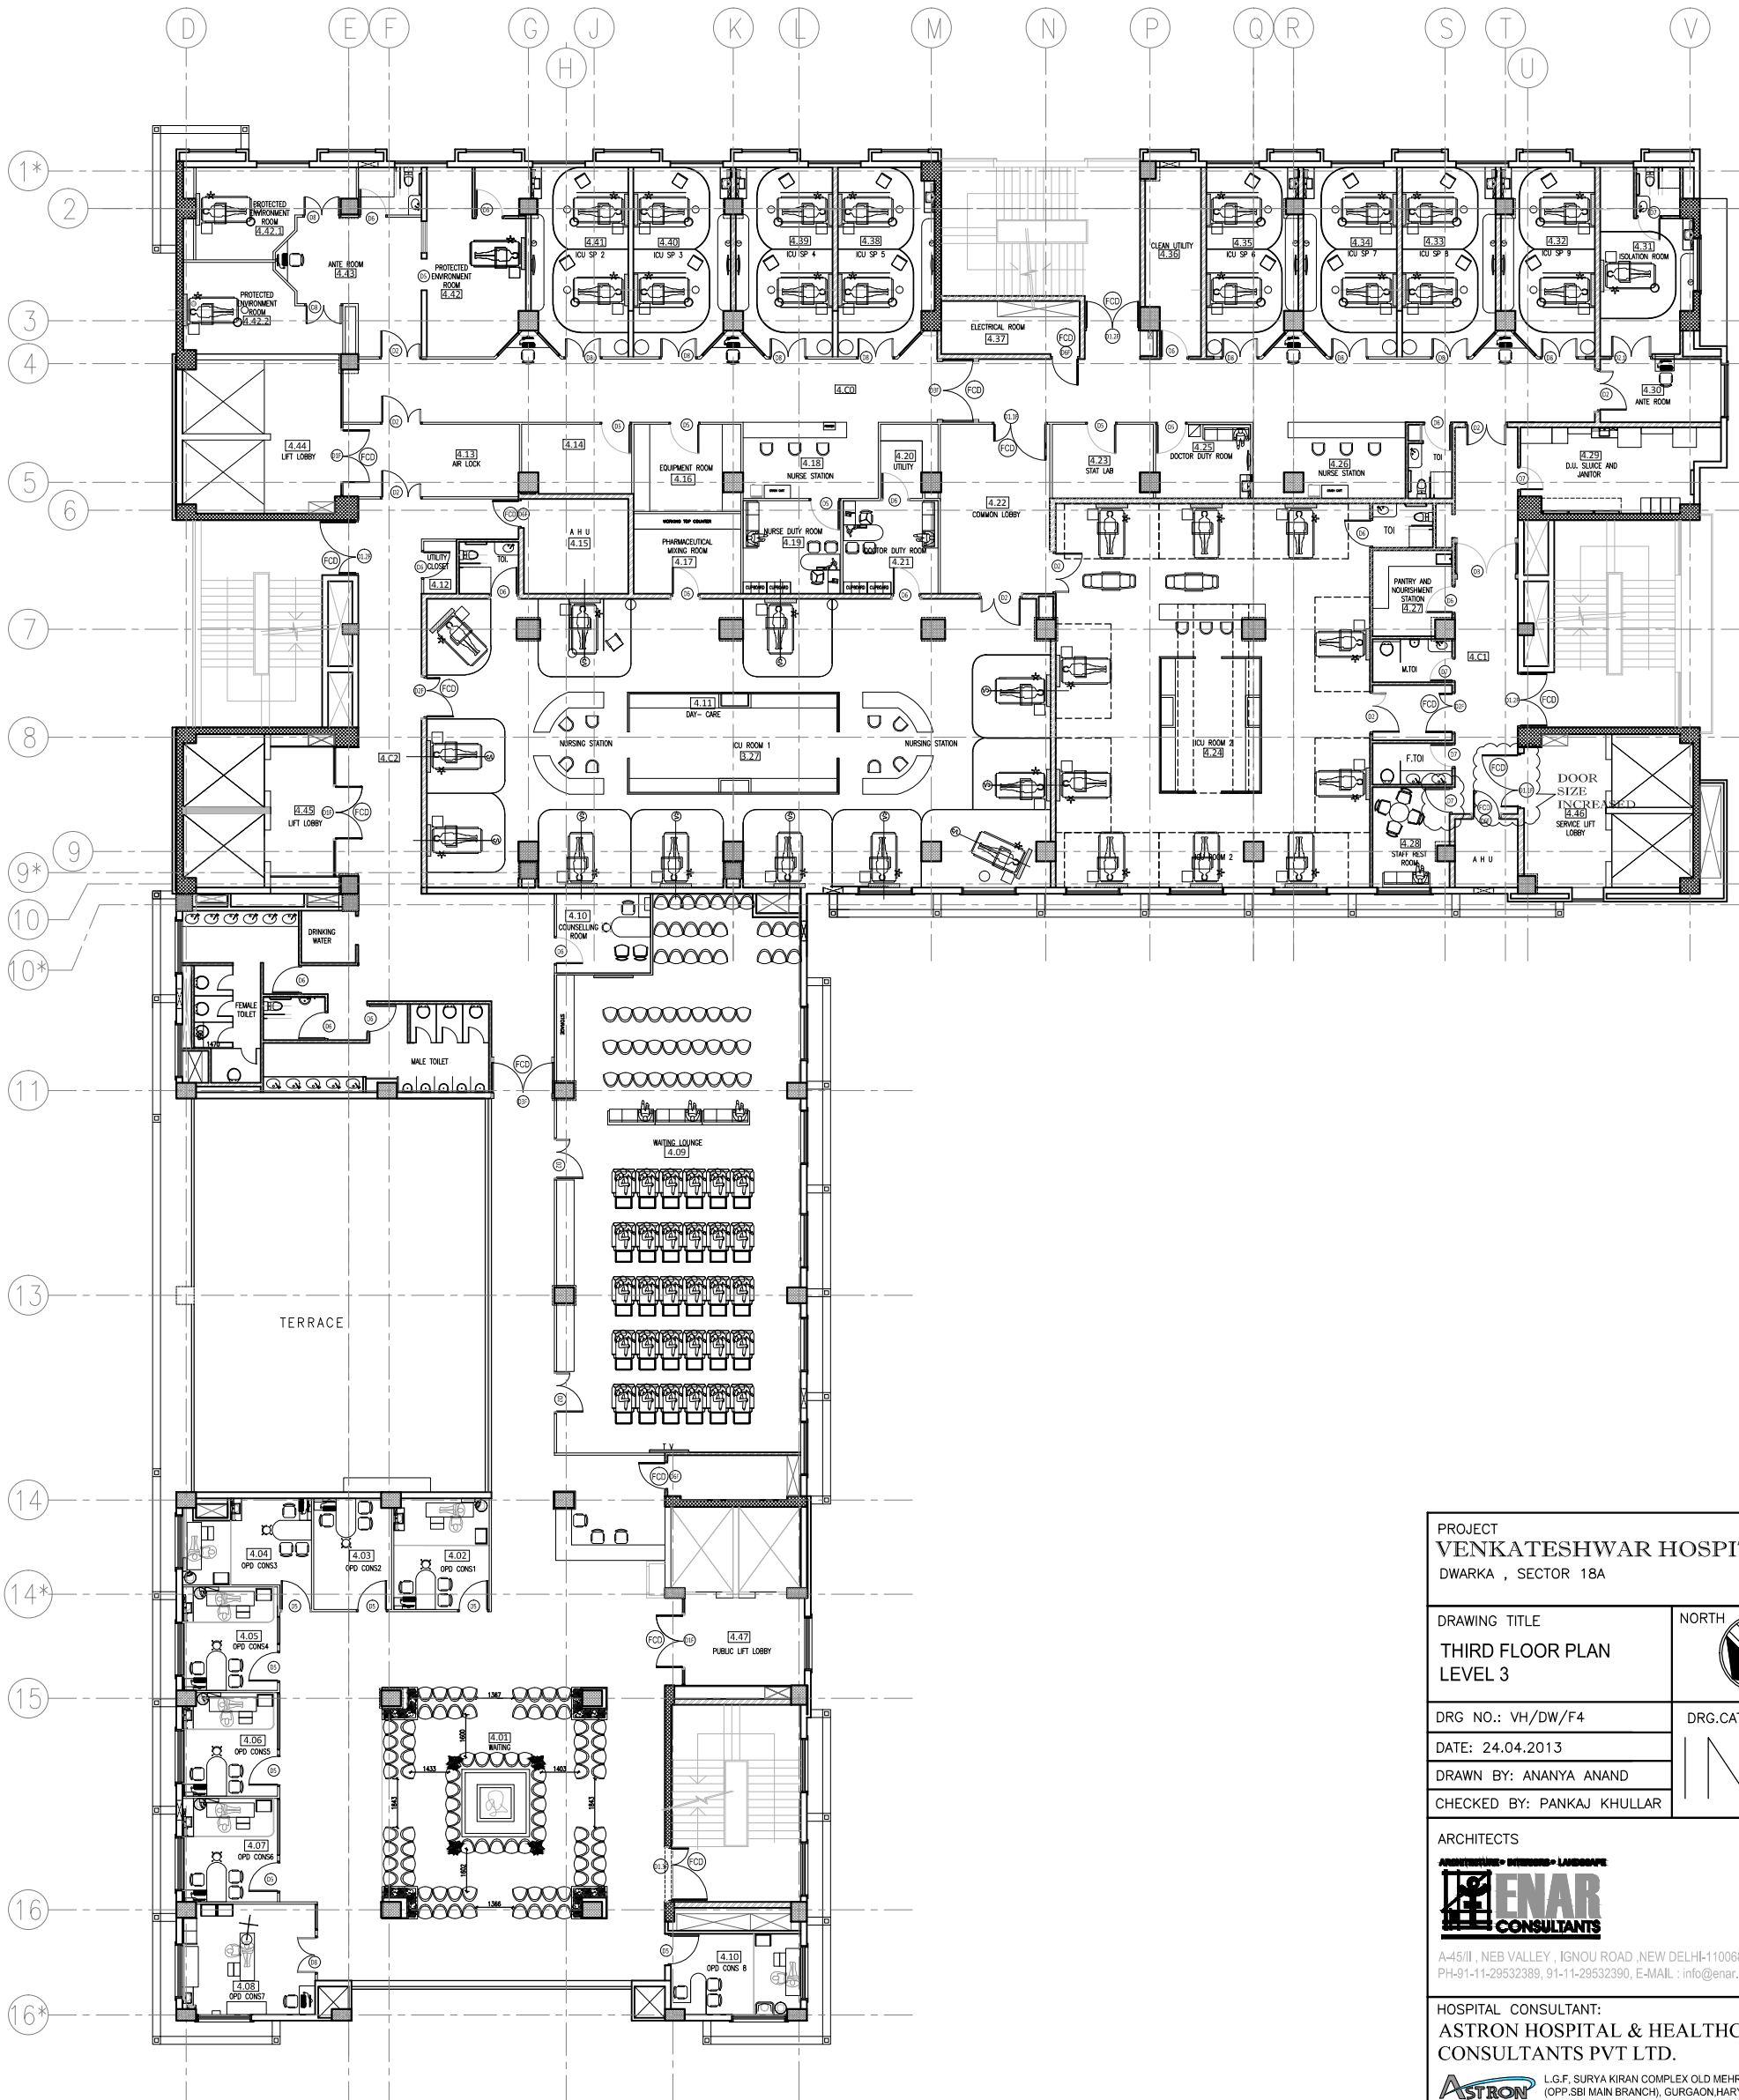

PROJECT VENKATESHWAR HOSPITAL DWARKA , SECTOR 18A	
DRAWING TITLE THIRD FLOOR PLAN LEVEL 3	NORTH
DRG NO.: VH/DW/F4	DRG.CAT.:
DATE: 24.04.2013	
DRAWN BY: ANANYA ANAND	
CHECKED BY: PANKAJ KHULLAR	
ARCHITECTS ENAR CONSULTANTS A-45/II, NEB VALLEY, IGNOU ROAD, NEW DELHI-110068, INDIA PH-91-11-29532389, 91-11-29532390, E-MAIL : info@enar.co.in	
HOSPITAL CONSULTANT: ASTRON HOSPITAL & HEALTHCARE CONSULTANTS PVT LTD. L.G.F, SURYA KIRAN COMPLEX OLD MEHRAULI ROAD, (OPP.SBI MAIN BRANCH), GURGAON,HARYANA -122001 PHONE NO. - + 91 124-4546200 / 4267551	
NOTES 1. The validity of this drawing is subject to approval from competent Municipal Authorities 2. All dimensions are in MM. 3. Do not scale the drawing. in case of discrepancy, please cross check with the Architect/s (ENAR CONSULTANTS). 4. In case of any doubt seek clarifications from the Architect/s.	

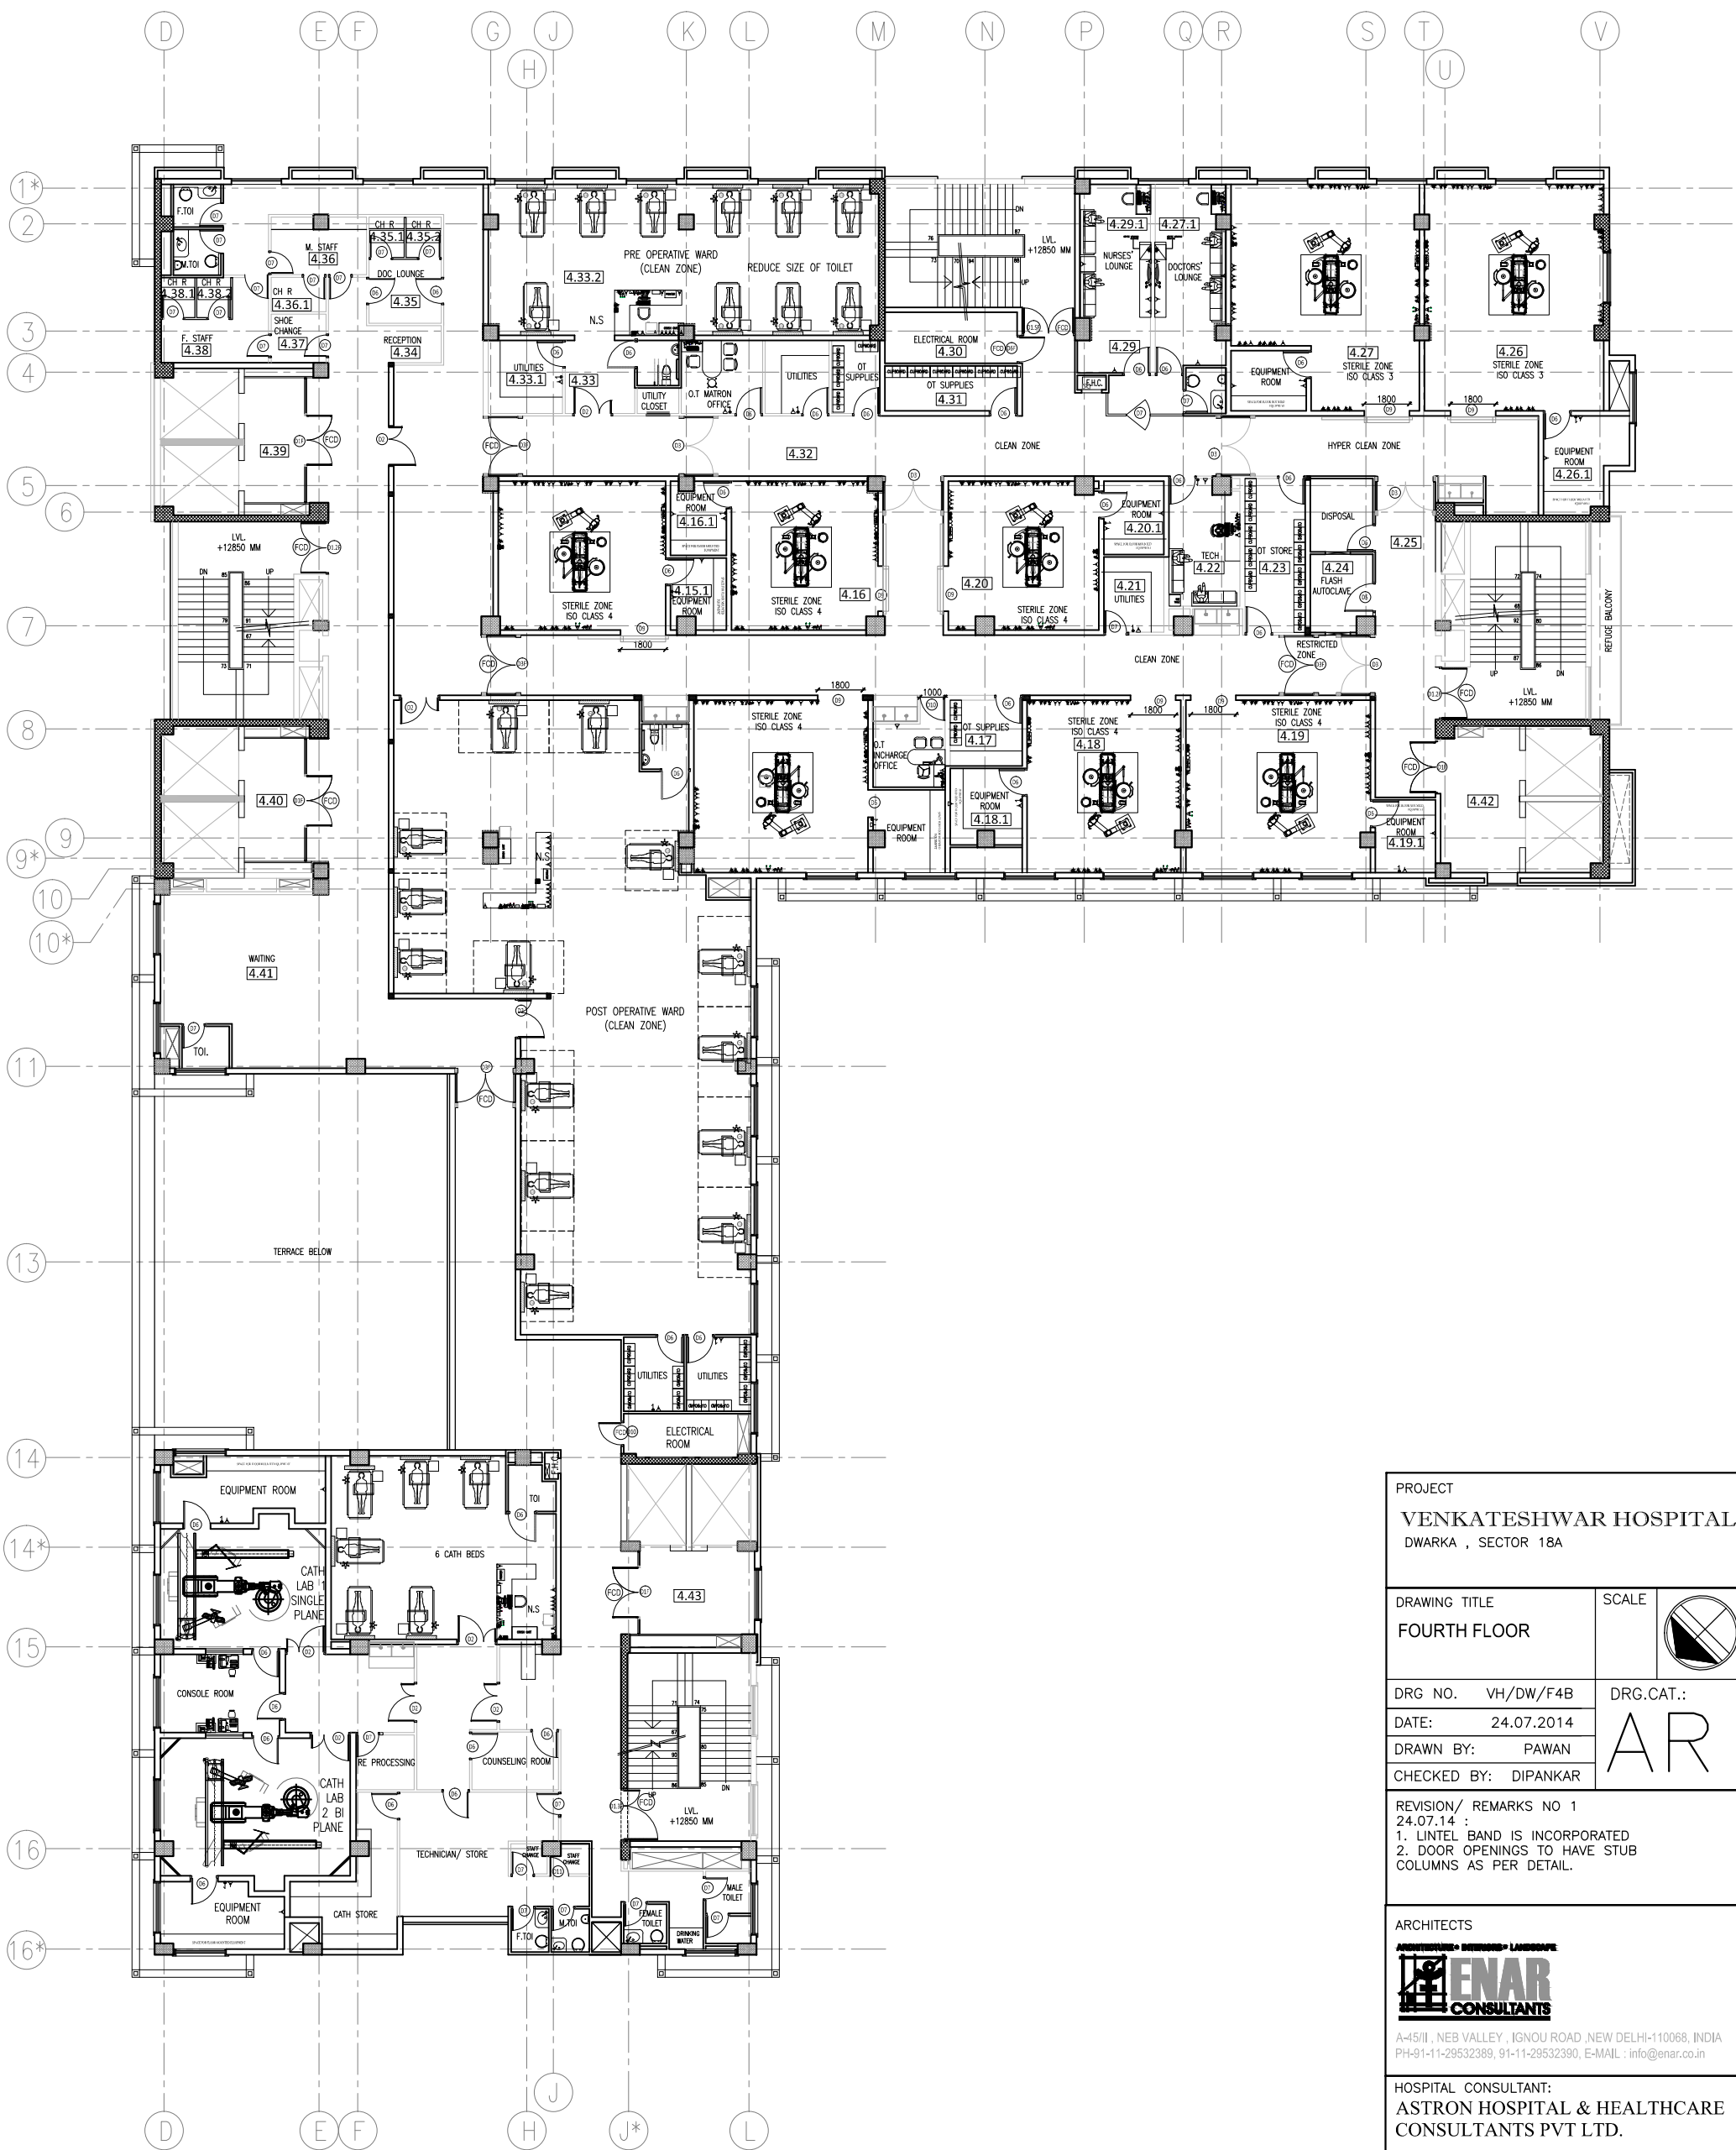

PROJECT
VENKATESHWAR HOSPITAL
DWARKA , SECTOR 18A

DRAWING TITLE FOURTH FLOOR	SCALE
--------------------------------------	-----------

DRG NO. VH/DW/F4B	DRG.CAT.:
DATE: 24.07.2014	AR
DRAWN BY: PAWAN	
CHECKED BY: DIPANKAR	


REVISION/ REMARKS NO 1
24.07.14 :
1. LINTEL BAND IS INCORPORATED
2. DOOR OPENINGS TO HAVE STUB
COLUMNS AS PER DETAIL.

ARCHITECTS
ENAR CONSULTANTS
A-45/II, NEB VALLEY , IGNOU ROAD , NEW DELHI-110068, INDIA
PH-91-11-29532389, 91-11-29532390, E-MAIL : info@enar.co.in

HOSPITAL CONSULTANT:
**ASTRON HOSPITAL & HEALTHCARE
CONSULTANTS PVT LTD.**

L.G.F. SURYA KIRAN COMPLEX OLD MEHRAULI ROAD,
(OPP.SBI MAIN BRANCH), GURGAON,HARYANA -122001
PHONE NO - + 91 124-4546200 / 4267551

NOTES
1. The validity of this drawing is subject to approval
from competent Municipal Authorities
2. All dimensions are in MM.
3. Do not scale the drawing, in case of discrepancy,
please cross check with the Architect/s (ENAR
CONSULTANTS).
4. In case of any doubt seek clarifications from the
Architect/s.

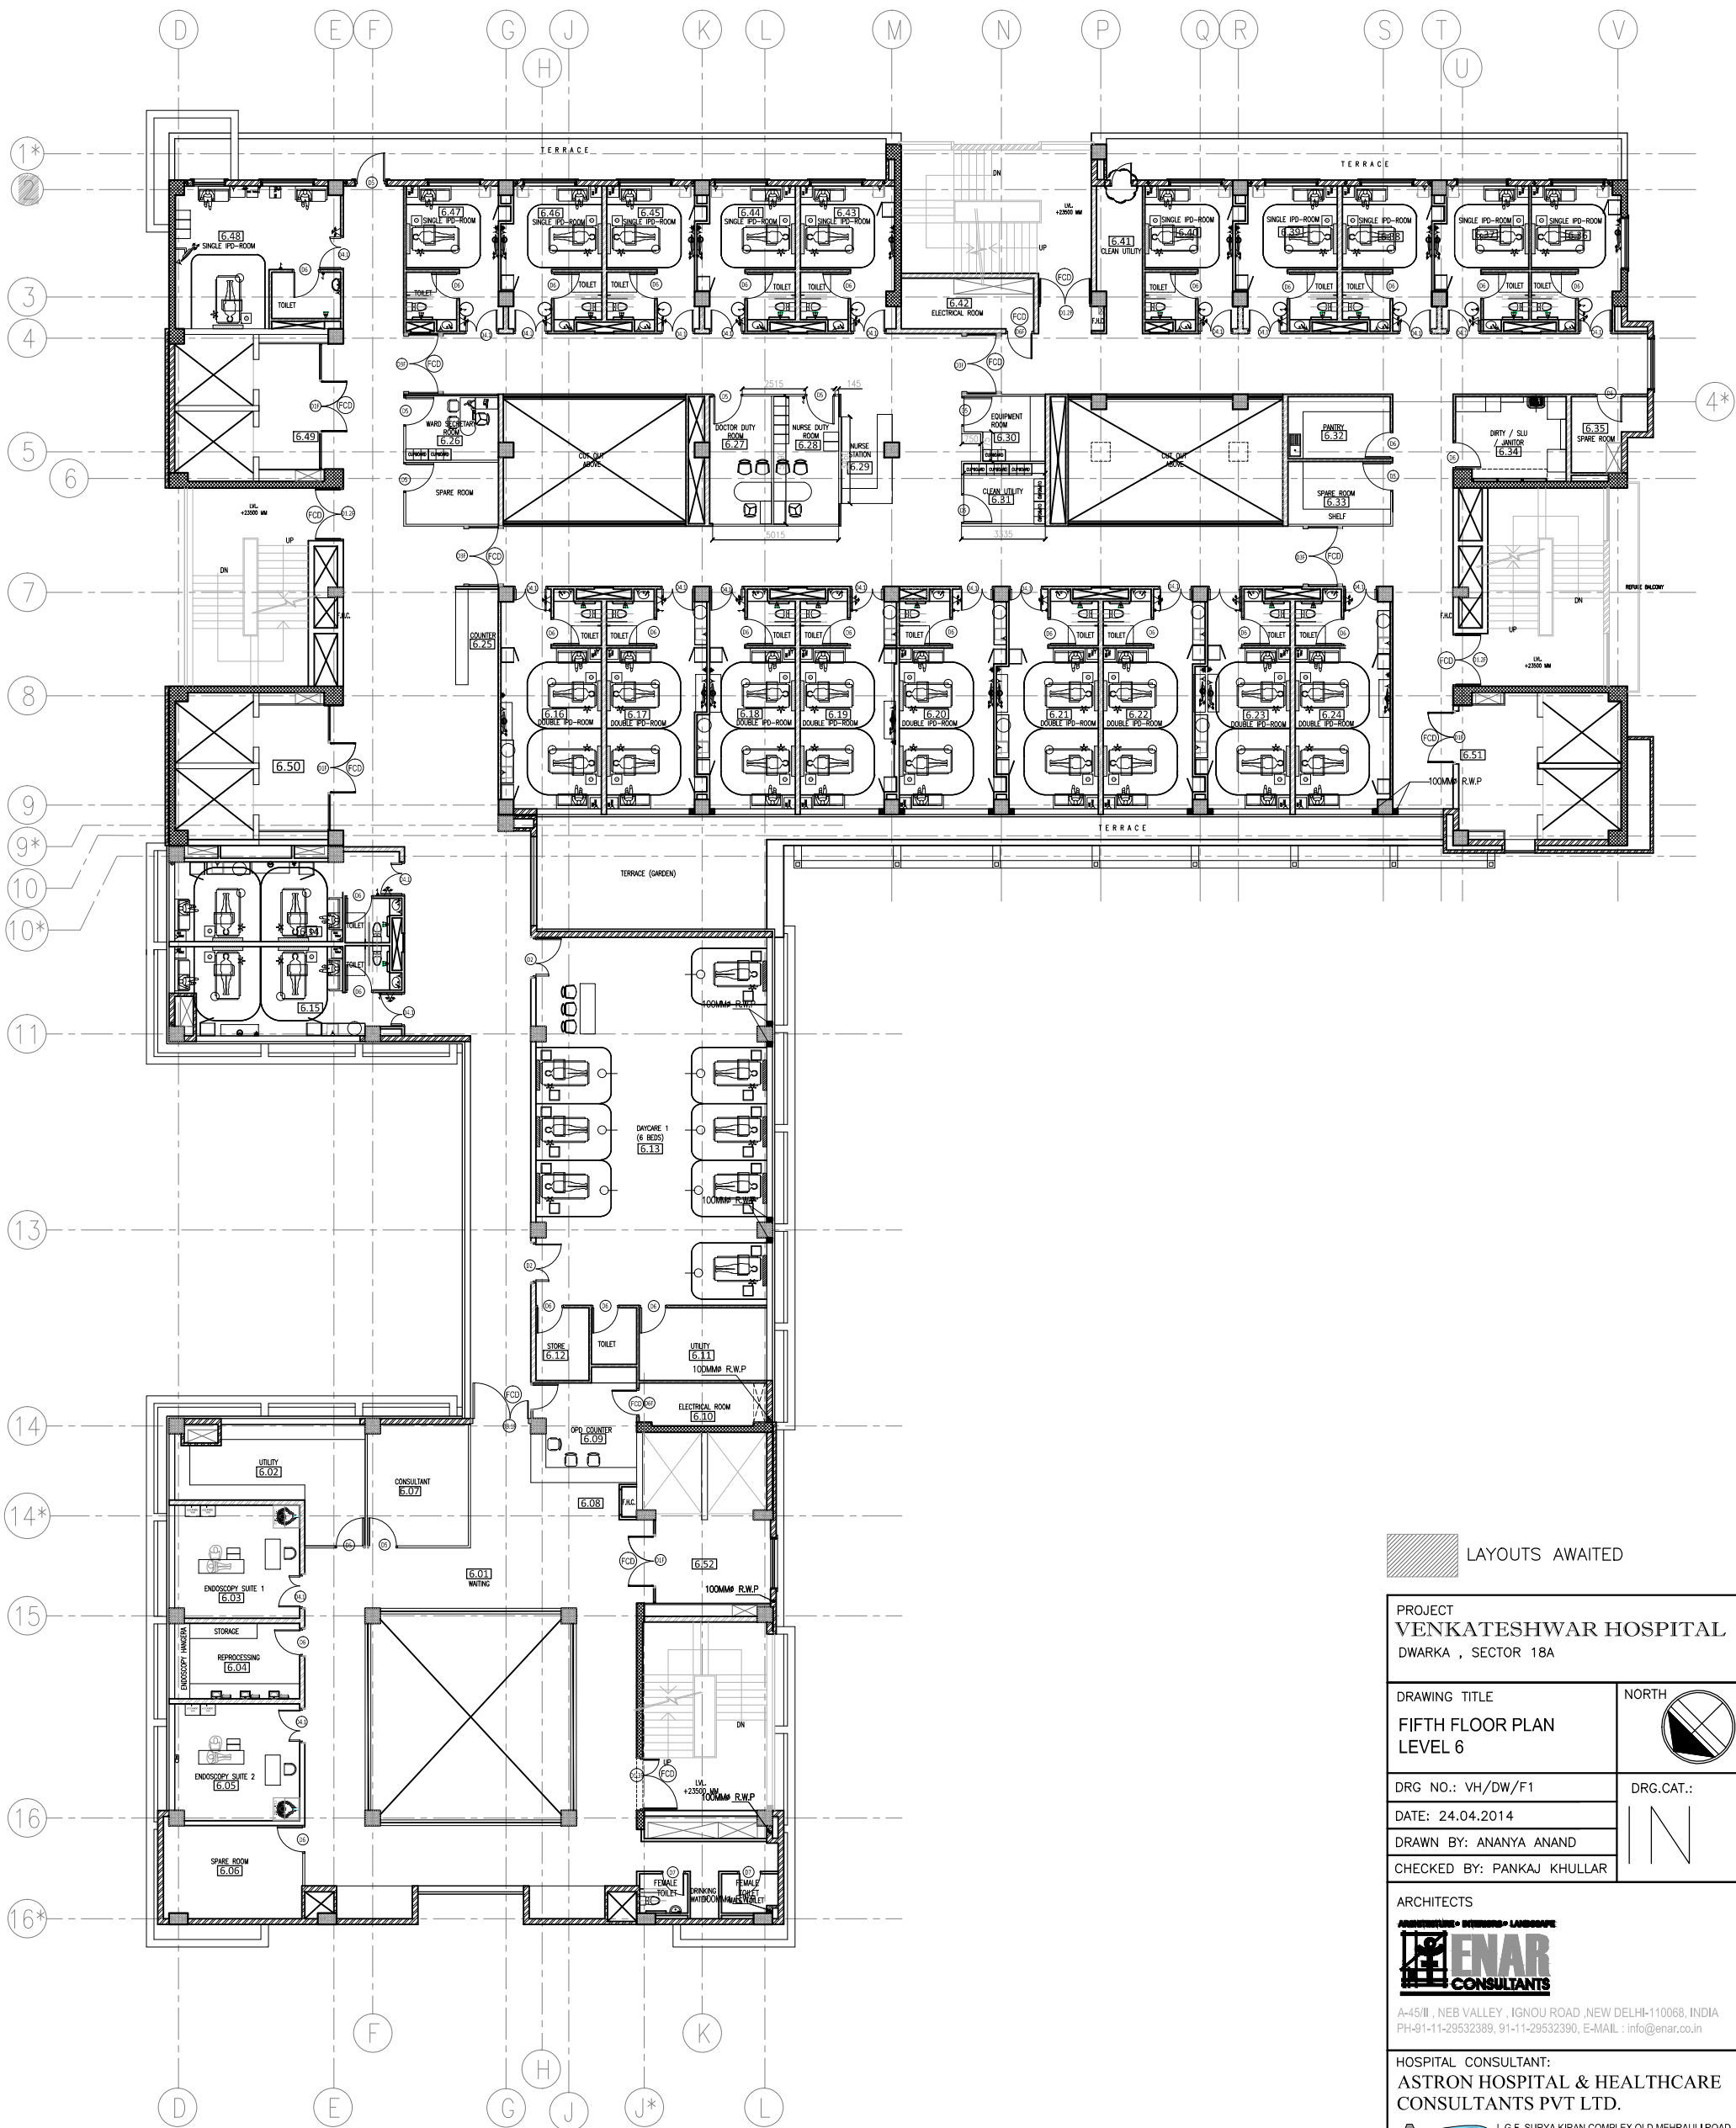

LAYOUTS AWAITED

PROJECT
VENKATESHWAR HOSPITAL
DWARKA , SECTOR 18A

DRAWING TITLE
FIFTH FLOOR PLAN
LEVEL 6



DRG NO.: VH/DW/F1
DATE: 24.04.2014

DRG.CAT.:
IN

DRAWN BY: ANANYA ANAND
CHECKED BY: PANKAJ KHULLAR

ARCHITECTS




A-45/III , NEB VALLEY , IGNOU ROAD , NEW DELHI-110068, INDIA
PH-91-11-29532389, 91-11-29532390, E-MAIL : info@enar.co.in

HOSPITAL CONSULTANT:
ASTRON HOSPITAL & HEALTHCARE
CONSULTANTS PVT LTD.

L.G.F. SURYA KIRAN COMPLEX OLD MEHRAULI ROAD,
(OPP.SBI MAIN BRANCH), GURGAON HARYANA -122001
PHONE NO - + 91 124-4546200 / 4267551

NOTES

1. The validity of this drawing is subject to approval from competent Municipal Authorities
2. All dimensions are in MM.
3. Do not scale the drawing, in case of discrepancy, please cross check with the Architect/s (ENAR CONSULTANTS).
4. In case of any doubt seek clarifications from the Architect/s.

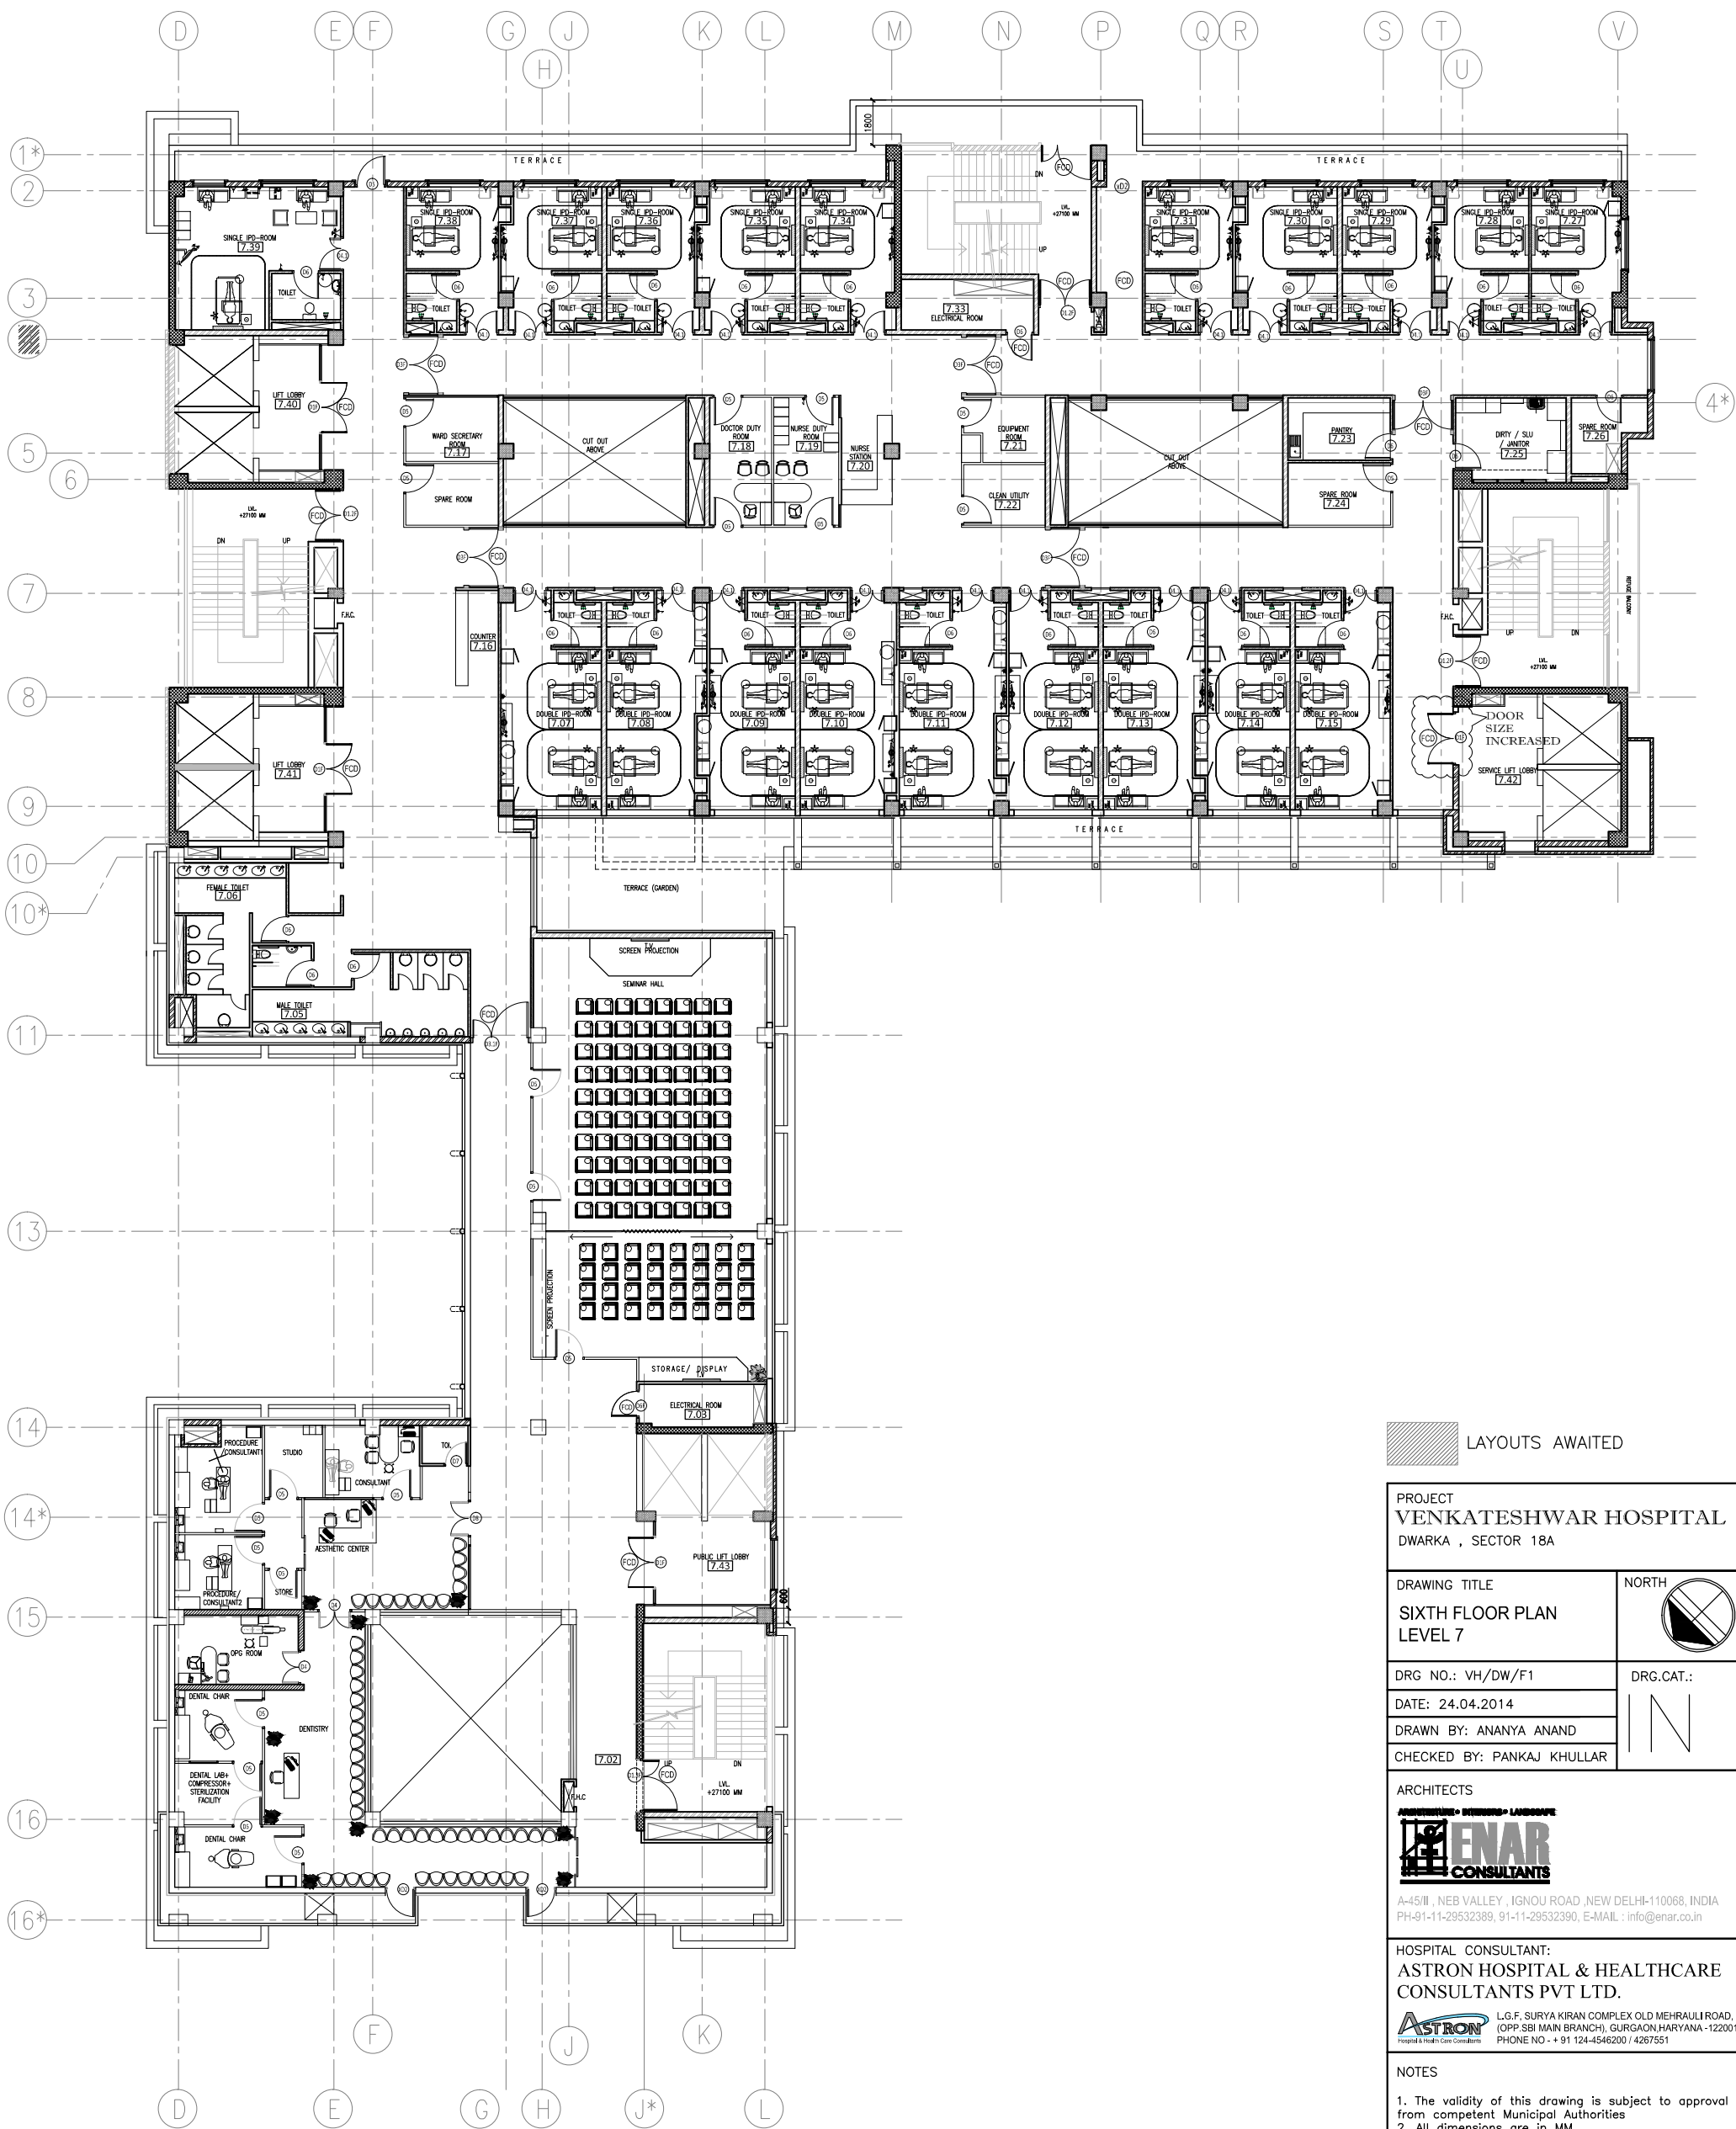

LAYOUTS AWAITED

PROJECT
VENKATESHWAR HOSPITAL
DWARKA , SECTOR 18A

DRAWING TITLE
SIXTH FLOOR PLAN
LEVEL 7

DRG NO.: VH/DW/F1
DATE: 24.04.2014
DRAWN BY: ANANYA ANAND
CHECKED BY: PANKAJ KHULLAR


ARCHITECTS
ENAR
CONSULTANTS

A-45/III , NEB VALLEY , IGNOU ROAD , NEW DELHI-110068, INDIA
PH-91-11-29532389, 91-11-29532390, E-MAIL : info@enar.co.in

HOSPITAL CONSULTANT:
ASTRON HOSPITAL & HEALTHCARE
CONSULTANTS PVT LTD.

ASTRON
Hospital & Health Care Consultants
L.G.F. SURYA KIRAN COMPLEX OLD MEHRAULI ROAD,
(OPP.SBI MAIN BRANCH), GURGAON HARYANA -122001
PHONE NO - + 91 124-4546200 / 4267551

NOTES
1. The validity of this drawing is subject to approval from competent Municipal Authorities
2. All dimensions are in MM.
3. Do not scale the drawing, in case of discrepancy, please cross check with the Architect/s (ENAR CONSULTANTS).
4. In case of any doubt seek clarifications from the Architect/s.

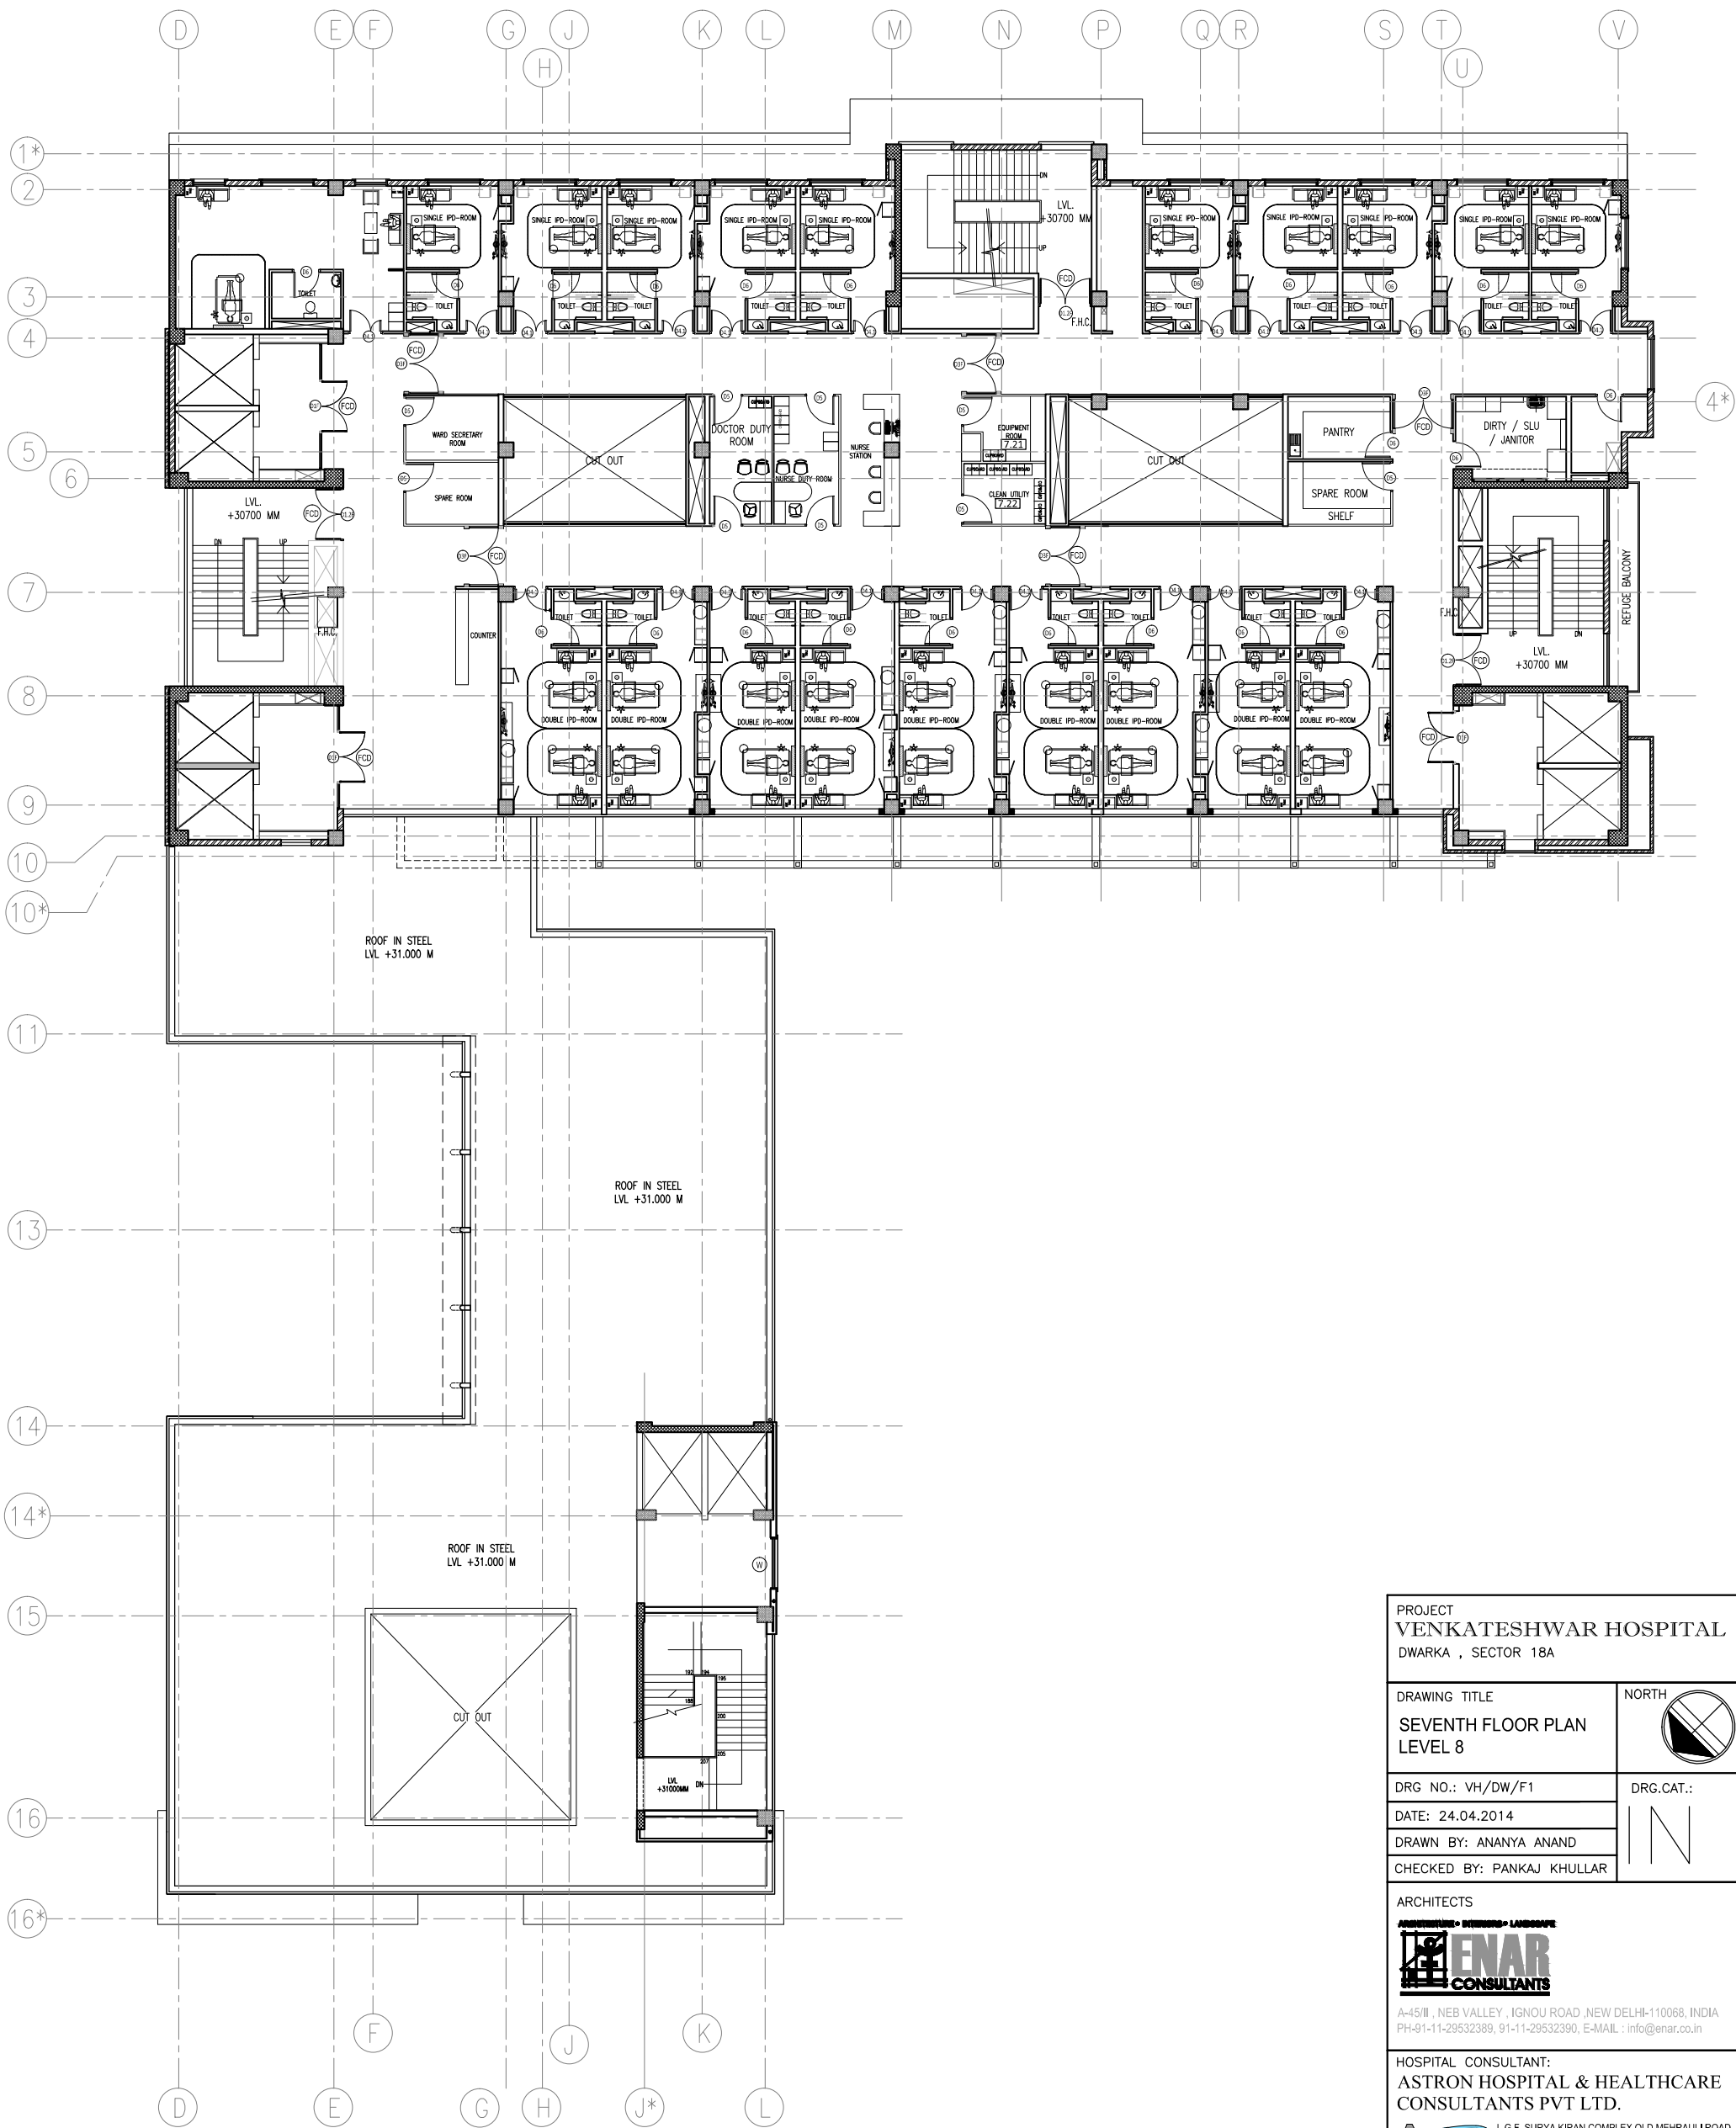

PROJECT
VENKATESHWAR HOSPITAL
DWARKA , SECTOR 18A

DRAWING TITLE
SEVENTH FLOOR PLAN
LEVEL 8

DRG NO.: VH/DW/F1
DATE: 24.04.2014

DRAWN BY: ANANYA ANAND
CHECKED BY: PANKAJ KHULLAR

ARCHITECTS




A-45/III , NEB VALLEY , IGNOU ROAD , NEW DELHI-110068, INDIA
PH-91-11-29532389, 91-11-29532390, E-MAIL : info@enar.co.in

HOSPITAL CONSULTANT:
ASTRON HOSPITAL & HEALTHCARE
CONSULTANTS PVT LTD.

L.G.F. SURYA KIRAN COMPLEX OLD MEHRAULI ROAD,
(OPP.SBI MAIN BRANCH), GURGAON HARYANA -122001
PHONE NO - + 91 124-4546200 / 4267551

NOTES

1. The validity of this drawing is subject to approval from competent Municipal Authorities
2. All dimensions are in MM.
3. Do not scale the drawing, in case of discrepancy, please cross check with the Architect/s (ENAR CONSULTANTS).
4. In case of any doubt seek clarifications from the Architect/s.

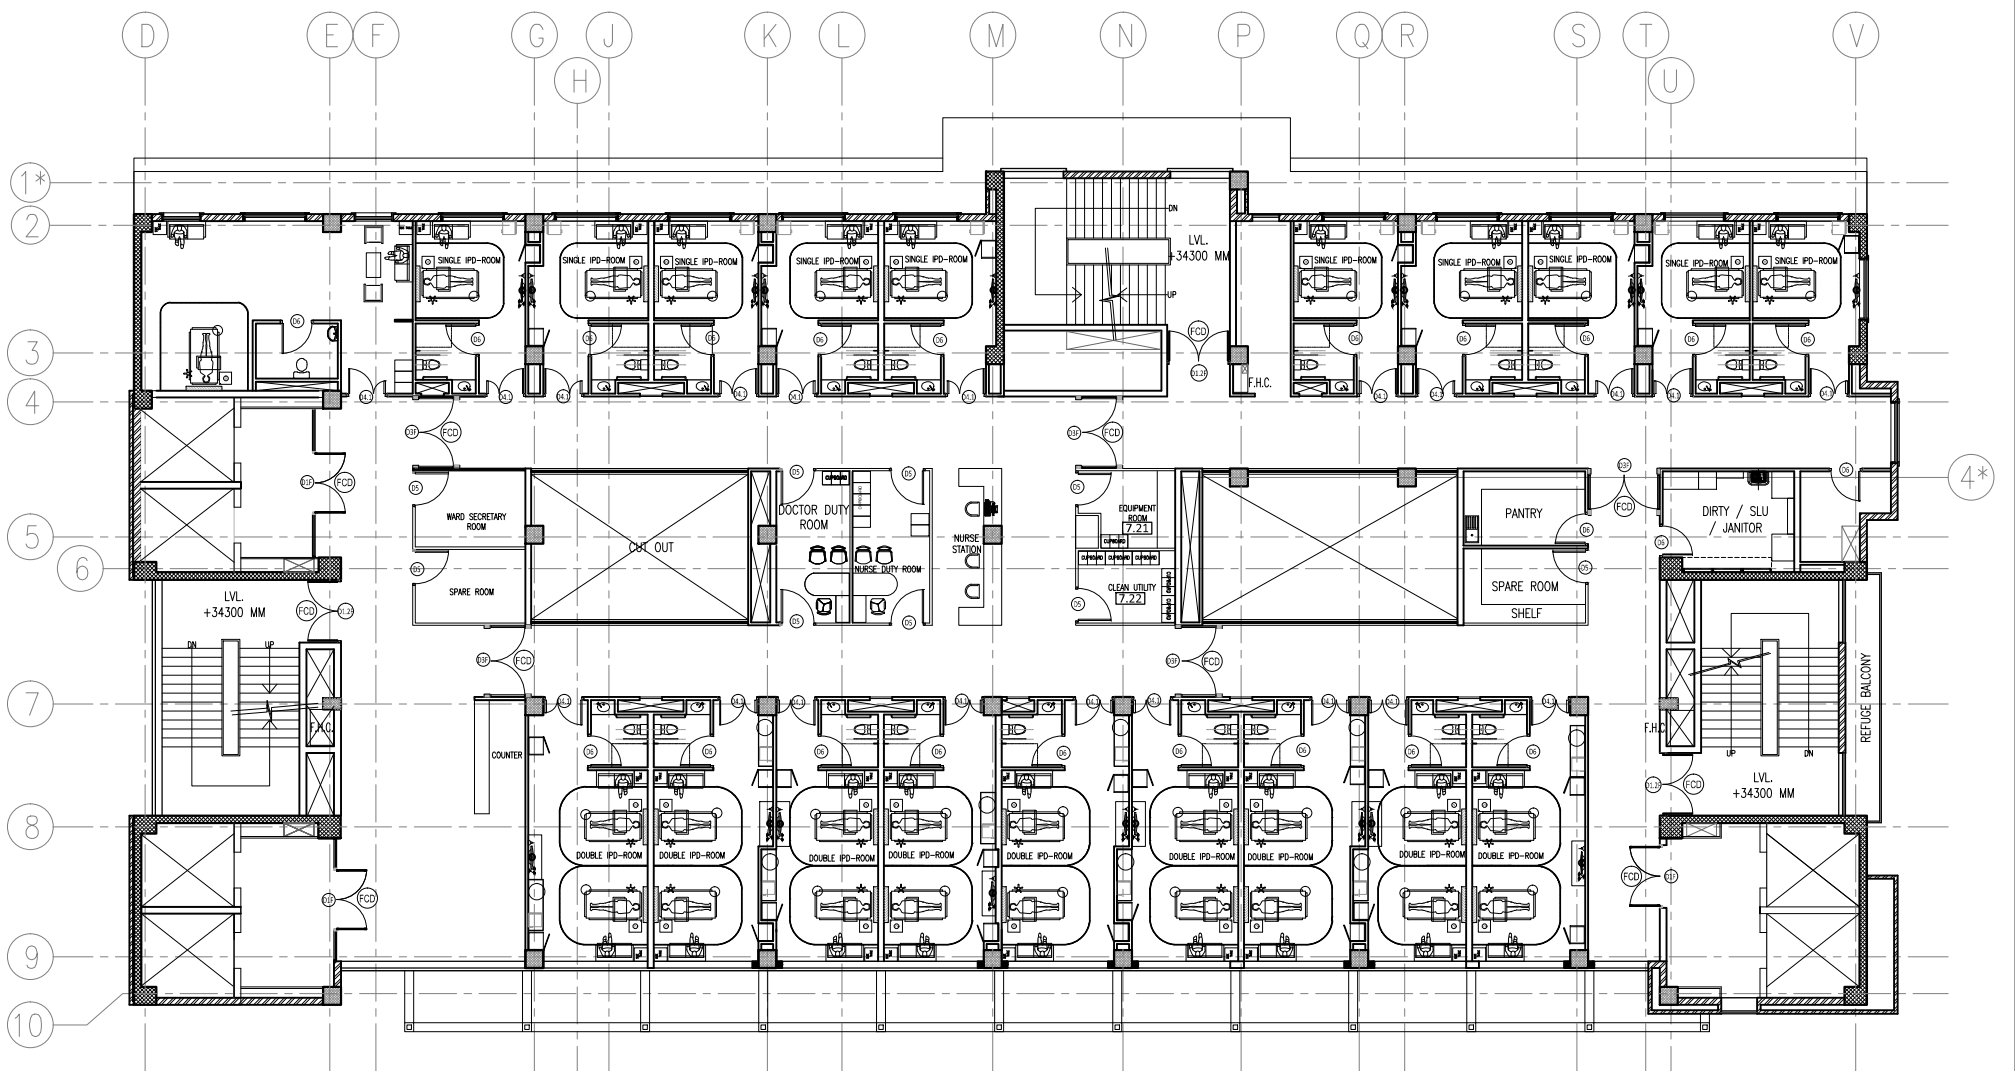

PROJECT VENKATESHWAR HOSPITAL DWARKA , SECTOR 18A	
DRAWING TITLE TYPICAL 8TH-9TH FLOOR LEVEL 9 (34.30m) & 10 (37.90m)	NORTH
DRG NO.: VH/DW/F1 DATE: 24.04.2014 DRAWN BY: ANANYA ANAND CHECKED BY: PANKAJ KHULLAR	DRG.CAT.:
ARCHITECTS A-45/III , NEB VALLEY , IGNOU ROAD , NEW DELHI-110068, INDIA PH-91-11-29532389, 91-11-29532390, E-MAIL : info@enar.co.in	
HOSPITAL CONSULTANT: ASTRON HOSPITAL & HEALTHCARE CONSULTANTS PVT LTD. L.G.F. SURYA KIRAN COMPLEX OLD MEHRAULI ROAD, (OPP.SBI MAIN BRANCH), GURGAON HARYANA -122001 PHONE NO - + 91 124-4546200 / 4267551	
NOTES 1. The validity of this drawing is subject to approval from competent Municipal Authorities 2. All dimensions are in MM. 3. Do not scale the drawing, in case of discrepancy, please cross check with the Architect/s (ENAR CONSULTANTS). 4. In case of any doubt seek clarifications from the Architect/s.	

