



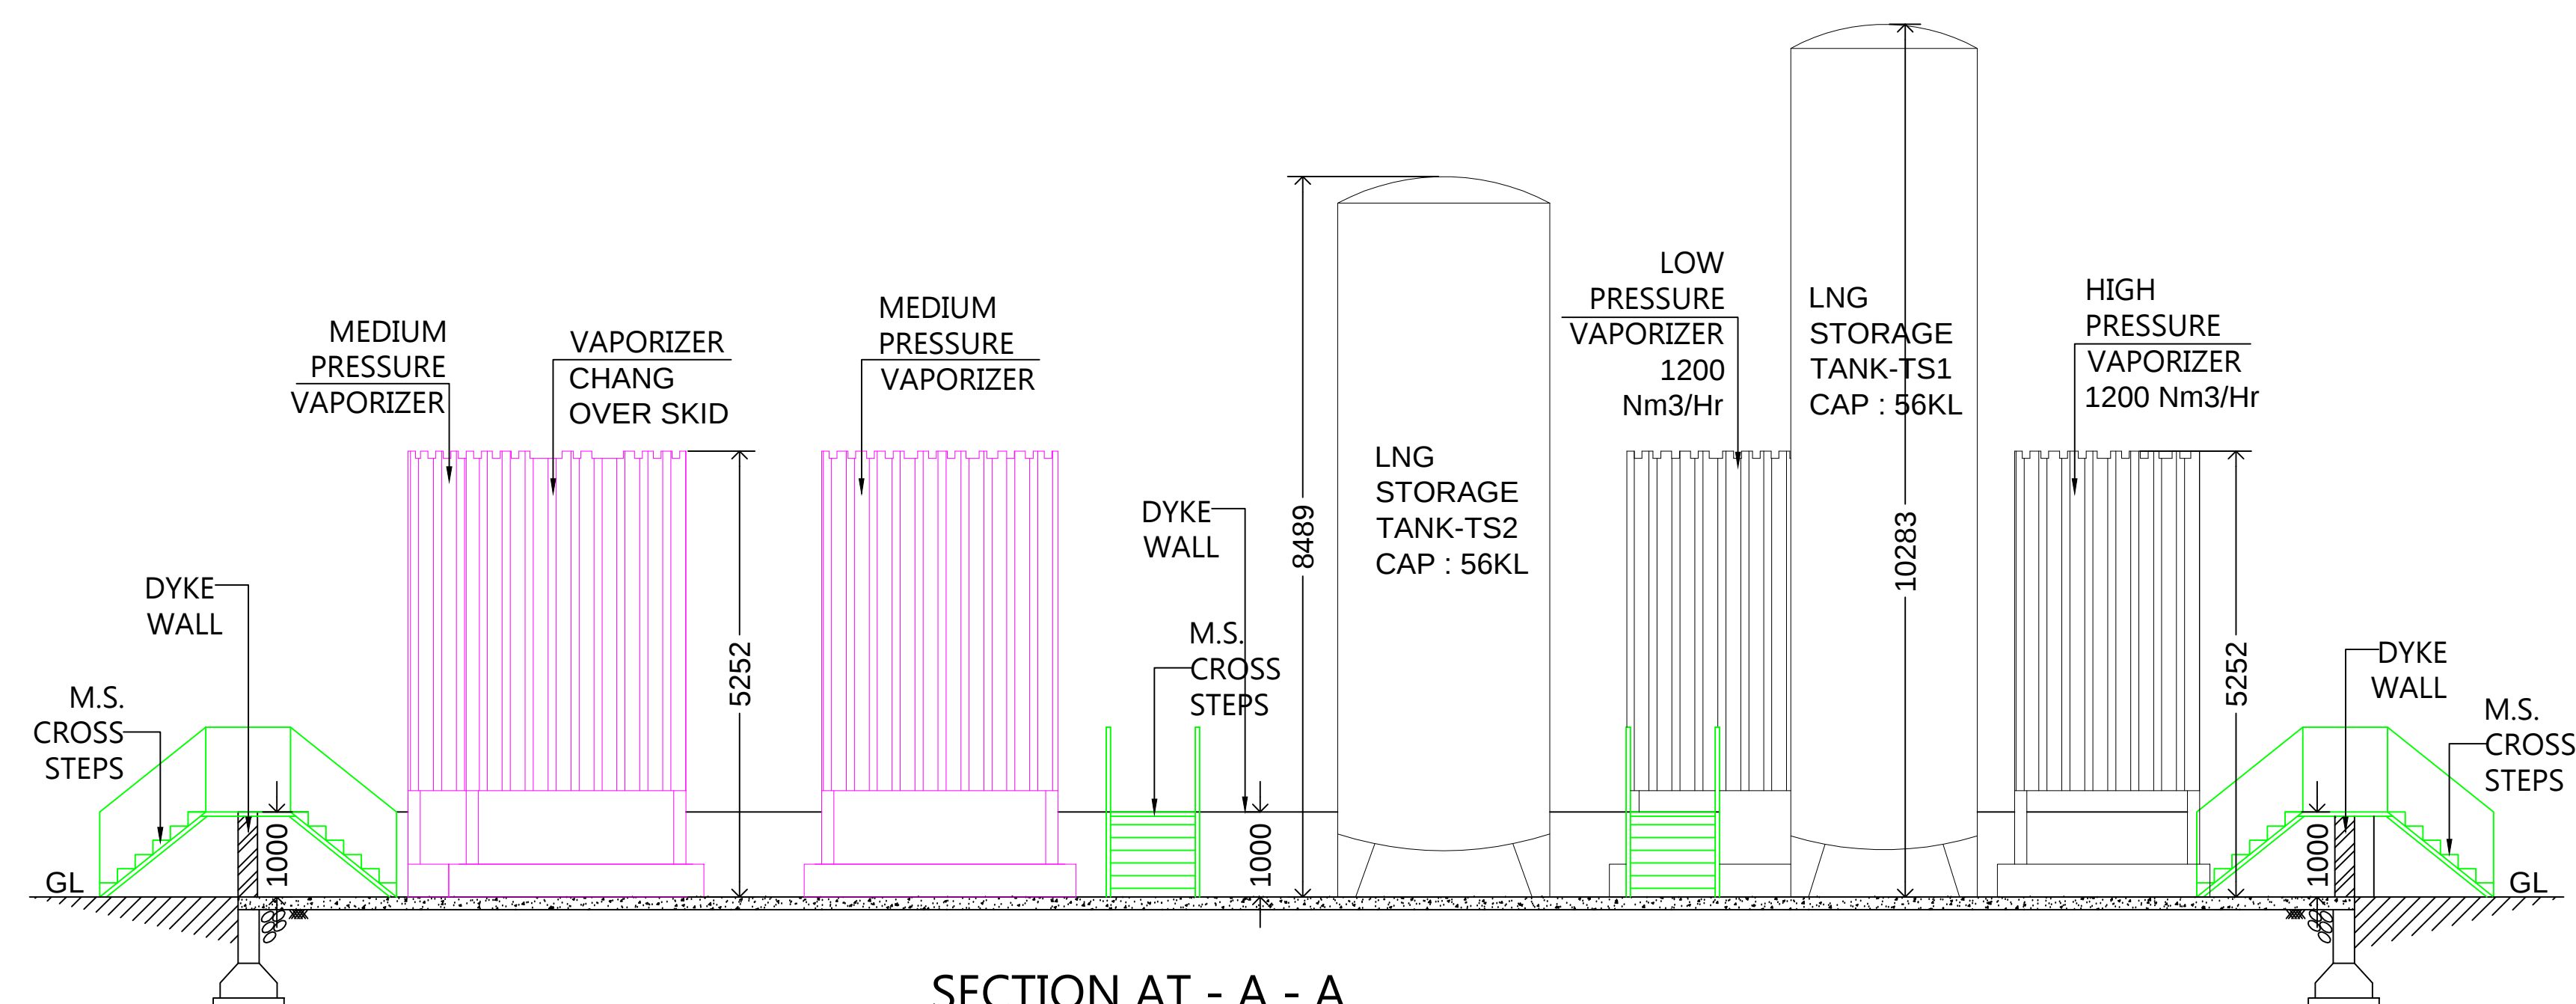


SECTION AT - A - A
SCALE 1:100

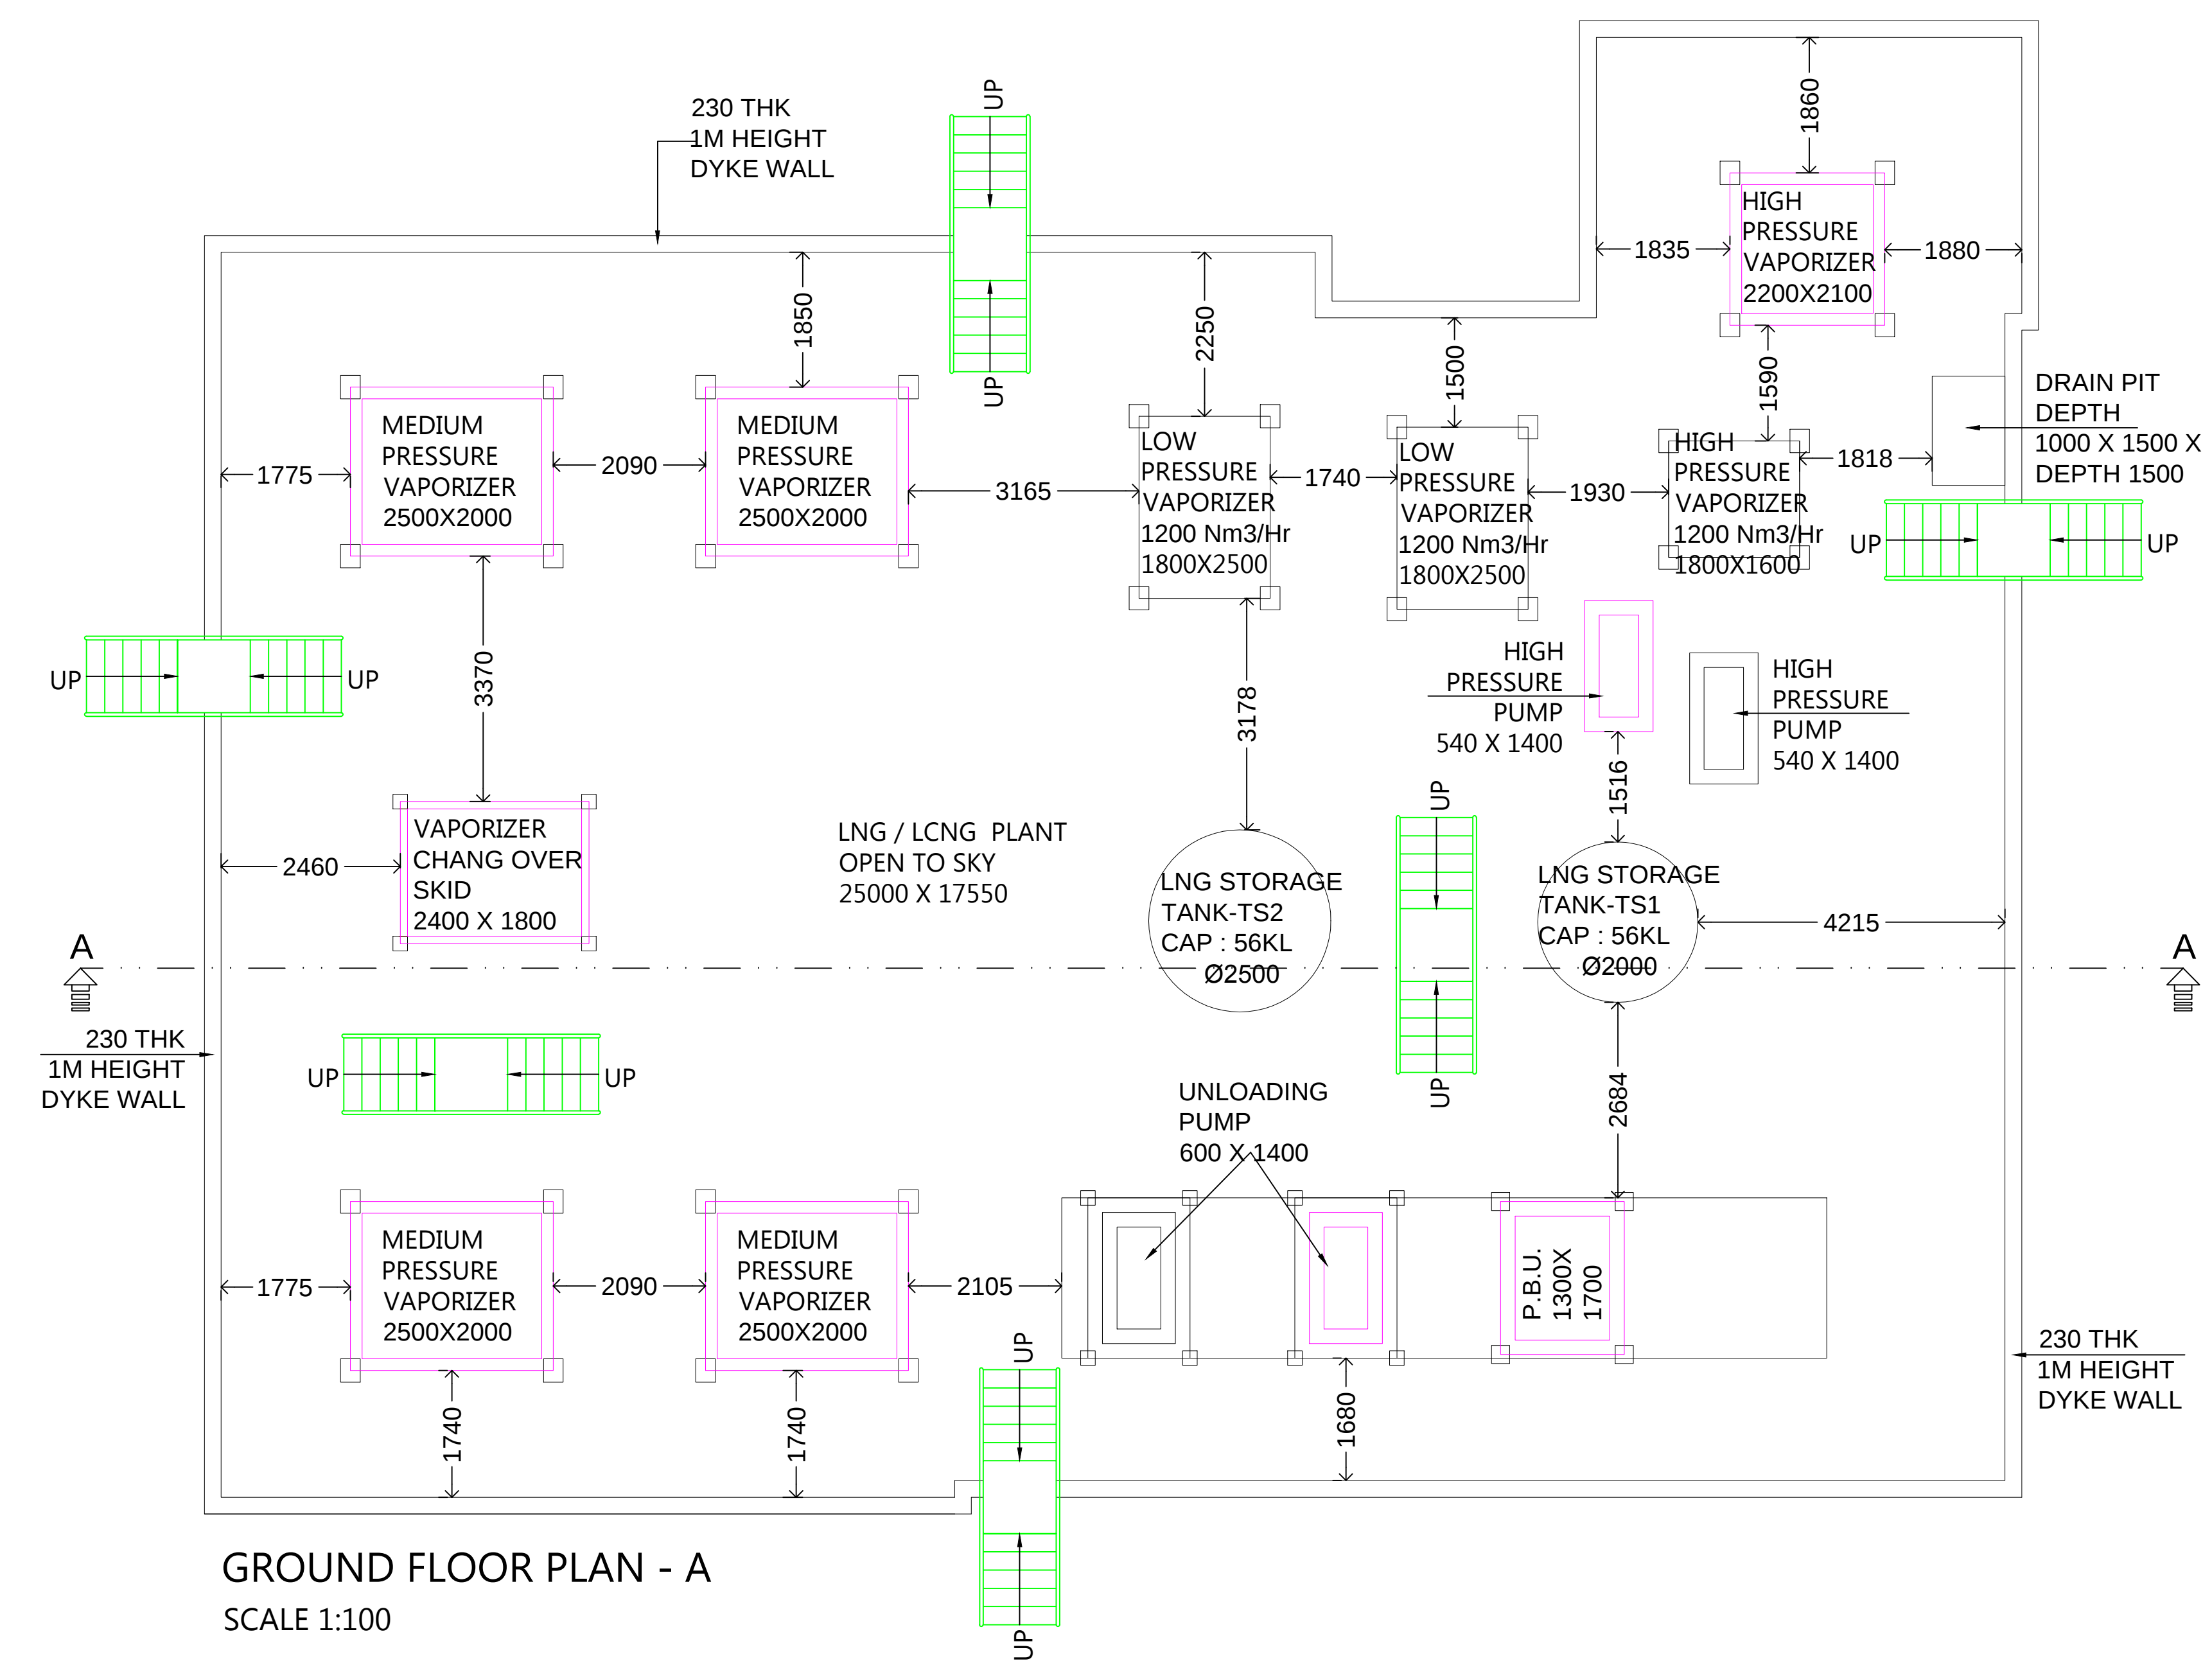


GROUND FLOOR PLAN - A
SCALE 1:100

A - LNG / LCNG PLANT

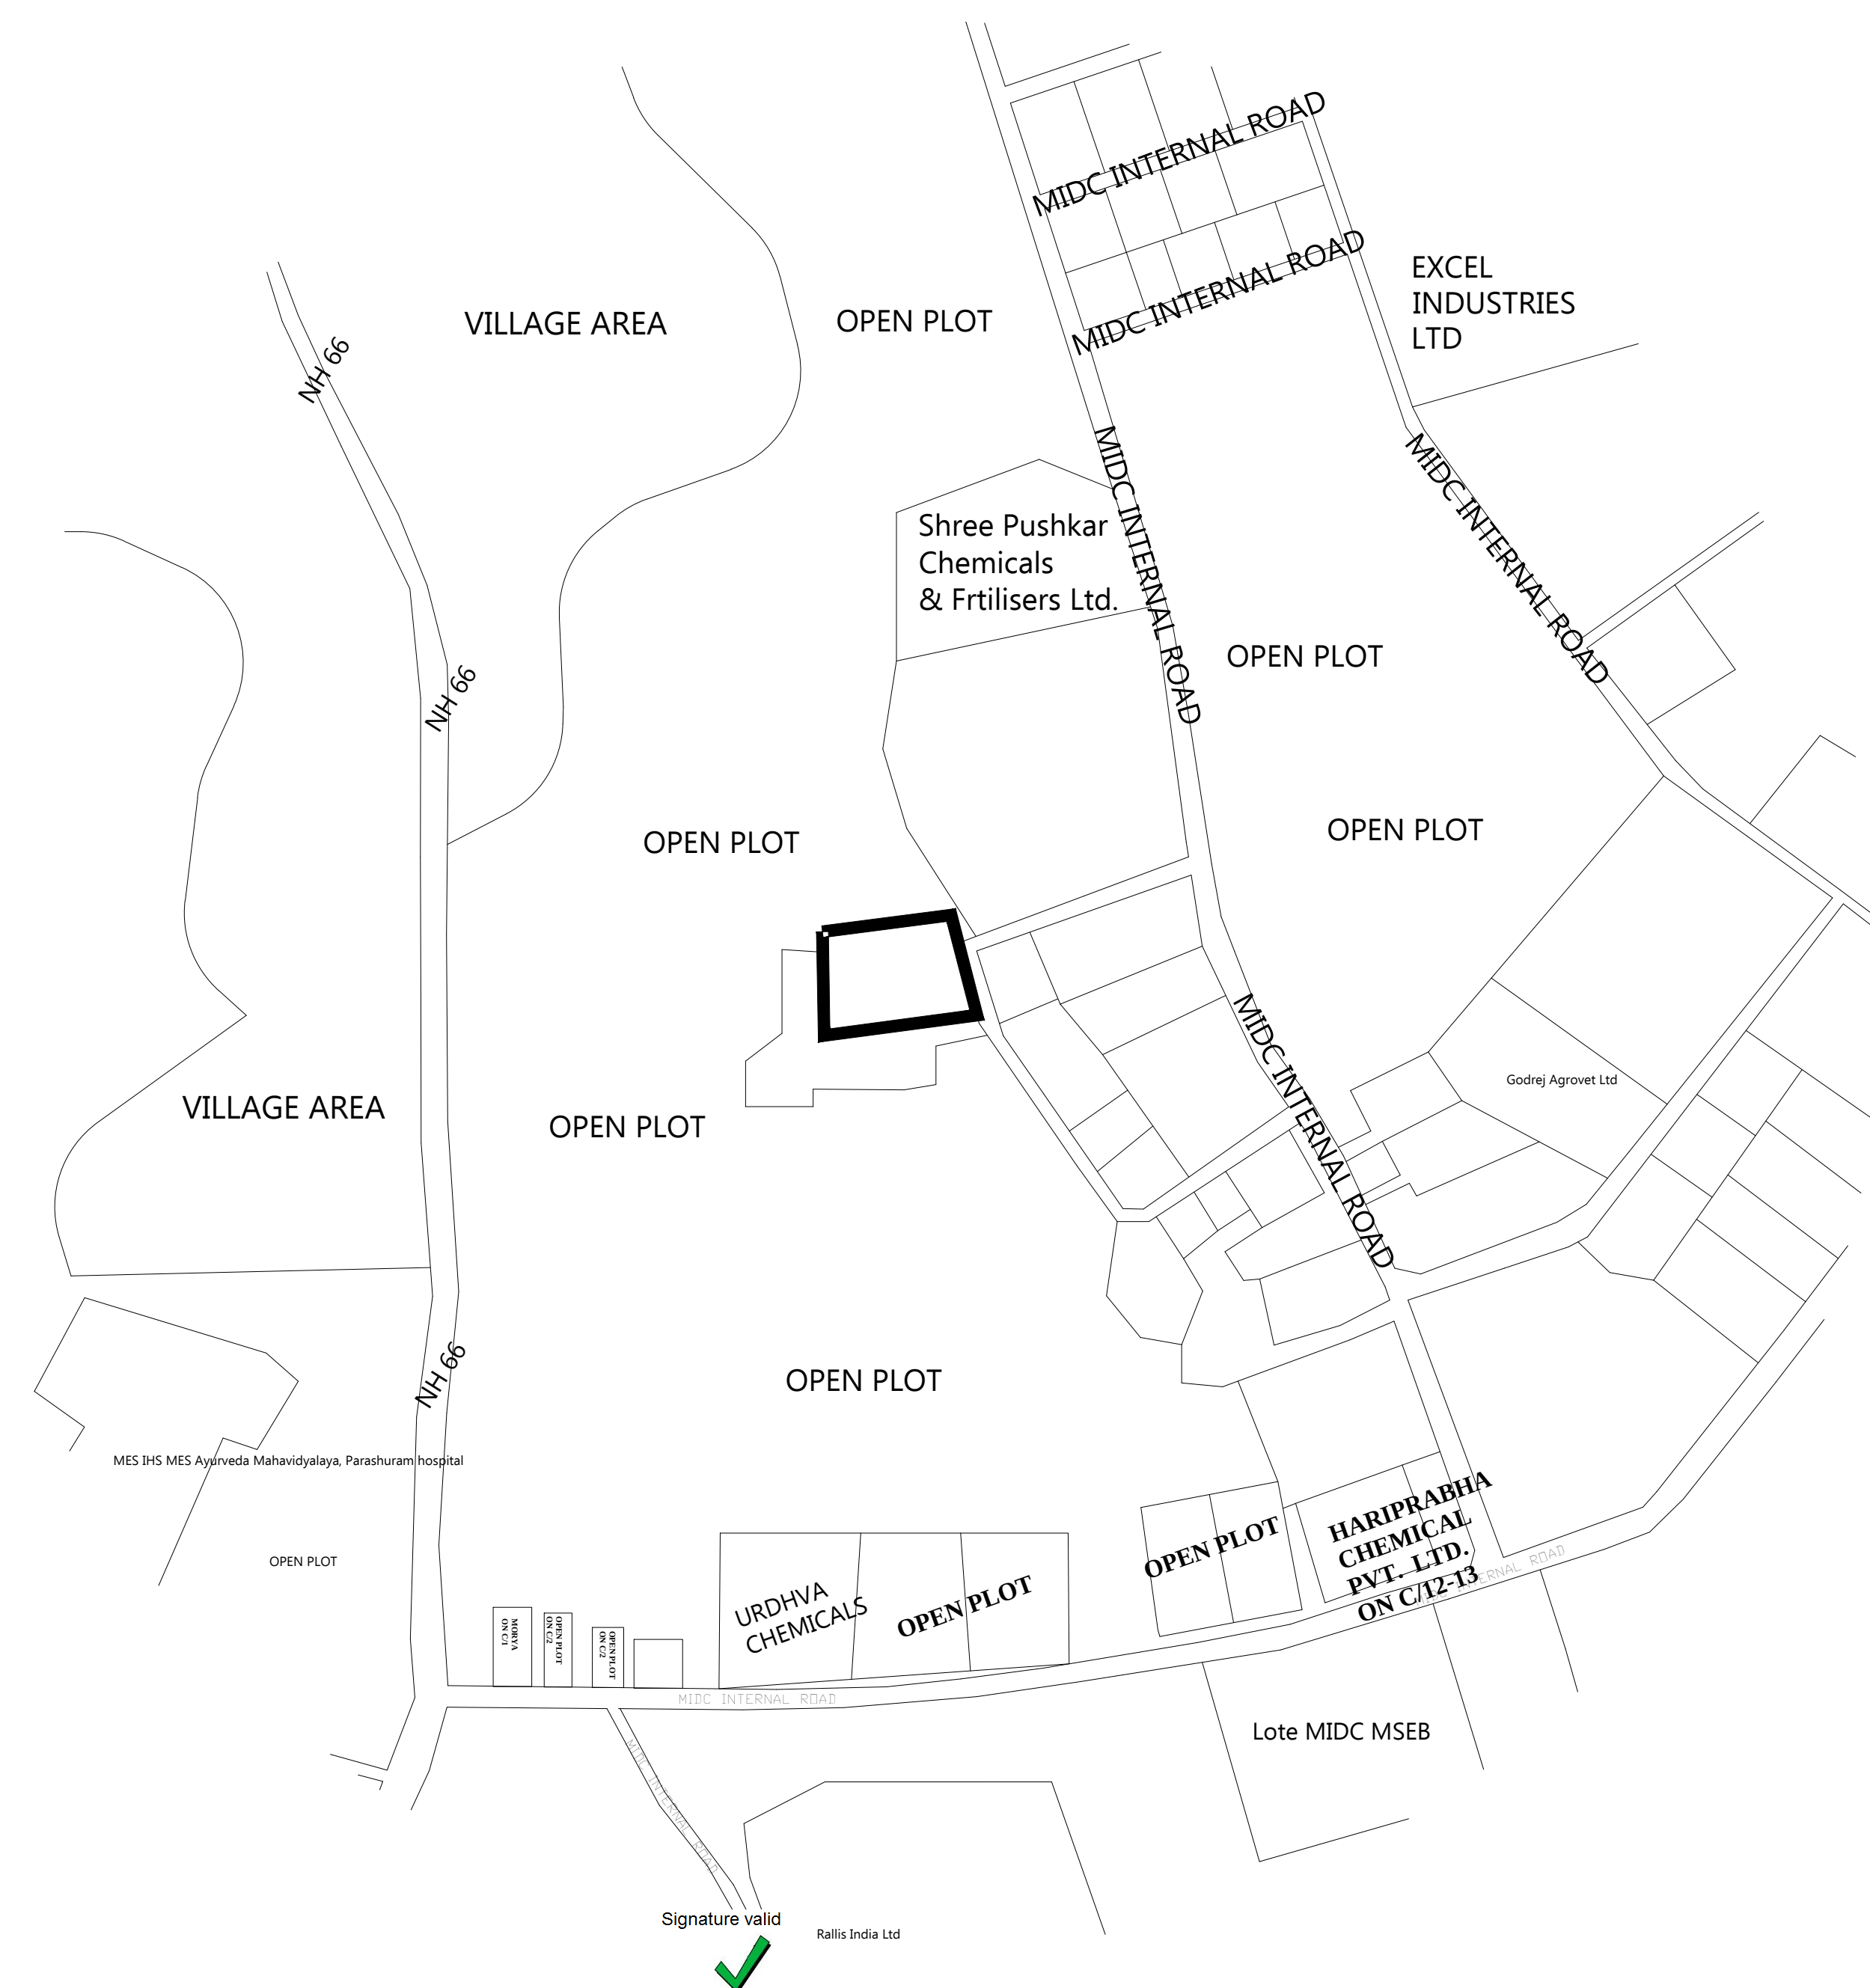

LOCATION PLAN
SCALE-NTS

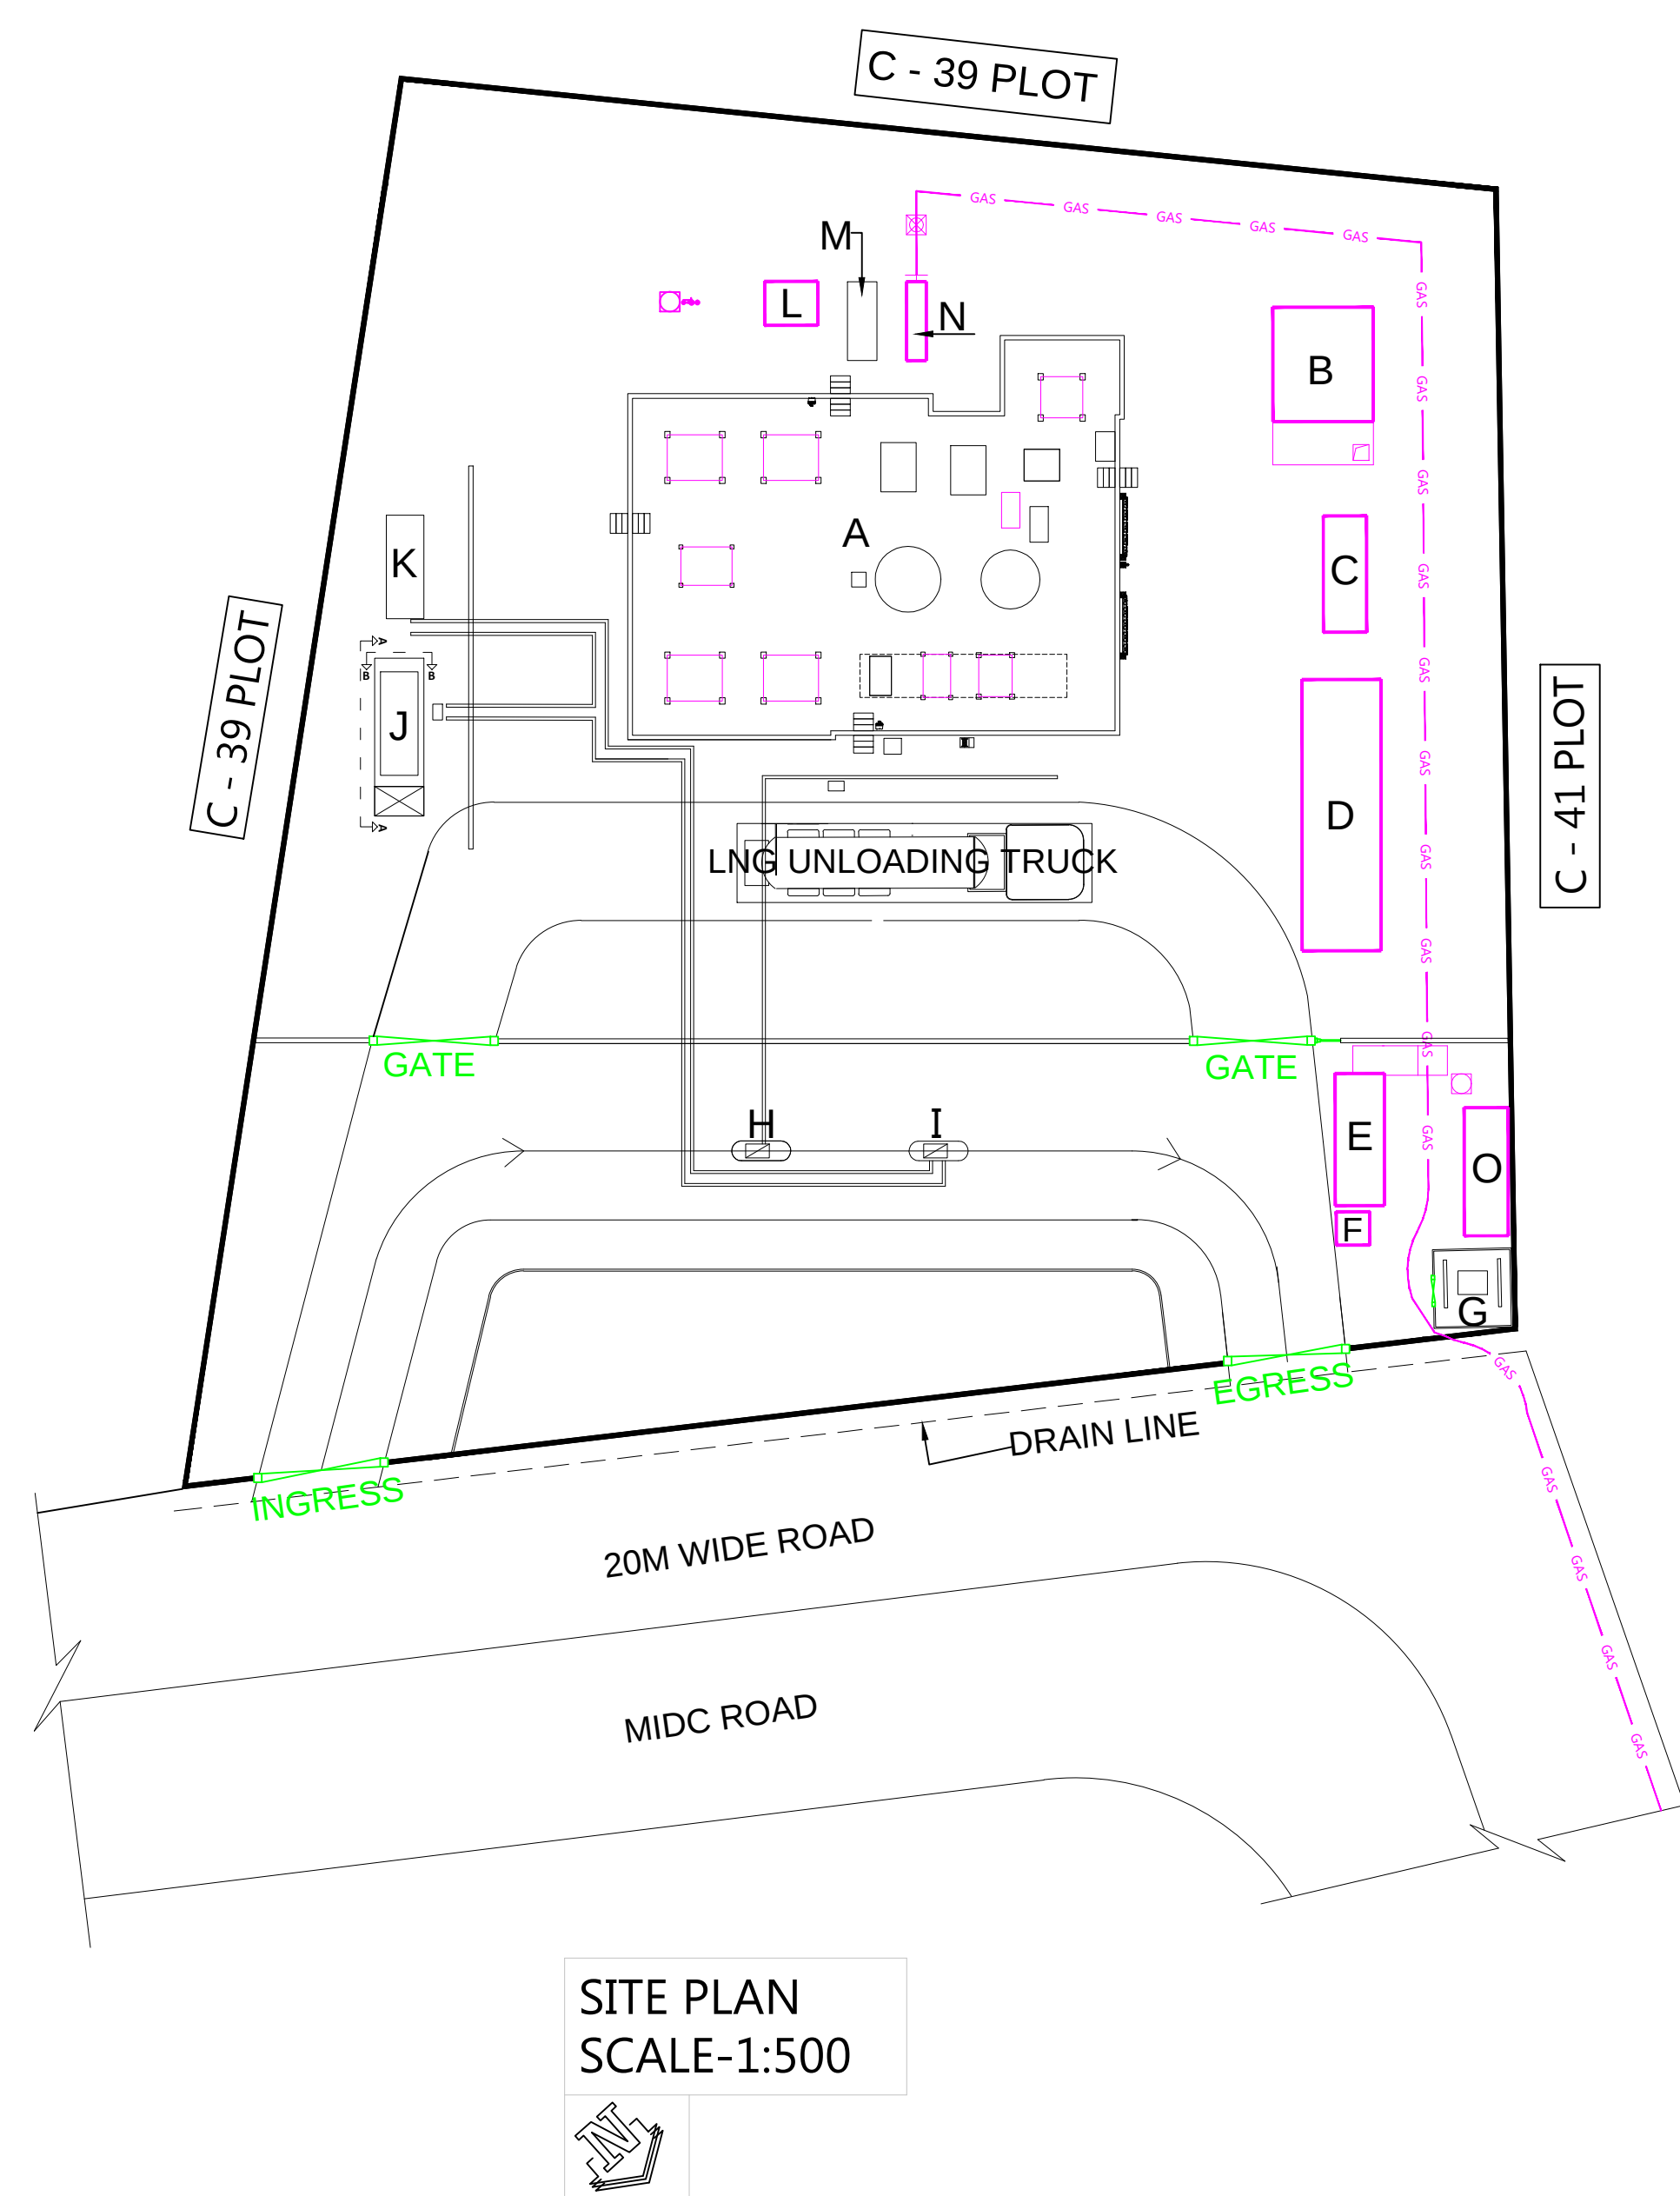

SITE PLAN
SCALE-1:500

A - LNG / LCNG PLANT
B - PUMP HOUSE, U.G.WATER TANK
C - SCADA ROOM
D - COMPRESSOR & D.G.SET AREA & ELECTRICAL ROOM
E - REST ROOM
F - SECURITY CABIN
G - TRANSFORMER AREA
H - LNG DISPENSING UNIT
I - L CNG DISPENSING UNIT
J - 4500 WATER LTR MOBILE A CASCADE
K - 4500 WATER LTR STORAGE CASCADE
L - ODOURIZATION UNIT
M - MP PRS
N - LOW PRESSURE REGULATING SKID
O - EL.PANEL AREA

A - LNG / LCNG PLANT
SITE PLAN , LOCATION PLAN

NOTE - ALL DIMENSION ARE IN MM

OWNER		FOR PRAVIN SERVICES	
PROJECT			
EXPANSION PLANS OF BUILDING & MACHINERY LAYOUT FOR			
UNISON ENVIRO PRIVATE LIMITED			
AT PLOT NO. C - 40, M.I.D.C. LOTE PARSHURAM,			
TAL - KHED, DIST - RATNAGIRI, MAHARASHTRA.			
FOR PRAVIN SERVICES			
AT - 1187/3, E WARD, RAJARAMPURI 5th LANE,			
BACK SIDE OF KAMALA COLLAGE, KOLHAPUR.			
DRN - P.G. SUTAR		SCALE	DRG NO.
DATE - FEB.- 2023		1:500,1:100	01 OF 02