




NORTH

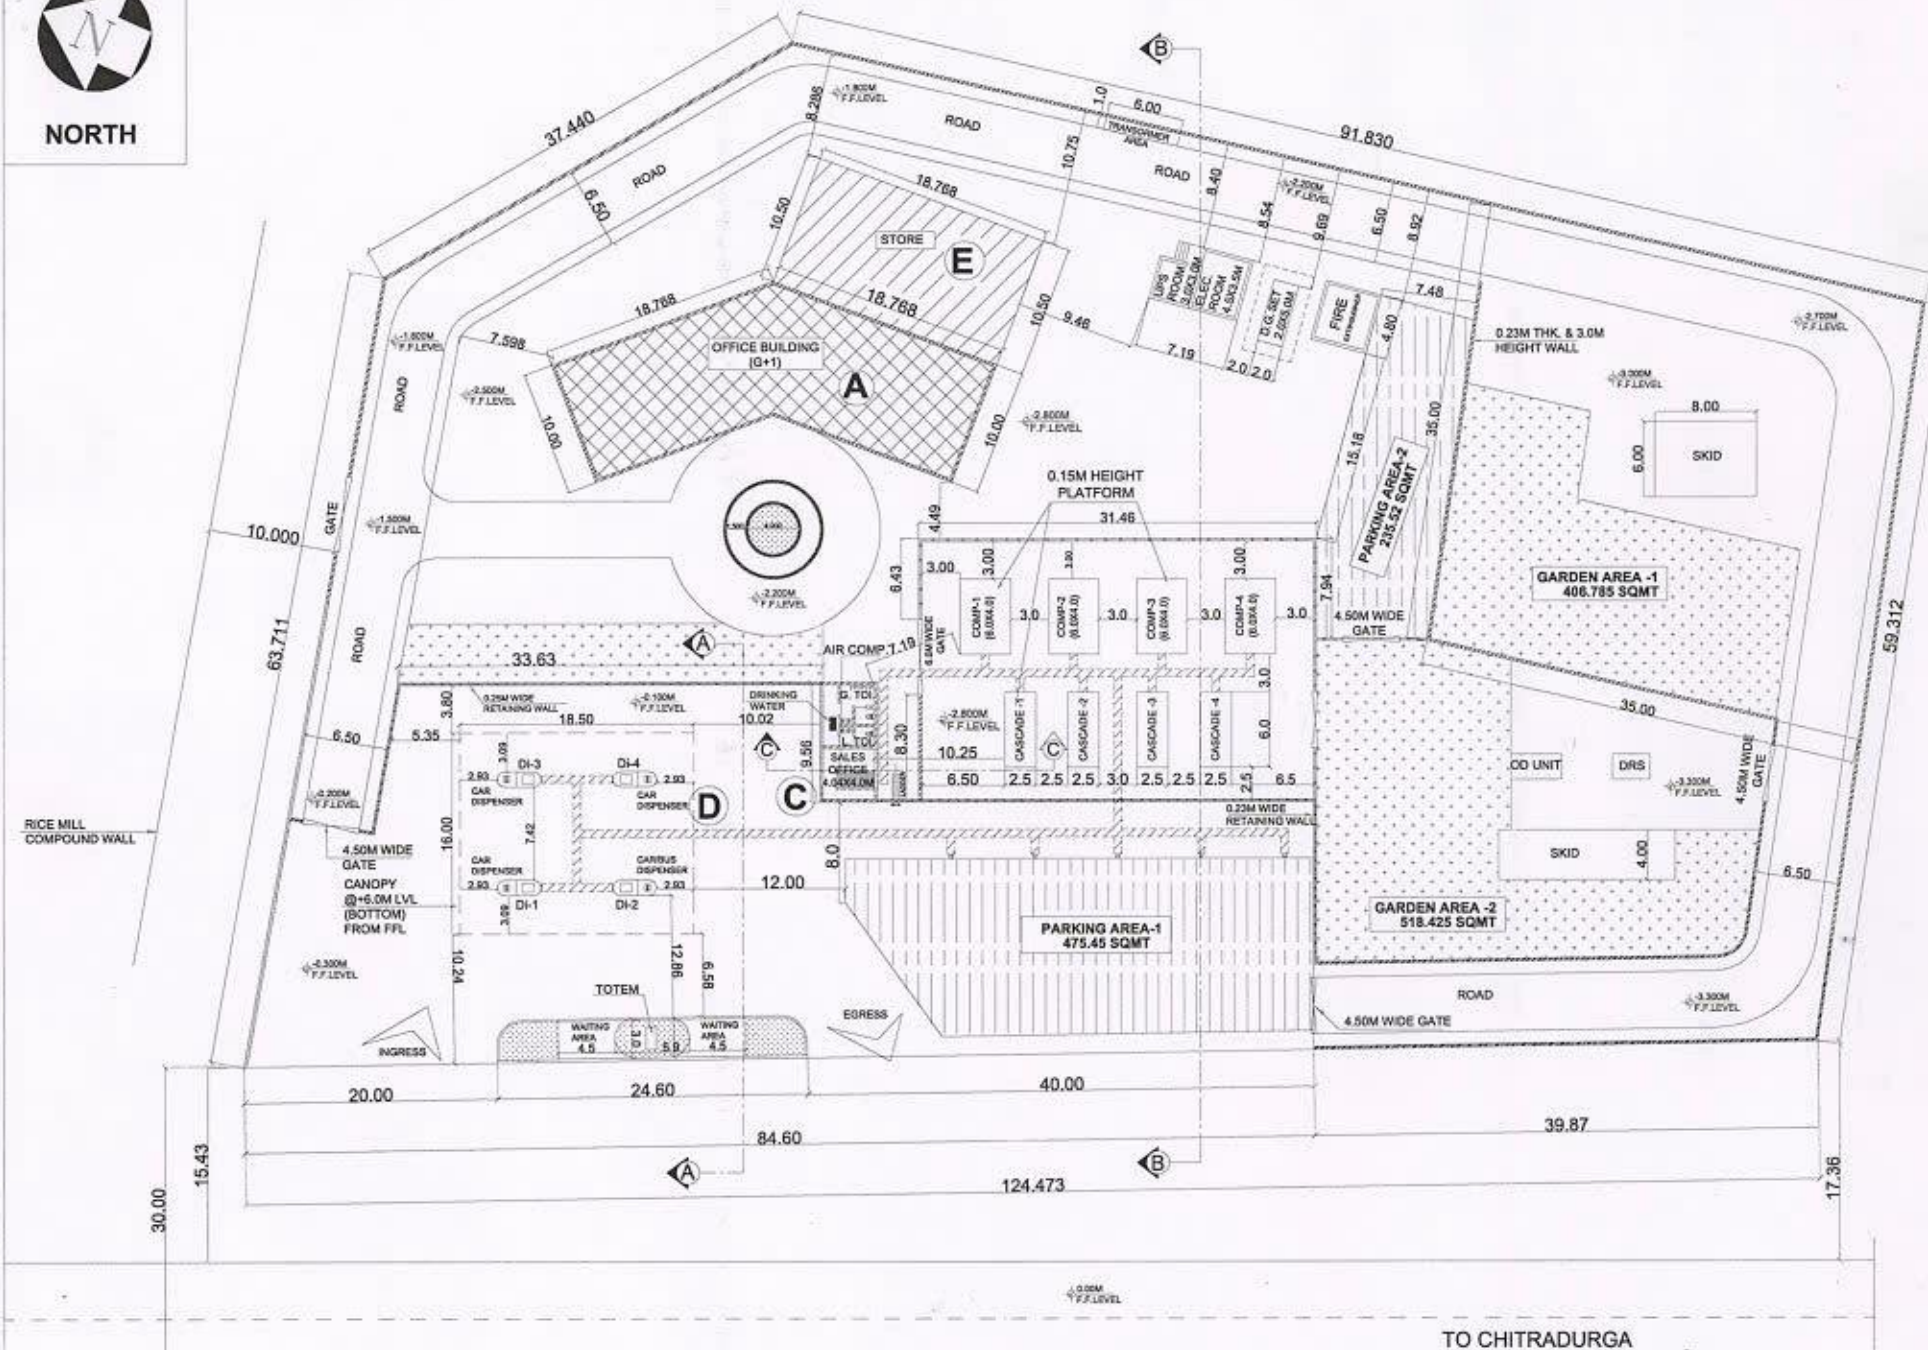


LAYOUT PLAN

SCALE - 1:100




FRONT ELEVATION

SCALE - 1:100

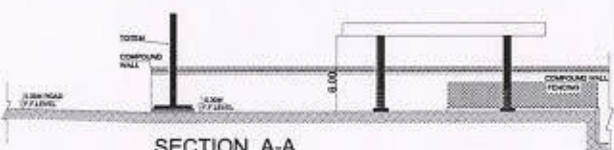

SECTION A-A

SCALE - 1:100




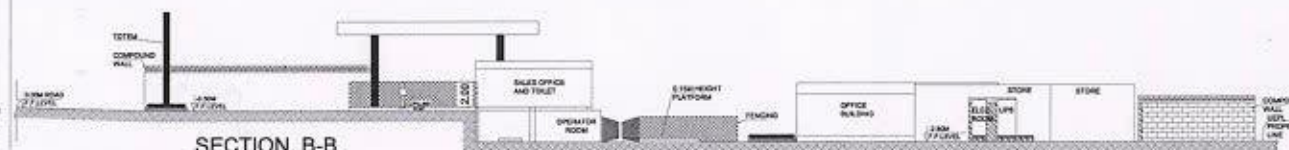


SECTION B-B

SCALE - 1:100

AREA STATEMENT

TOTAL PLOT AREA	8655.357 SQMT
PARKING AREA	710.97 SQMT
GARDEN AREA 1+2	925.21 SQMT
OFFICE BUILDING GROUND FLOOR AREA	337.68 SQMT
FIRST FLOOR AREA (BLOCK-A)	55.64 SQMT
ELECTRICAL & UPS BATTERY ROOM (BLOCK-B)	30.81 SQMT
SALES OFFICE + TOILET (BLOCK-C)	43.02 SQMT
CANOPY AREA (BLOCK-D)	296.00 SQMT
PEB STORE AREA (BLOCK-E)	197.06 SQMT
TOTAL (BLOCK A-E)	960.21 SQMT

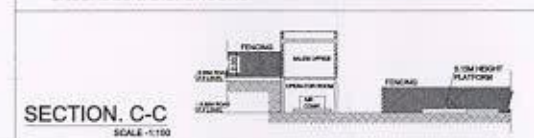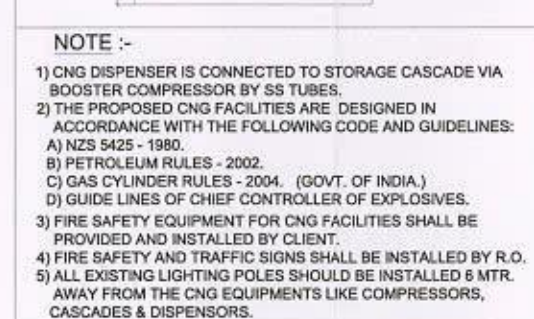
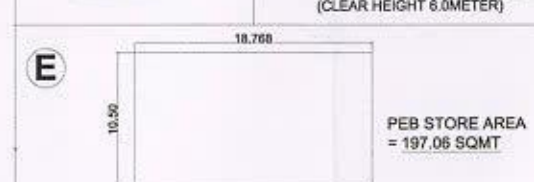
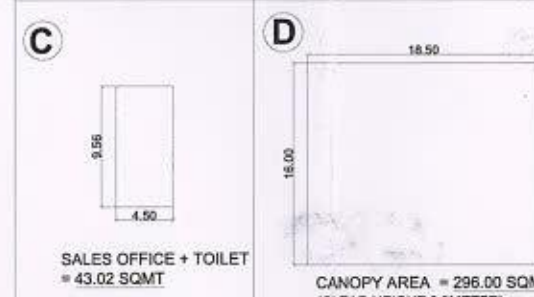



SECTION C-C

SCALE - 1:100



   UNISON ENVIRO PRIVATE LIMITED

NAME OF PROJECT	CITY GATE STATION AT -SURVEY NO - 92 /7B1, GUDDADARANGVVAHALLI, CHITRADURGA.			
DRAWING TITLE	CGS CUM MOTHER STATION LAYOUT PLAN			
ISSUED FOR	APPROVAL			
DRAWN BY	CHECKED BY	APPROVED BY	DRAWING NO.	
			UEPL/CGD CTA/ CGS CUM MOTHER STATION LAYOUT PLAN/ APPROVAL	
MANSOOR	KUMAR G.	SANDEEP	DATE	REVISION
			13-02-2021	R0

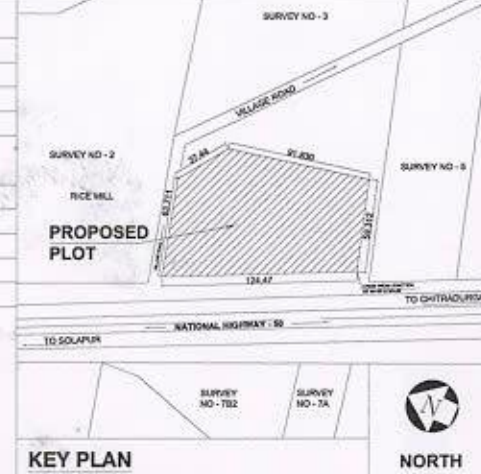

SITE INFORMATION

SURVEY NO - 92 /7B1 ZONE/AREA - NA LAND
VILLAGE - GUDDADARANGVVAHALLI
ROAD NAME -SOLAPUR TO CHITRADURGA NH-50
CHITRADURGA, KARNATAKA

EQUIPMENT DETAIL

SR. NO.	EQUIPMENT	NOS.	BLOCK SIZE LxWxH (MTRS.)	CAPACITY
1	CNG COMPRESSOR	4	6.0 x 4.0 x 3.20	1690 SCMH
2	STATIONARY CASCADE	4	6.0 x 4.0 x 3.20	4500 W/L WATER LINE CAPACITY
3	MOBILE CASCADE	5	12.0 x 2.50 x 3.08	8800 W/L
4	DISPENSER	4	1.10 x 0.50 x 2.00	15.0 KG/MIN FLOW
5	AIR RECIEVER TANK	3	1.0 x 1.0 x 1.0	1000 LTR
6	PRESSURE REGULATING SKID	1	9.0 x 4.0 x 3.50	8"NB, 300W 2500 SCMH
7	ODOURIZING UNIT	1	3.30 x 2.0 x 2.0	500 LTR
8	DRS - 49 BAR / 4 BAR	1	3.50 x 2.50 x 2.00	2000 SCMH

NOTE :-

- 1) ALL DIMENSIONS ARE IN METERS.
- 2) NO SMOKING BANNERS SHALL BE DISPLAYED IN KANNADA ENGLISH LOCAL LANGUAGE AT FILLING SHED.
- 3) FIRE EXTINGUISHERS SHALL BE PROVIDED AT FOLLOWERS A) D.C.P 10 KG (1 NO AT CNG CASCADE & COMPRESSOR) B) CO2 4.5 KG (1 NO AT ELECTRICAL ROOM & COMPRESSOR)
- 4) ALL ELECTRICAL FITTING SHALL CONFORM TO IS :2148 HAZARDOUS AREA CL -1 DIV GR-2 A/B.
- 5) ALL VEHICLE MOMENTS INSIDE INCLUDING FOR CNG REFUELING SHALL BE CONTROLLED AND RESTRICTED AT THE ENTRANCE.
- 6) WARNING SIGNS WITH THE WORDS " STOP VEHICLE " " NO SMOKING " NO OPEN FLAME PERMITTED FLAMMABLE GAS SHALL BE DISPLAYED AT DISPENSER HCV CASCADE REFUELING PTS & COMPRESSOR AREA

STAMP OF APPROVAL

For Sree Kanchana Civil Consultancy
R.D. Sreekanth
Proprietor
Sree Kanchana Civil Consultancy
Sree Kalikamba Nilaya
Opp. Post Office
Saraswathipuram 3rd Cross,
Chitradurga