
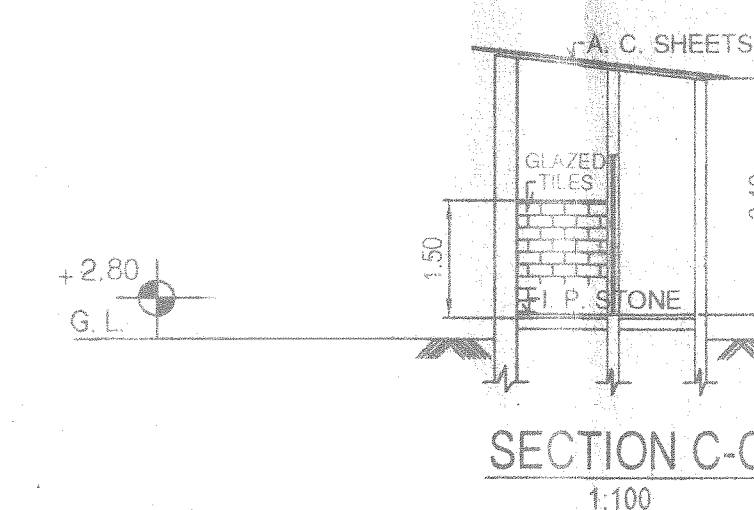
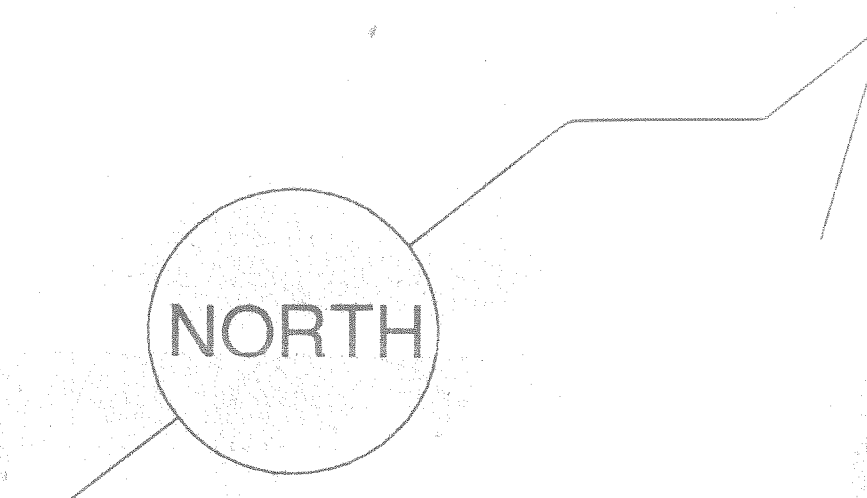
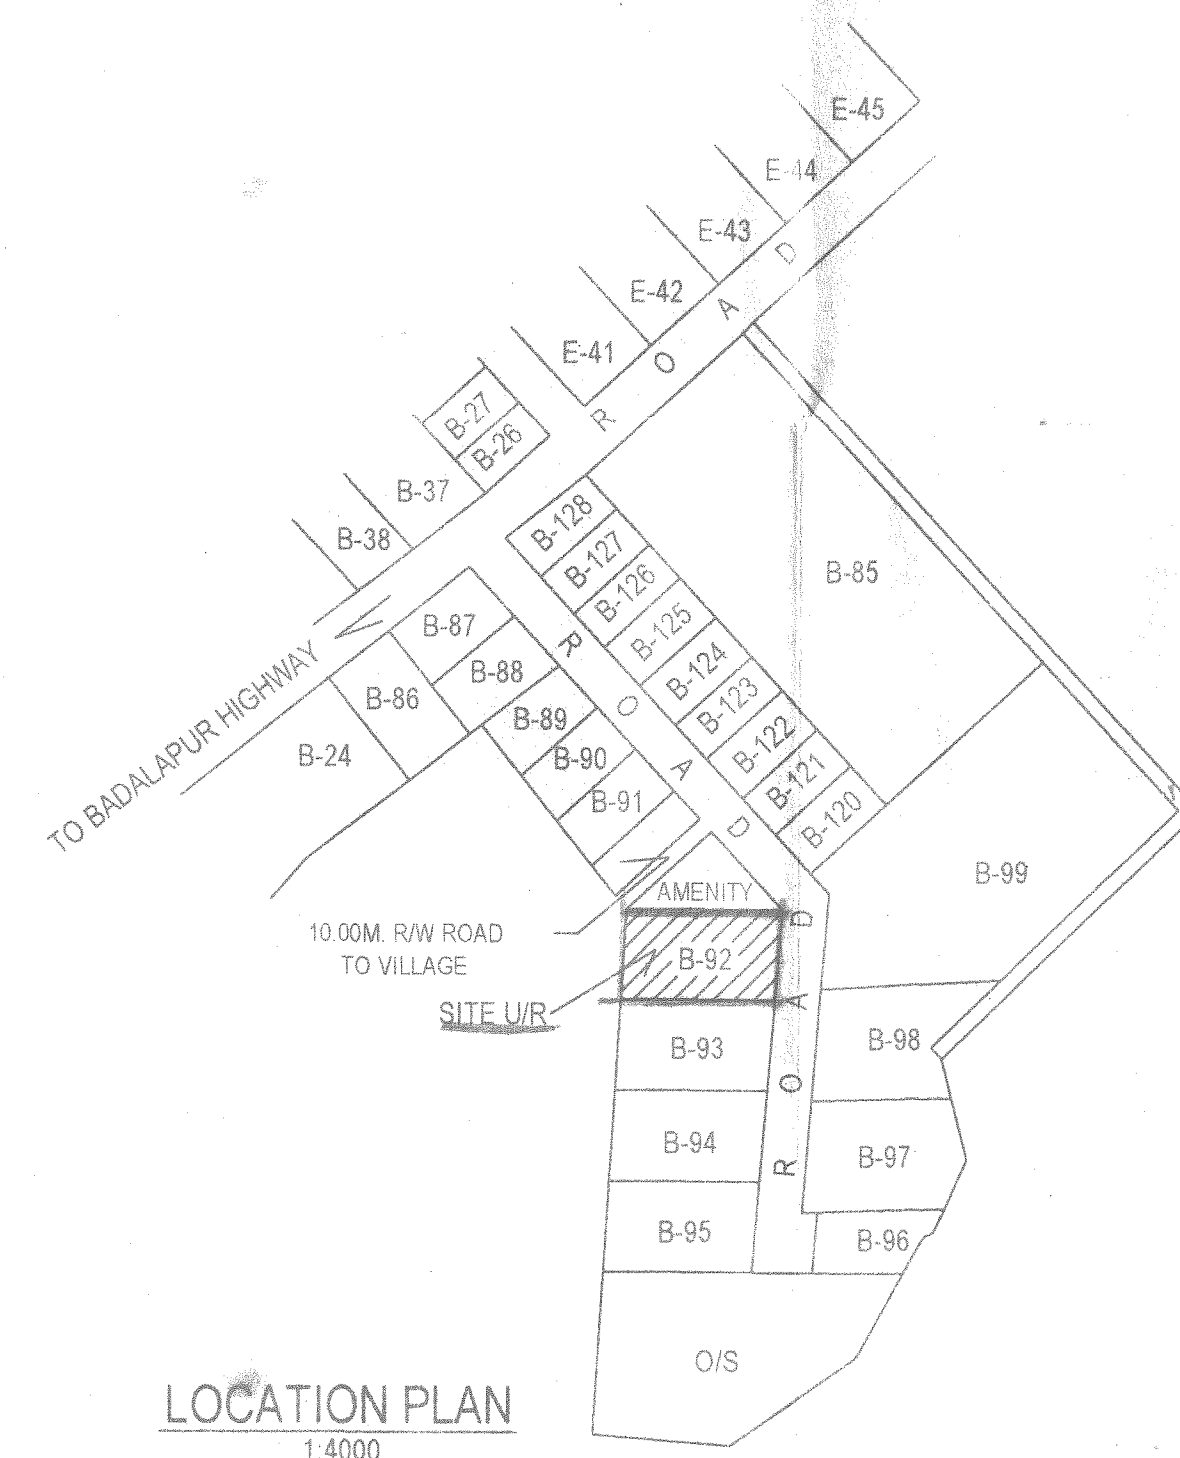
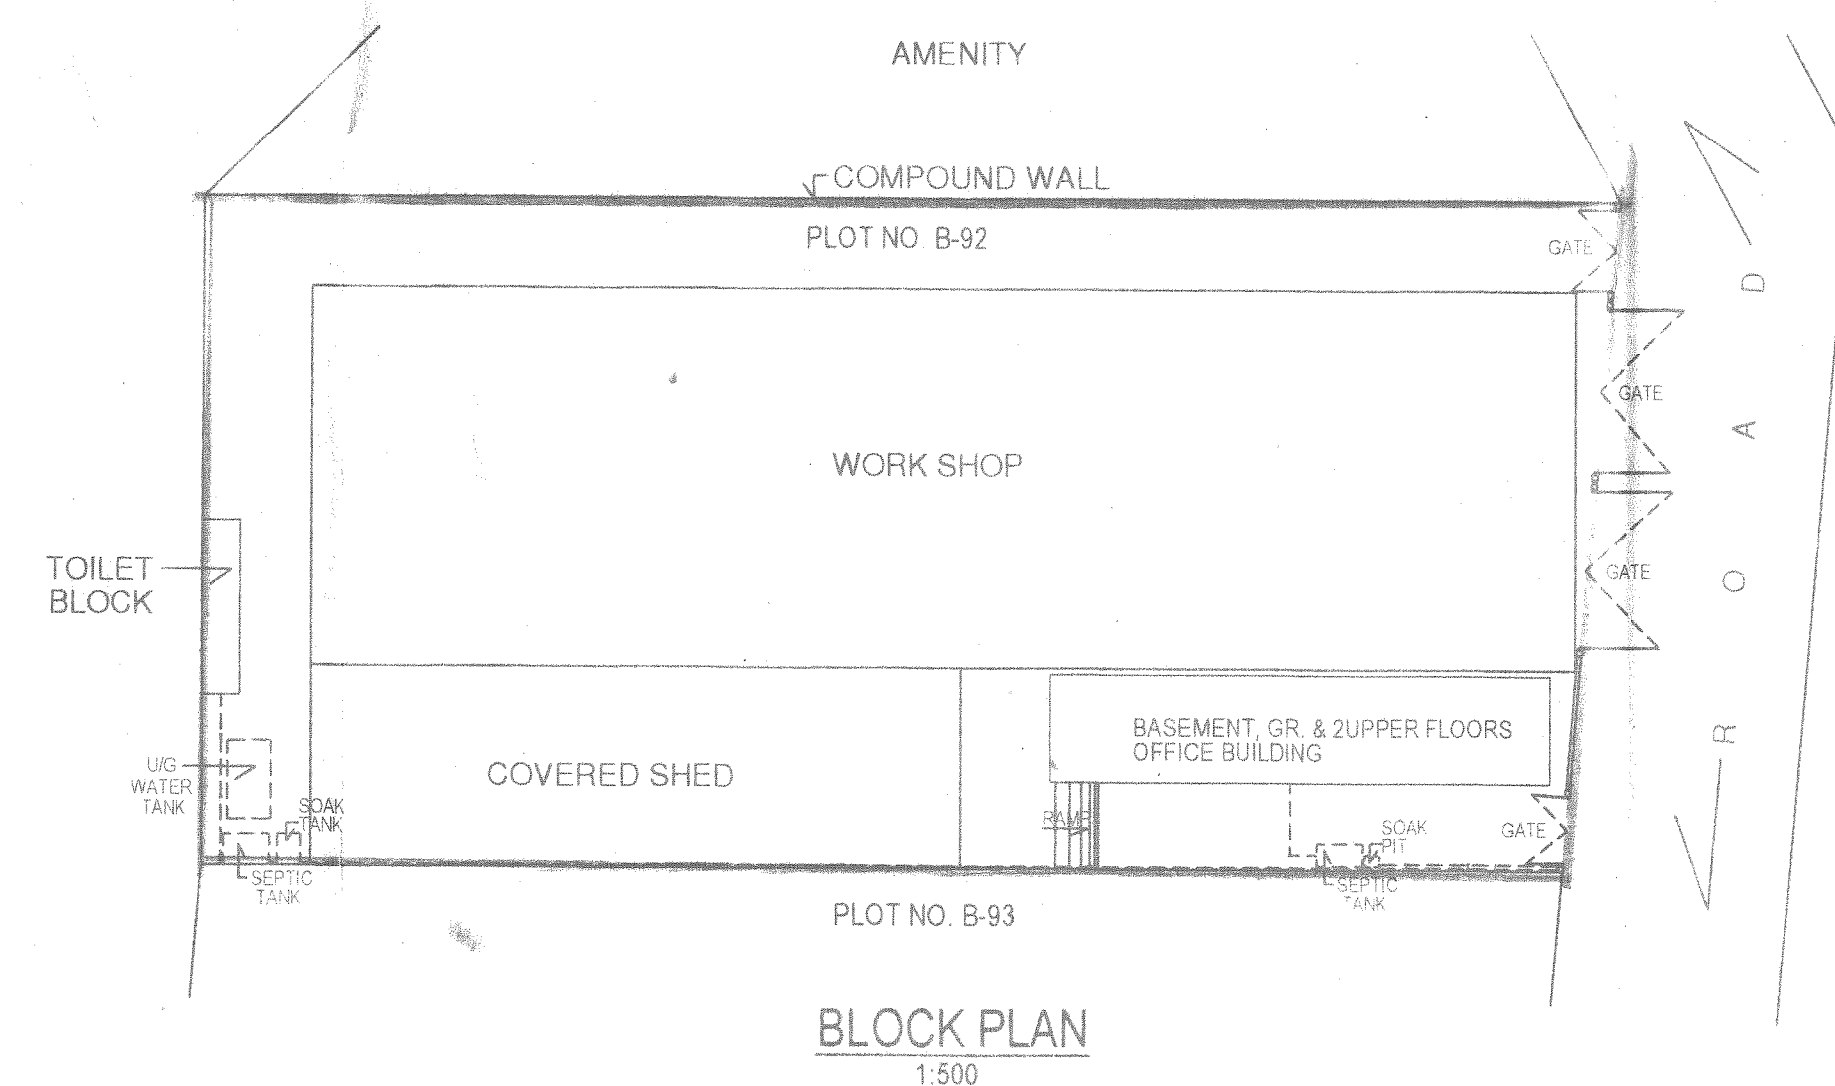
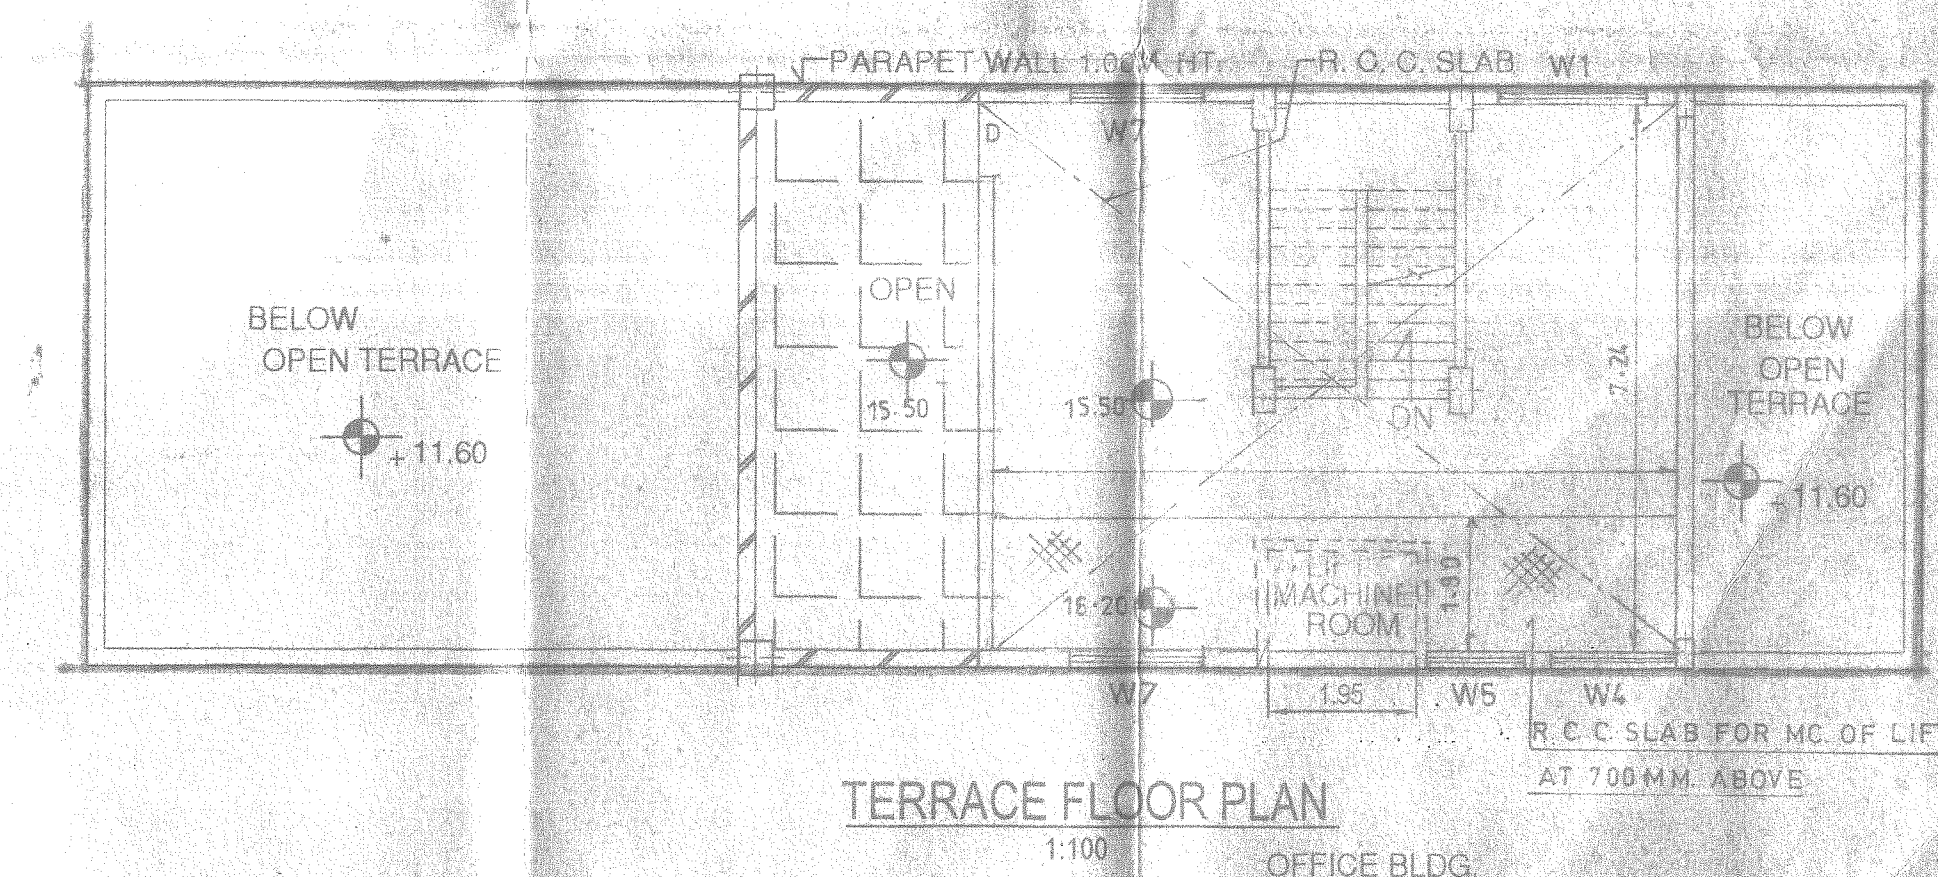
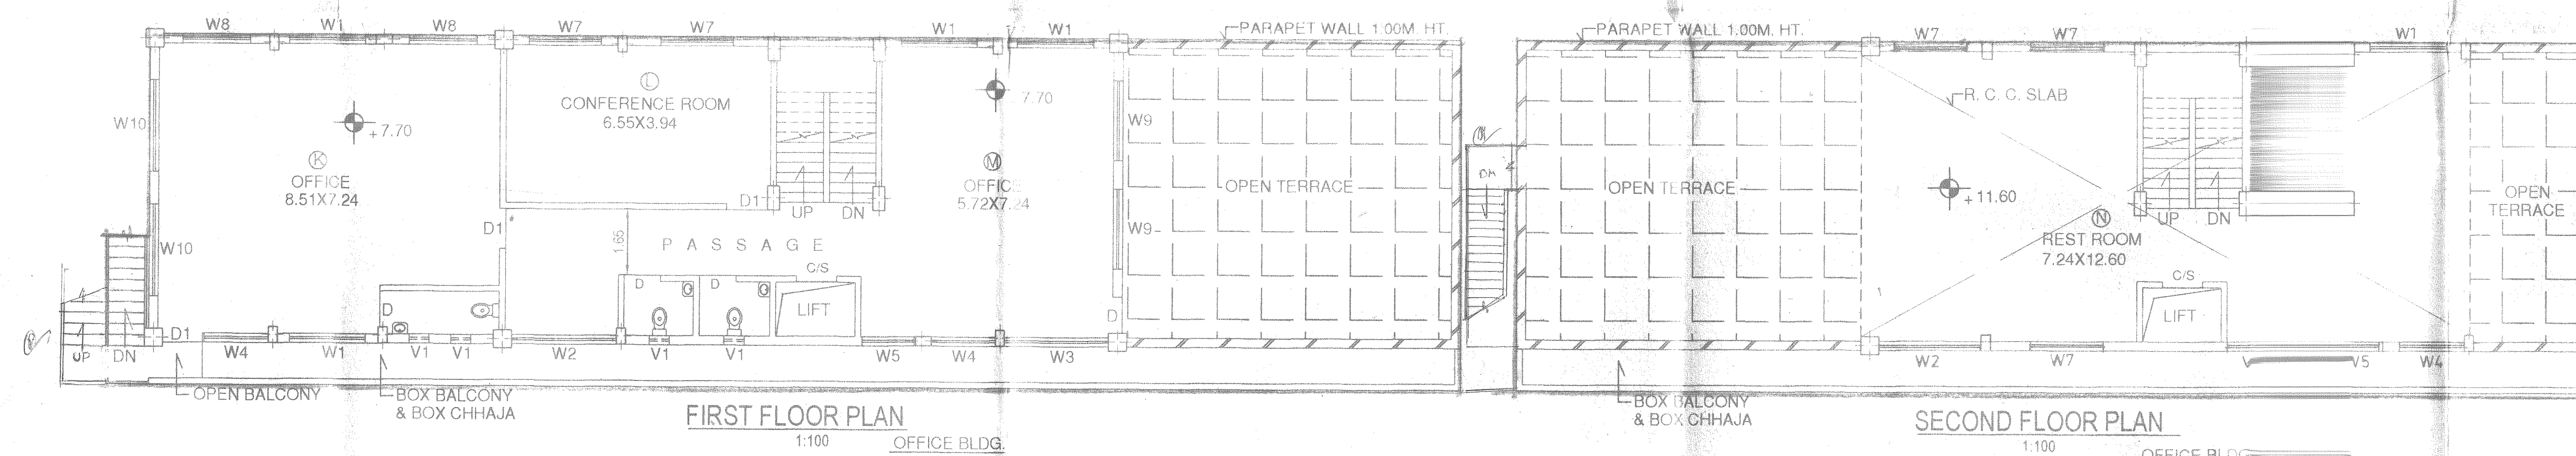
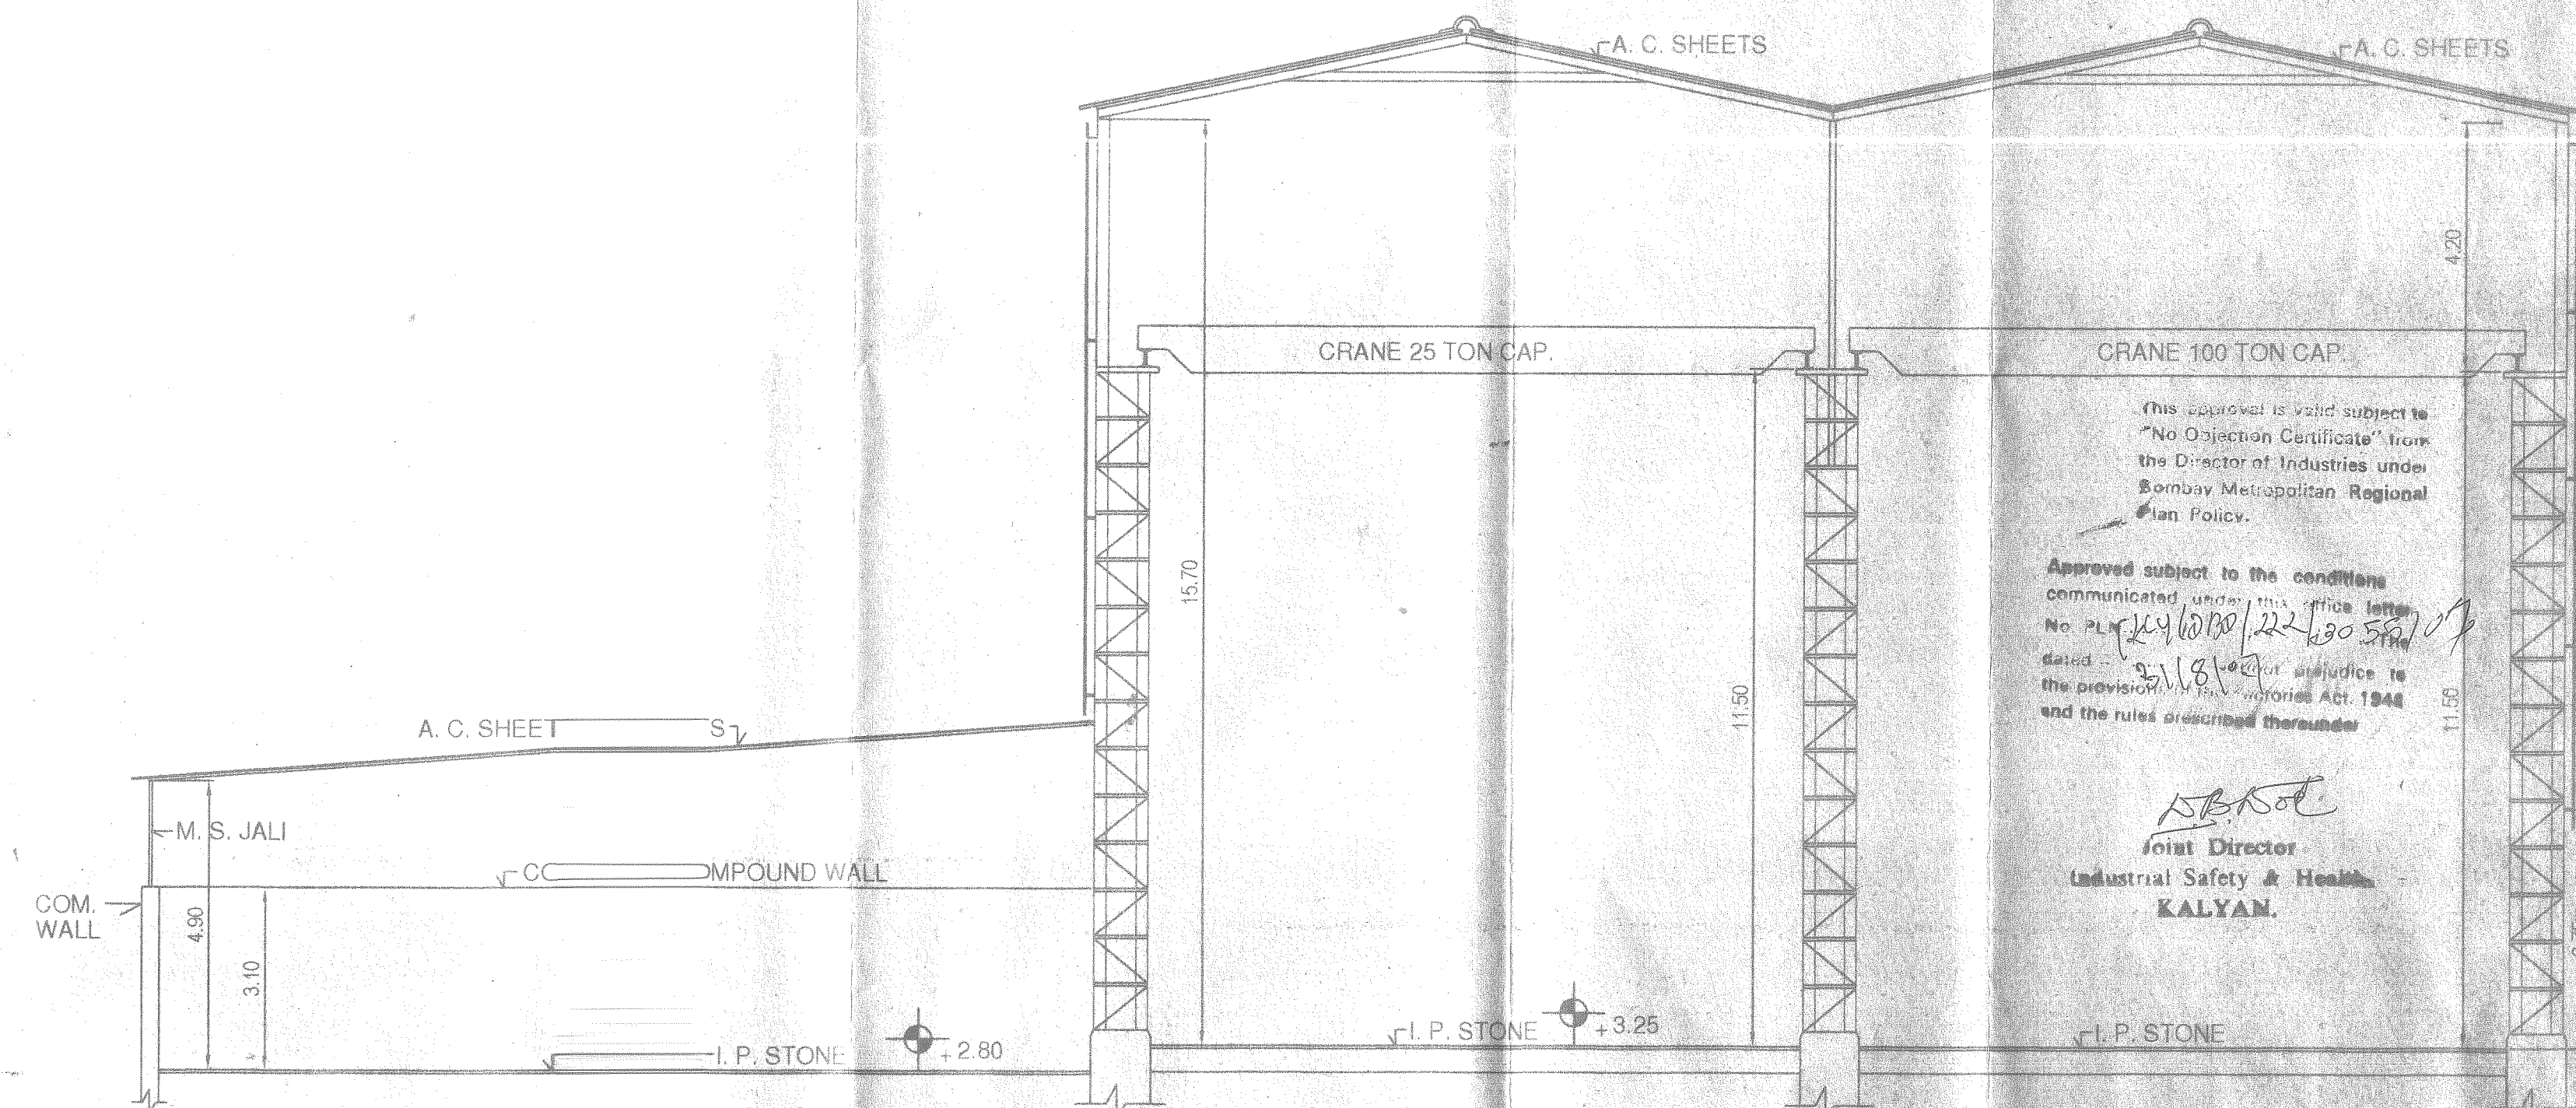


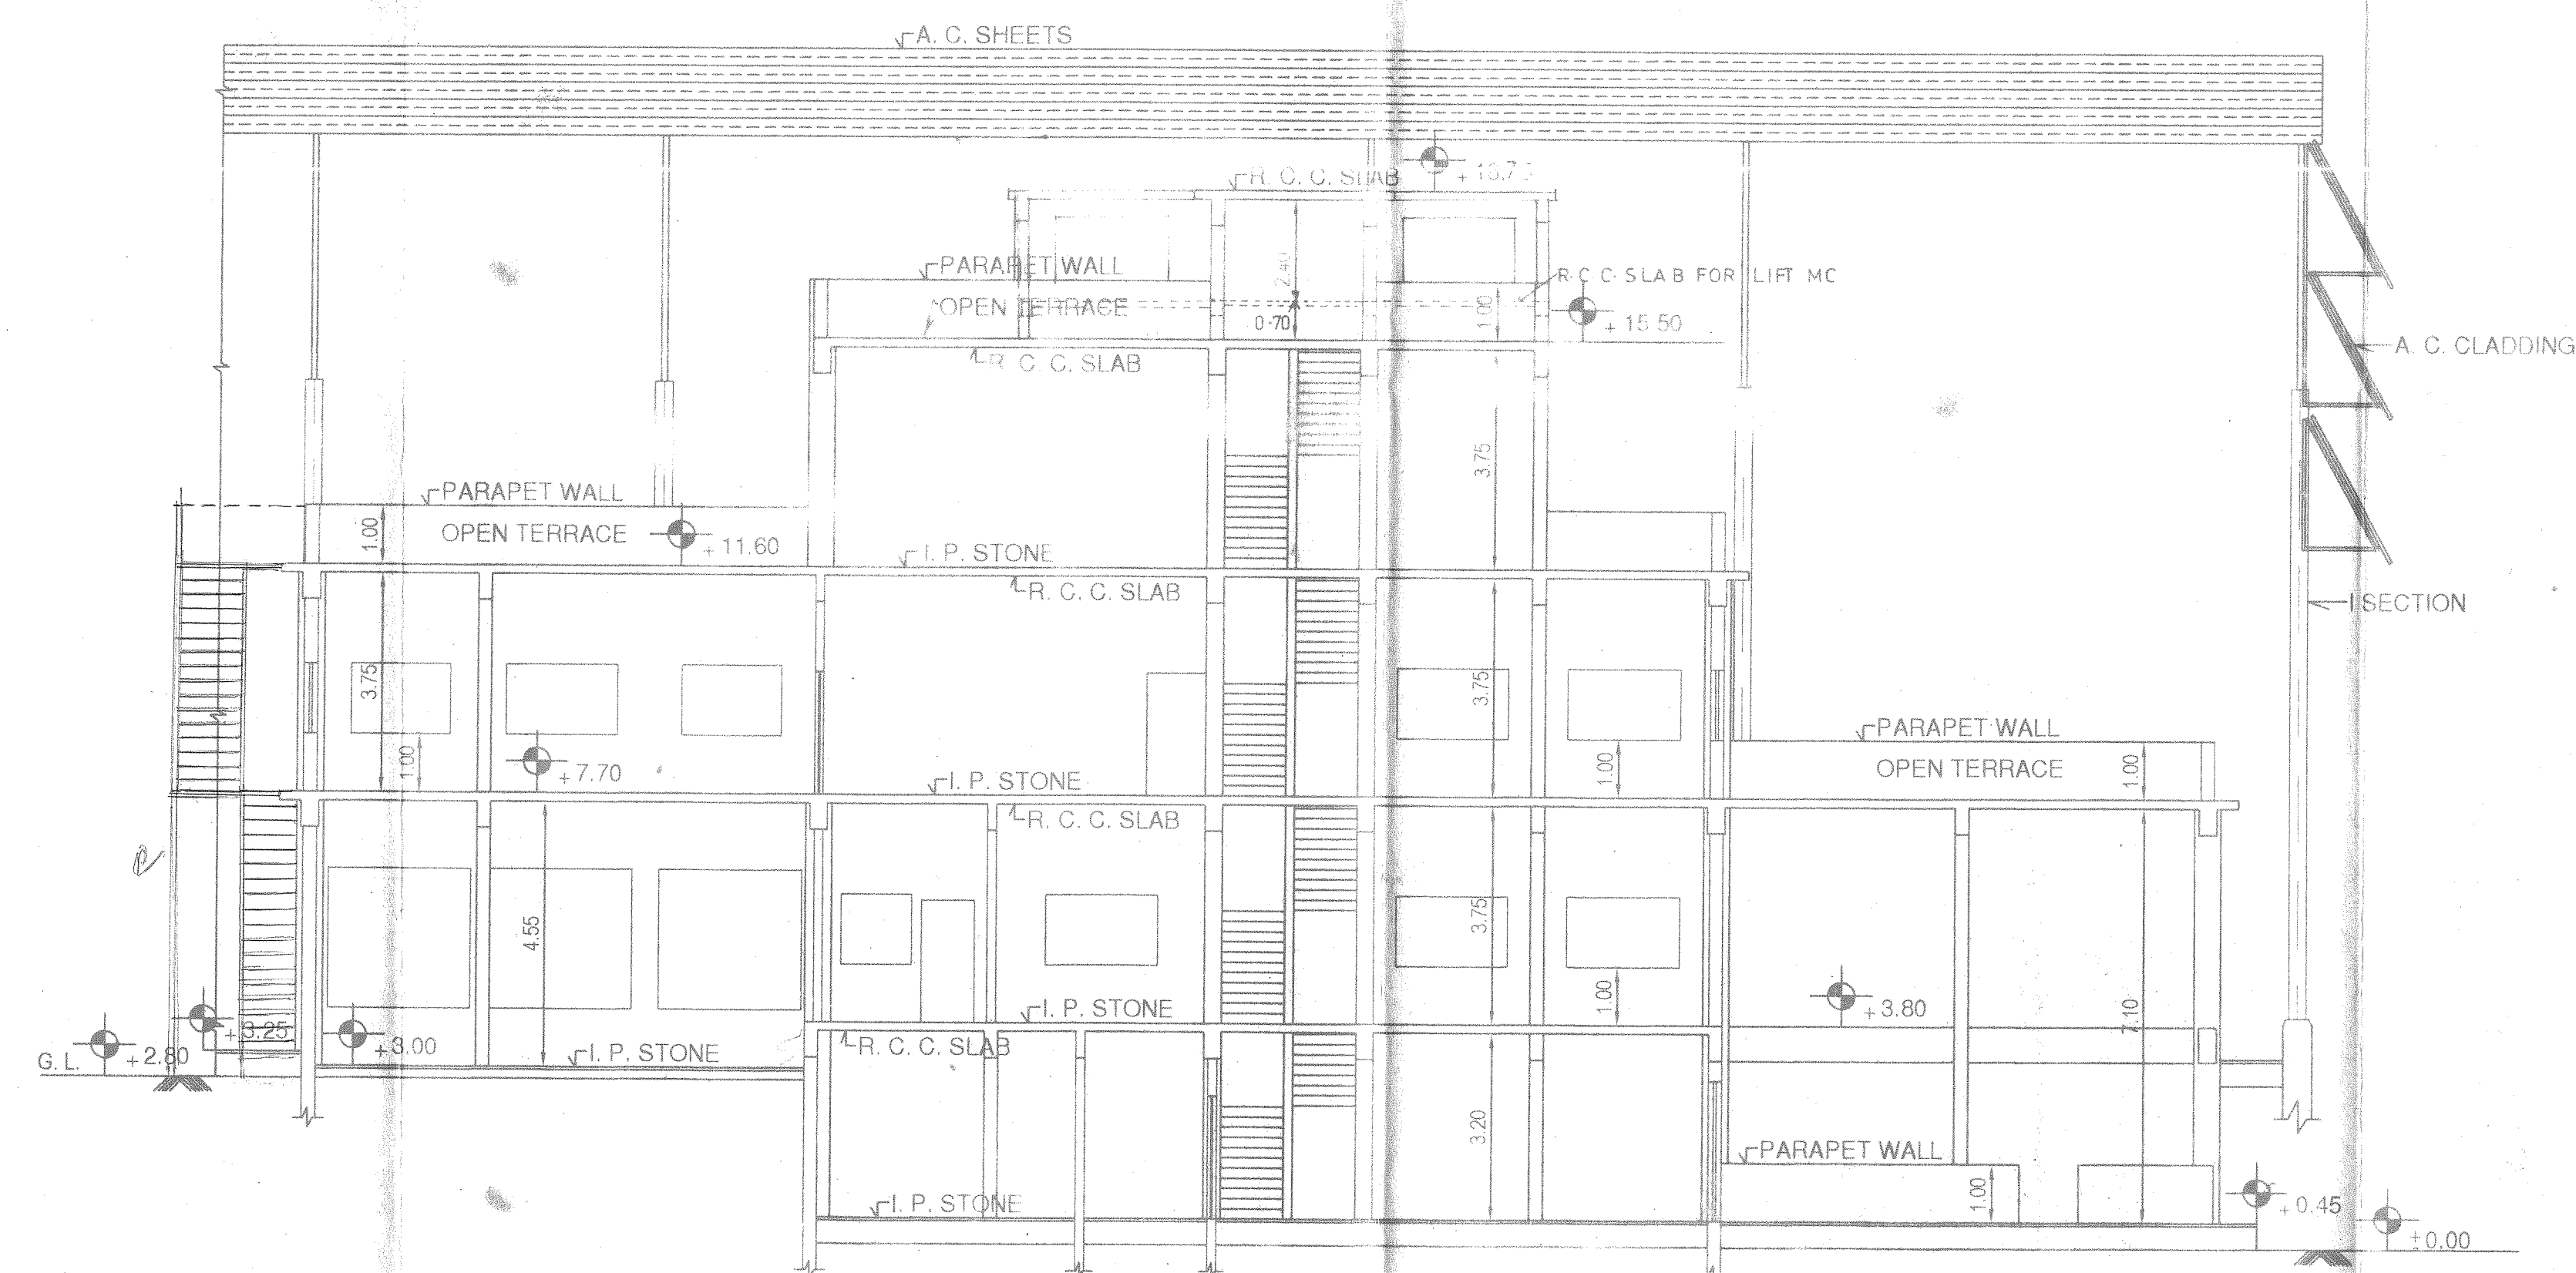

1. FOR MACHINE LAY OUT OF BASEMENT & GROUND FLOOR PLAN
REFER DRG. NO. P-701 B-B.

NOTES-

1. APPLICANTS PREMISES SHOWN THUS _____

2. MACHINERY SHOWN THUS _____

3. URINALS SHOWN THUS _____

4. WASH BASIN SHOWN THUS _____

TECHNO PROCESS - EQUIPMENTS (INDIA) LTD.
PLOT NO. B - 92, M. I. D. C. AMBERNATH (E).
DIST. THANE

MACHINE LAY - OUT
BLOCK PLAN, LOCATION PLAN, X-SECTIONS & UPPER FLOOR PLANS
OF OFFICE BUILDING

DRG.NO.	JOB.NO.	DATE	DRN BY	CHD BY	SCALE
P-701/A-B	701/07	07/07	SHRIKANT	A.C.K.	AS SHOWN